

NOTE: MOUNT THERMOSTATS IN ROOMS 125, 126, 127, 128, 129, 130, 131 & 135 AT A HEIGHT OF 7-0 ABOVE FINISHED FLOOR.

GENERAL NOTES
 1) LOCATE LOCATION OF EQUIPMENT, PIPING, ETC. WITH OTHER TRADES.
 2) INSTALL ALL EQUIPMENT IN CENTRAL CEILING AS CLOSE TO CHASING AS POSSIBLE.

PHASE TWO work indicated thus. All other information is Phase One, under construction, and is for reference only. Coordinate all PHASE TWO activity with Donlar Corp., Phase One General Contractor.

PUR HYDRONIC SUPPLY
 1) CENTRAL PIPING ROOM
 2) WEST SIDE OF WALL
 3) CONCEALED FOR UNIT 2, 3, 4, 5, 6, 7

1 ACTIVITY CENTER LOWER PLAN - HVAC
 SCALE: 1/16" = 1'-0"

2 ACTIVITY CENTER UPPER PLAN - HVAC
 SCALE: 1/16" = 1'-0"




KEY PLAN


Sövik Mathre Sathrum Quanbeck Architects Planners | 205 South Water Street | Box 390 | Northfield Minnesota 55057 | 507-645-4461 | 612-336-8679
Halenbeck Hall Addition
 St. Cloud State University
 St. Cloud, Minnesota
 PHASE TWO
M 2.6

CONSULTANT
LUNDQUIST
 Leonard A. Lundquist
 Professional Engineer
 License No. 7323
 State of Minnesota
 114 North State Street
 St. Paul, Minnesota 55101
 Account 1.0-01-034304

Revisions
 Job: 1105
 Checked: [Signature]
 Date: 2-3-79
 Drawn: [Signature]

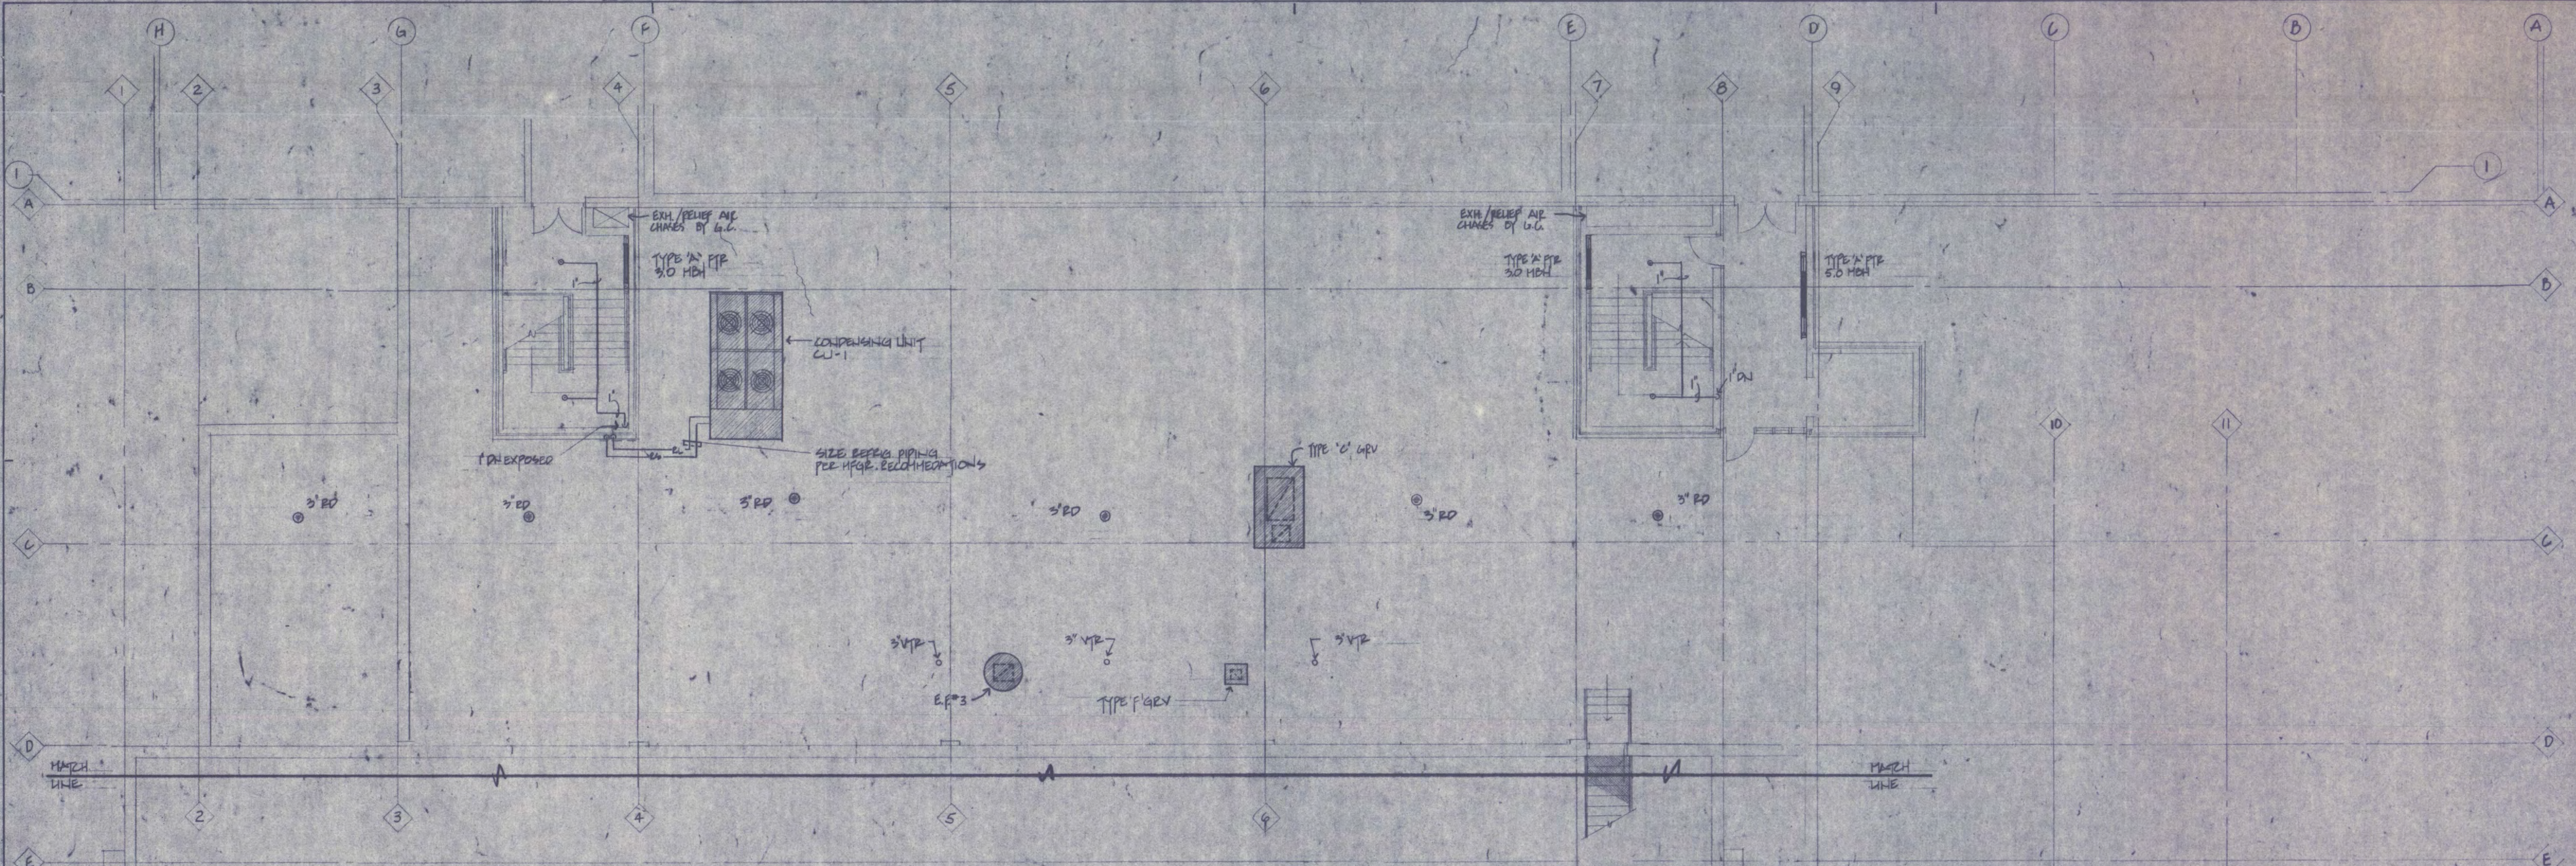


1 THIRD FLOOR PLAN / ROOF PLAN - PLUMBING, FIRE PROTECTION & HVAC
 SCALE: 1/8" = 1'-0"

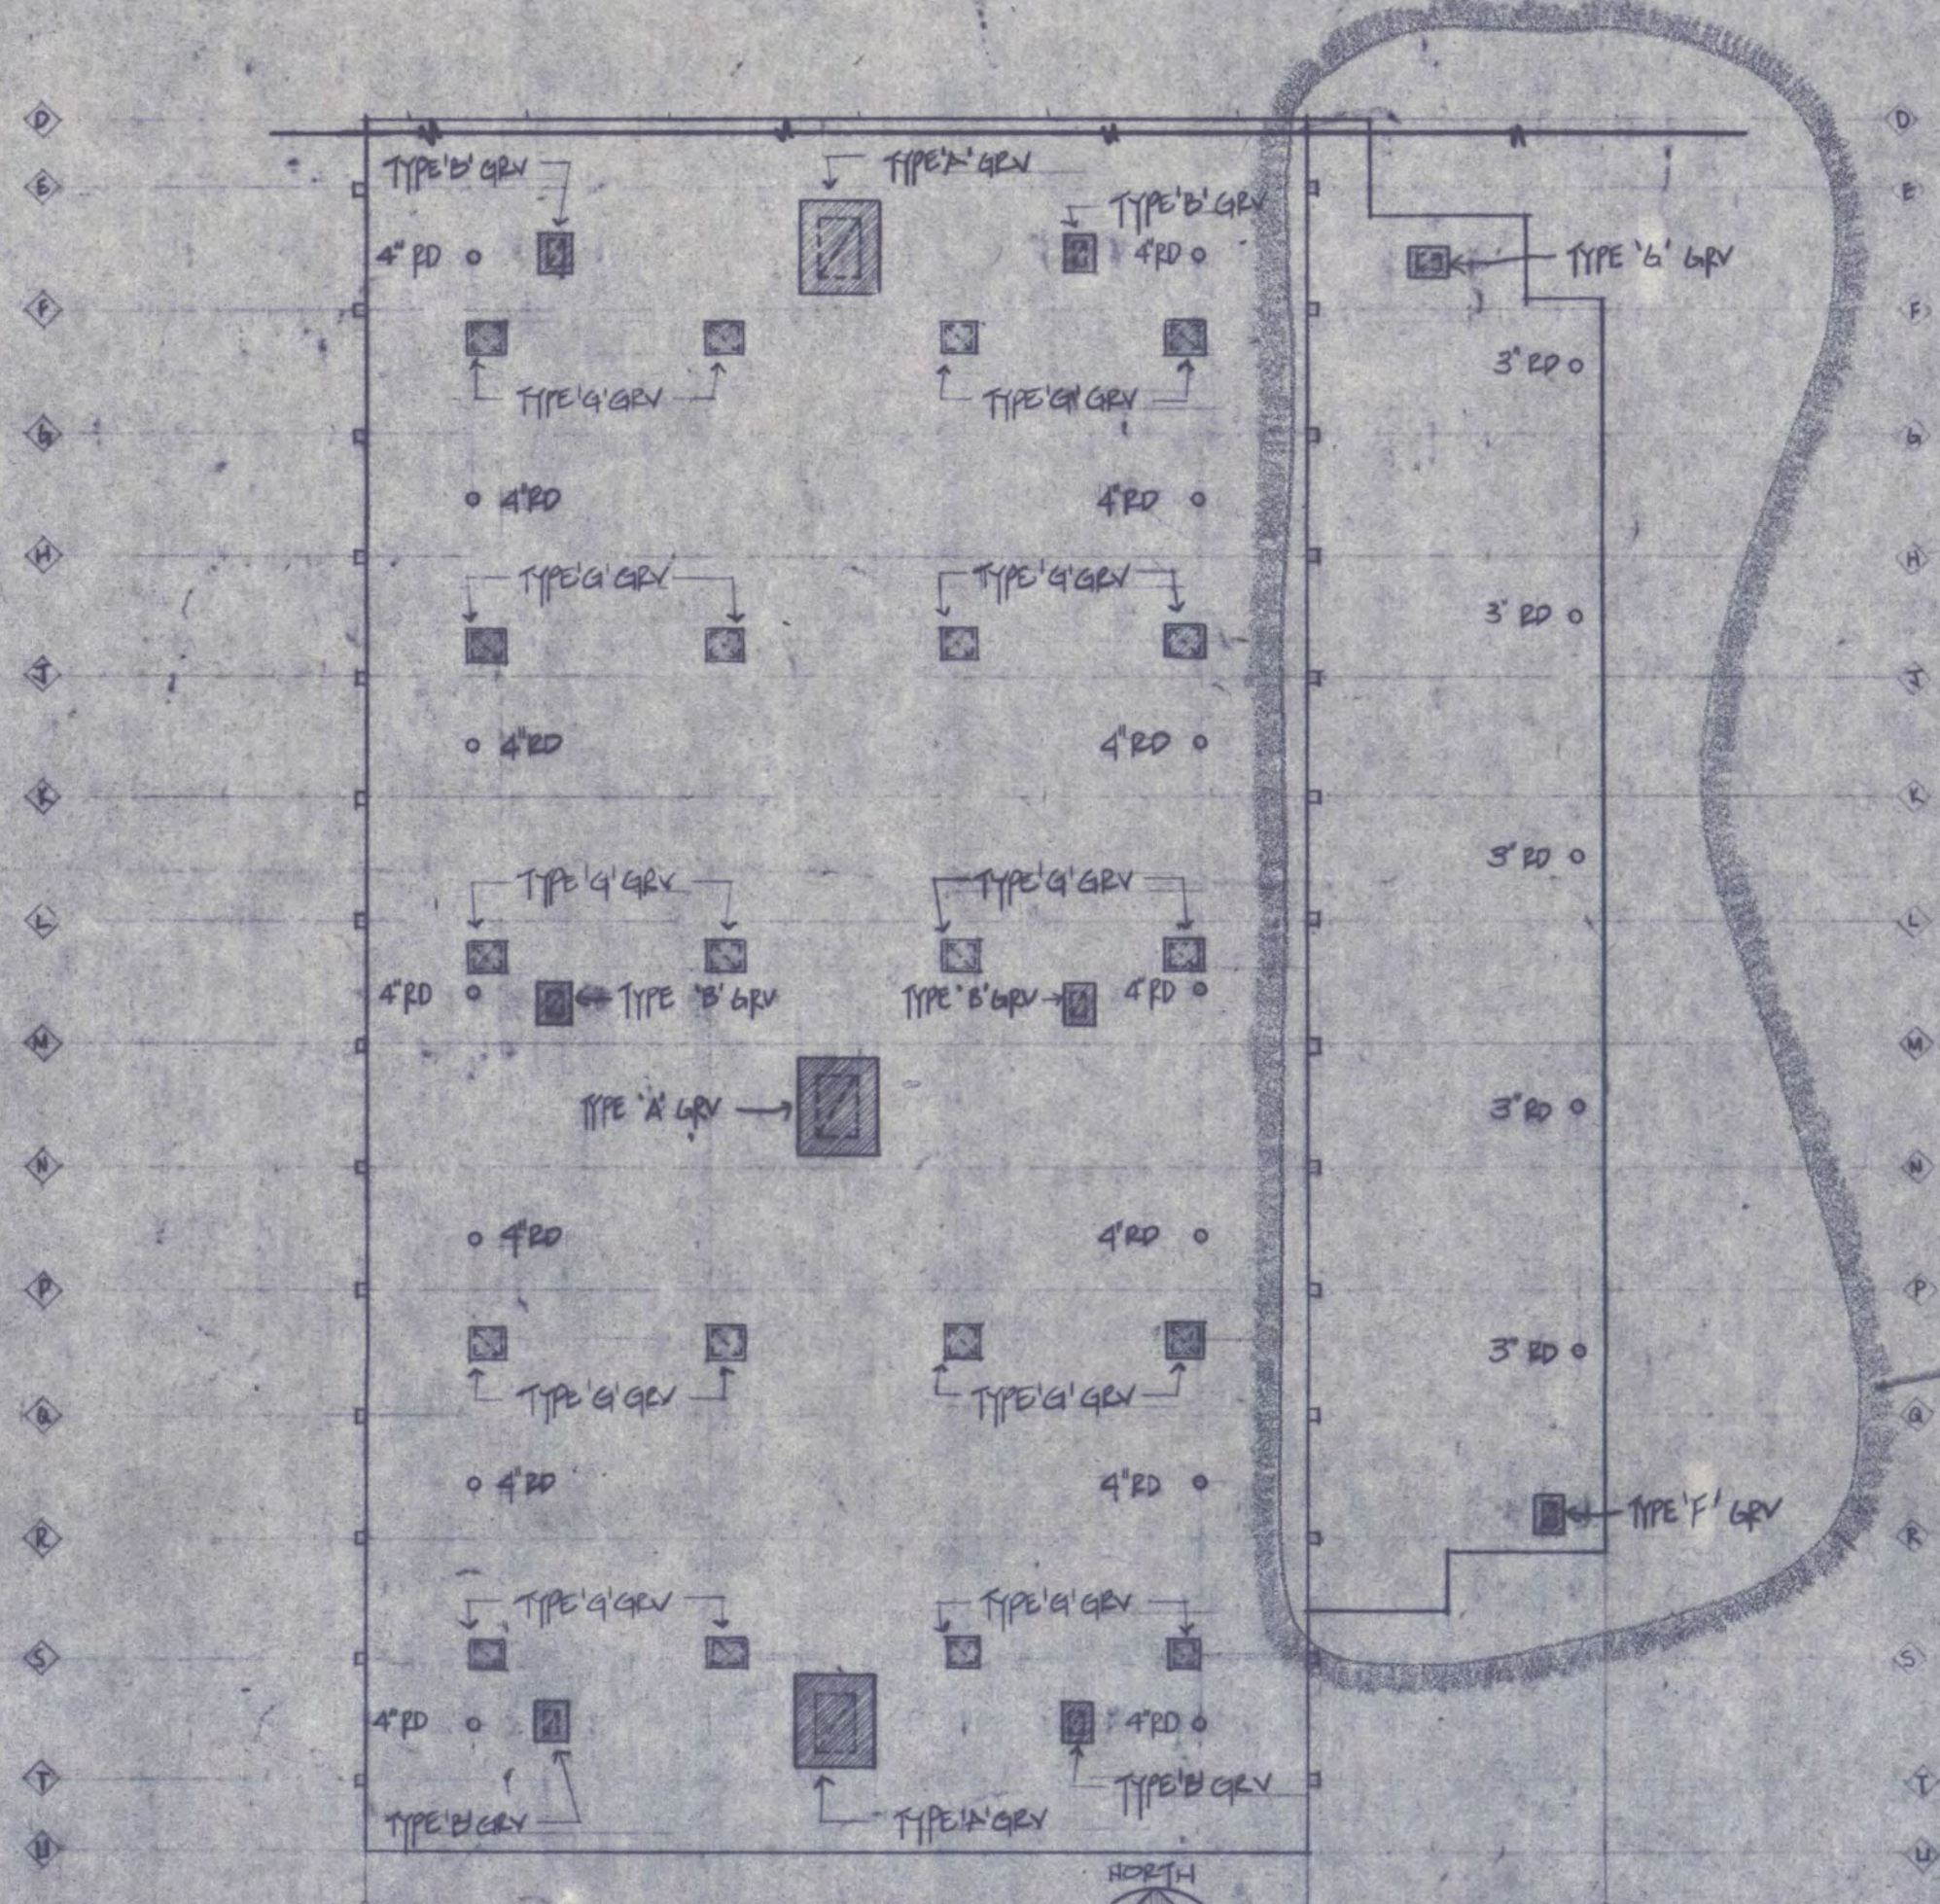

2 ROOF PLAN
 SCALE: 1/32" = 1'-0"


PHASE TWO work indicated thus. All other information is Phase One, under construction, and is for reference only. Coordinate all PHASE TWO activity with Donlar Corp., Phase One General Contractor.

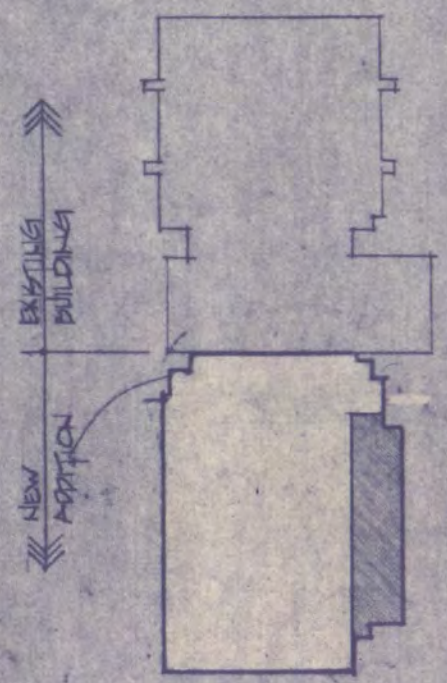


KEY PLAN




SWSA Sövik Mathre Sathrum Quanbeck Architects Planners | 205 South Water Street | Box 390 | Northfield Minnesota 55057 | 507-645-4461 | 612-336-8679
Phase Two
 STATE OF MINNESOTA
 Department of Administration
 Architectural & Engineering Division
 Room 6-10 Administration Building
 P.O. Box 100, St. Paul, Minnesota 55101
 Account 1-D, No. 054304
Halenbeck Hall Addition
 St. Cloud State University
 St. Cloud
 Minnesota
 PHASE TWO
M 2.7
 Revisions
 CONSULTANT: **LUNDQUIST**
 lundquist, wilmer, schultz and martin
 44 West Office
 6222311000
 Job: 1105 Checked: [Signature]
 Drawn: [Signature] Date: 6-3-79

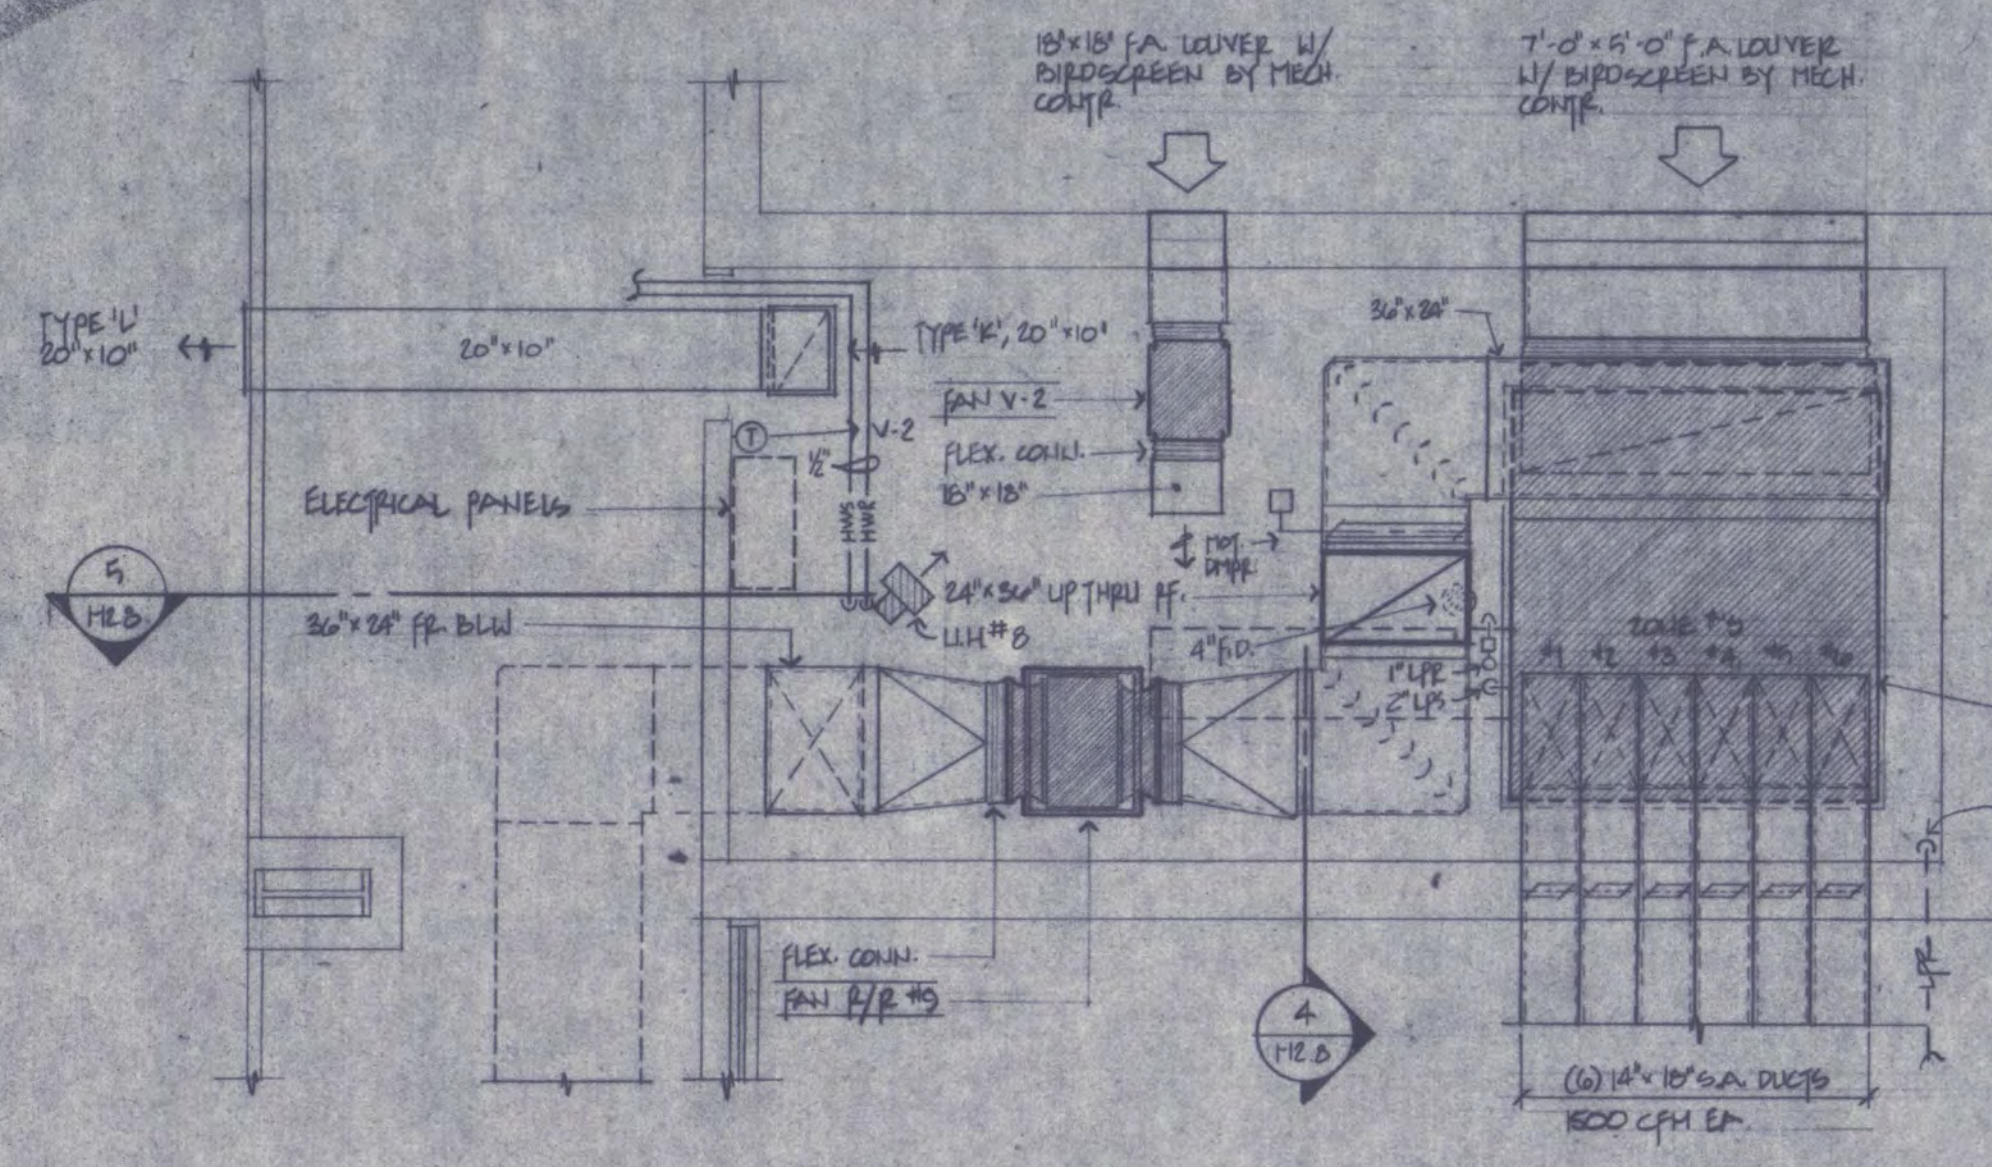


1 MECHANICAL ROOM 225-PLAN (BASE BID)
SCALE: 1/4" = 1'-0"

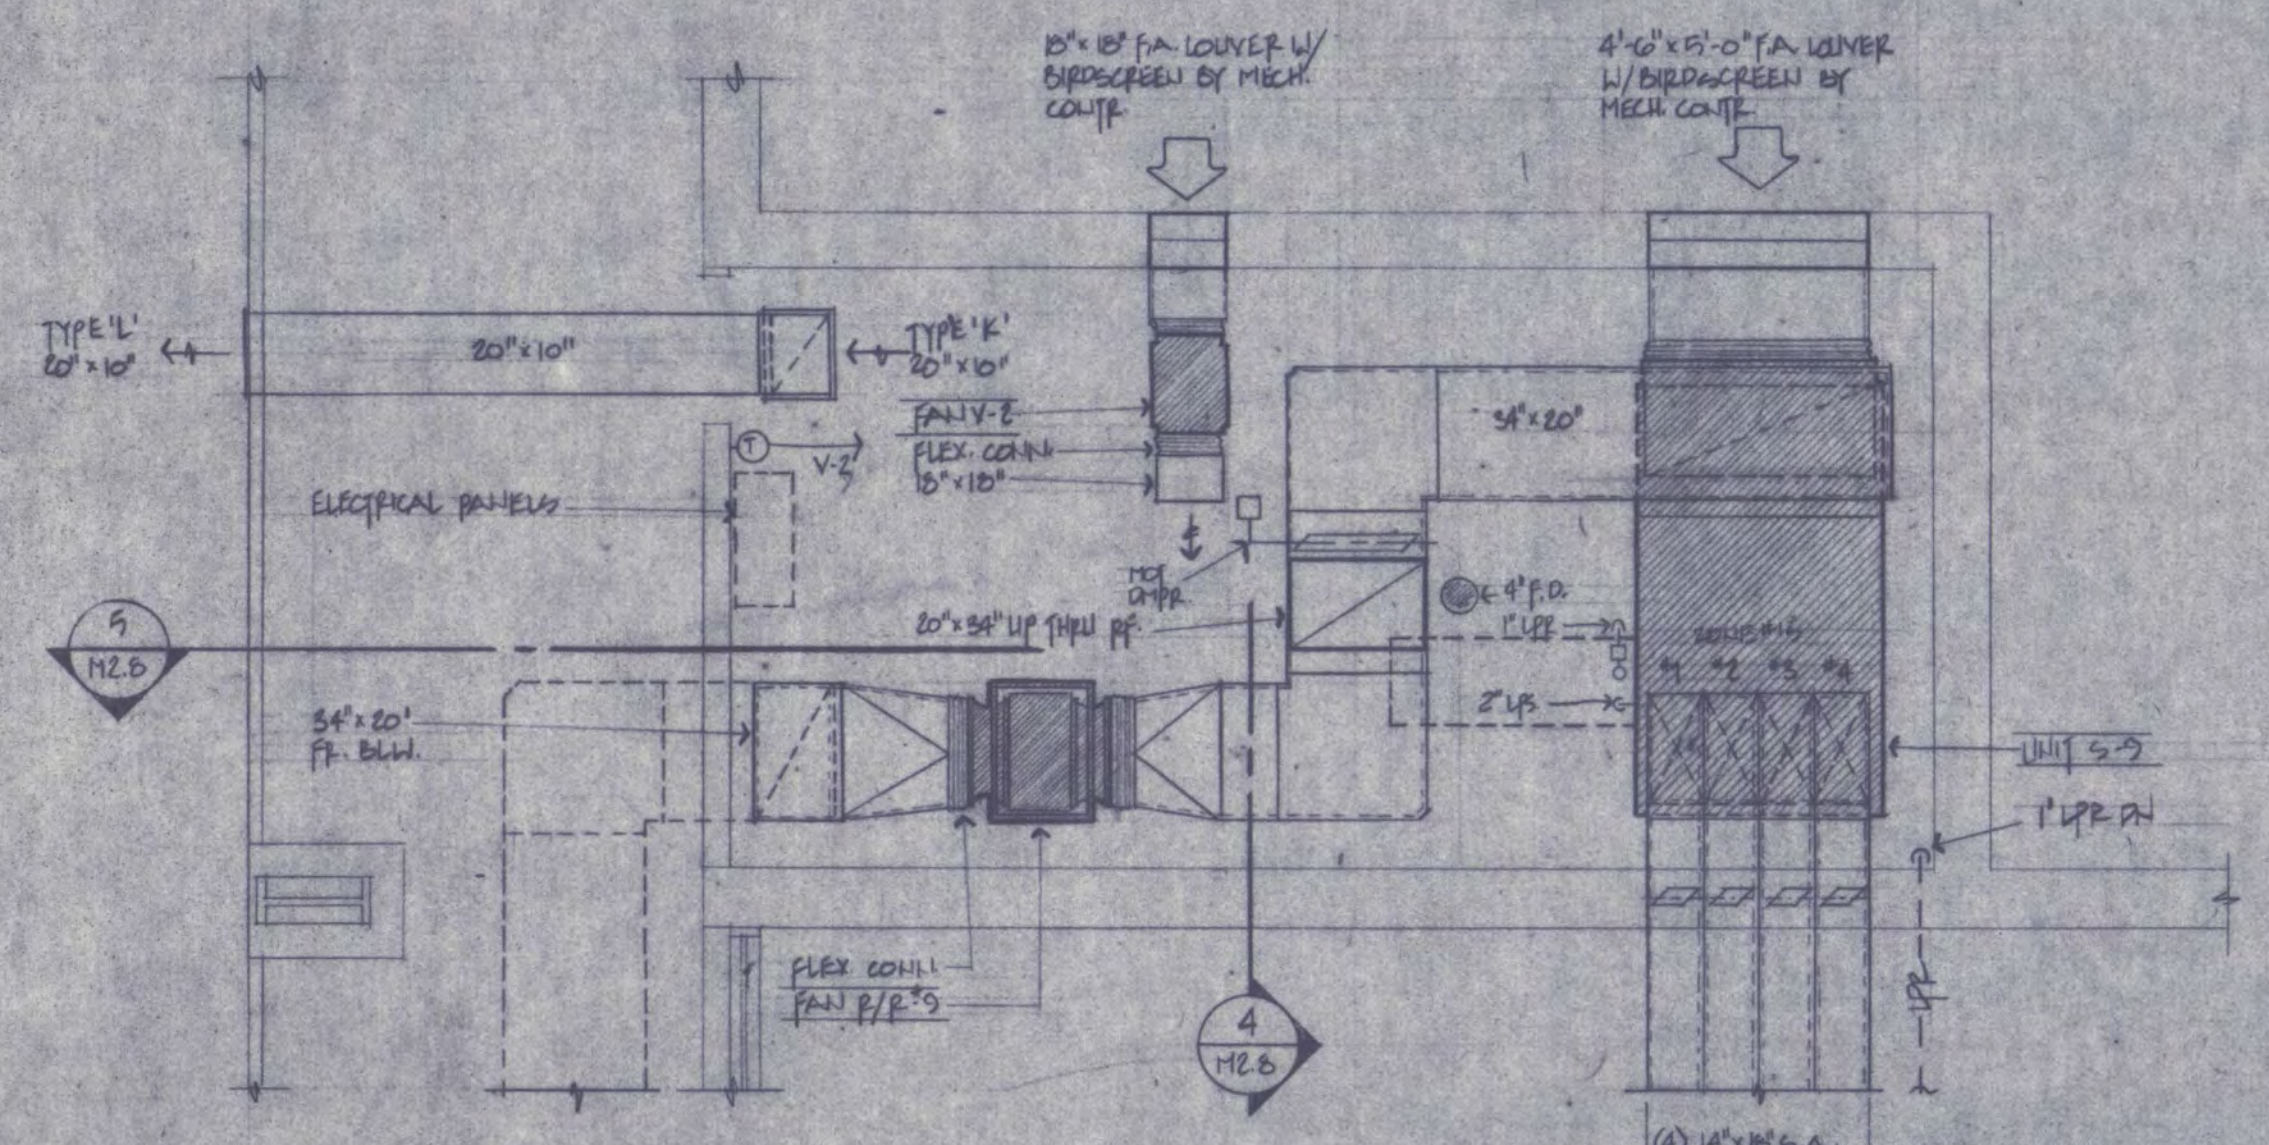

2 MECHANICAL ROOM 225-PLAN (DED. ALT #3)
SCALE: 1/4" = 1'-0"

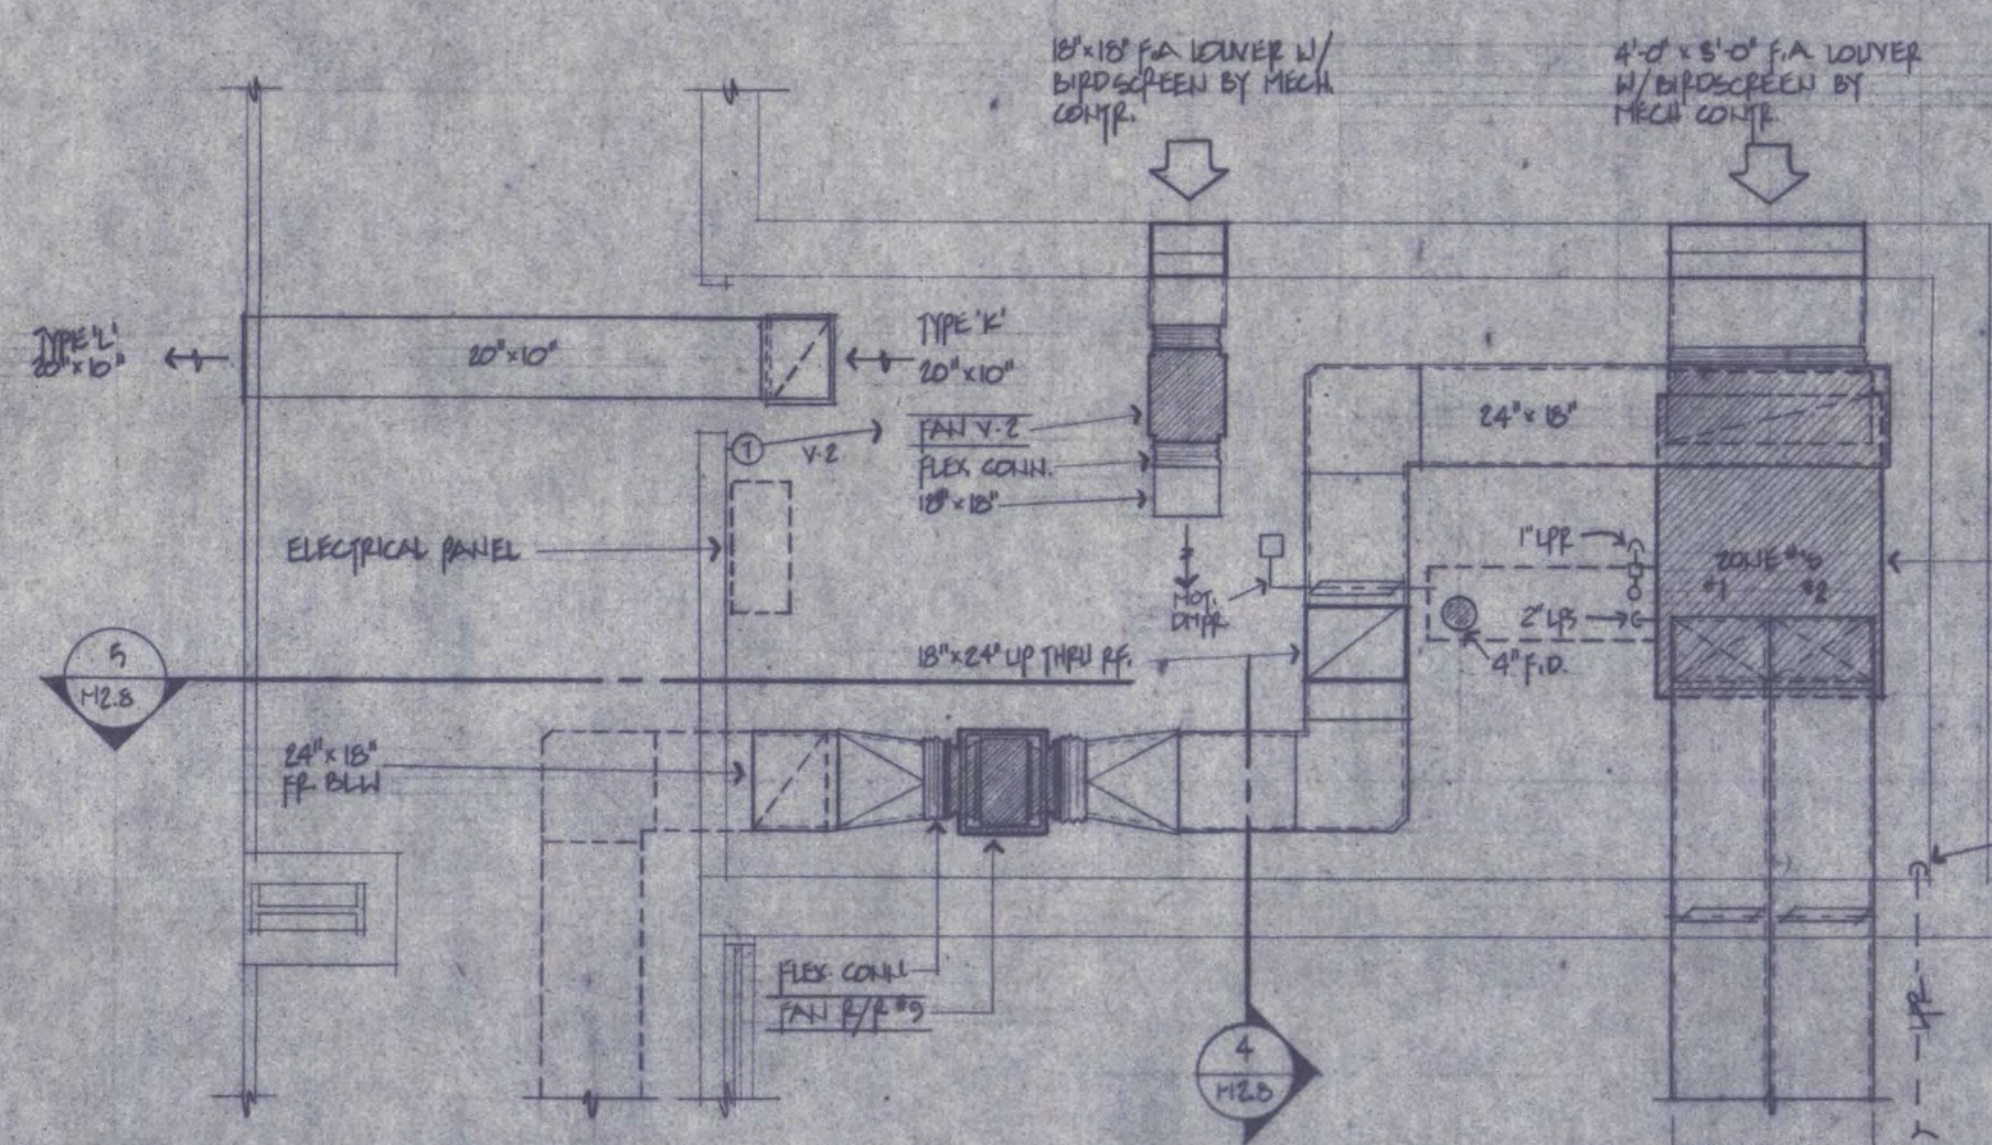


3 MECHANICAL ROOM 225-PLAN (DED. ALT #4)
SCALE: 1/4" = 1'-0"

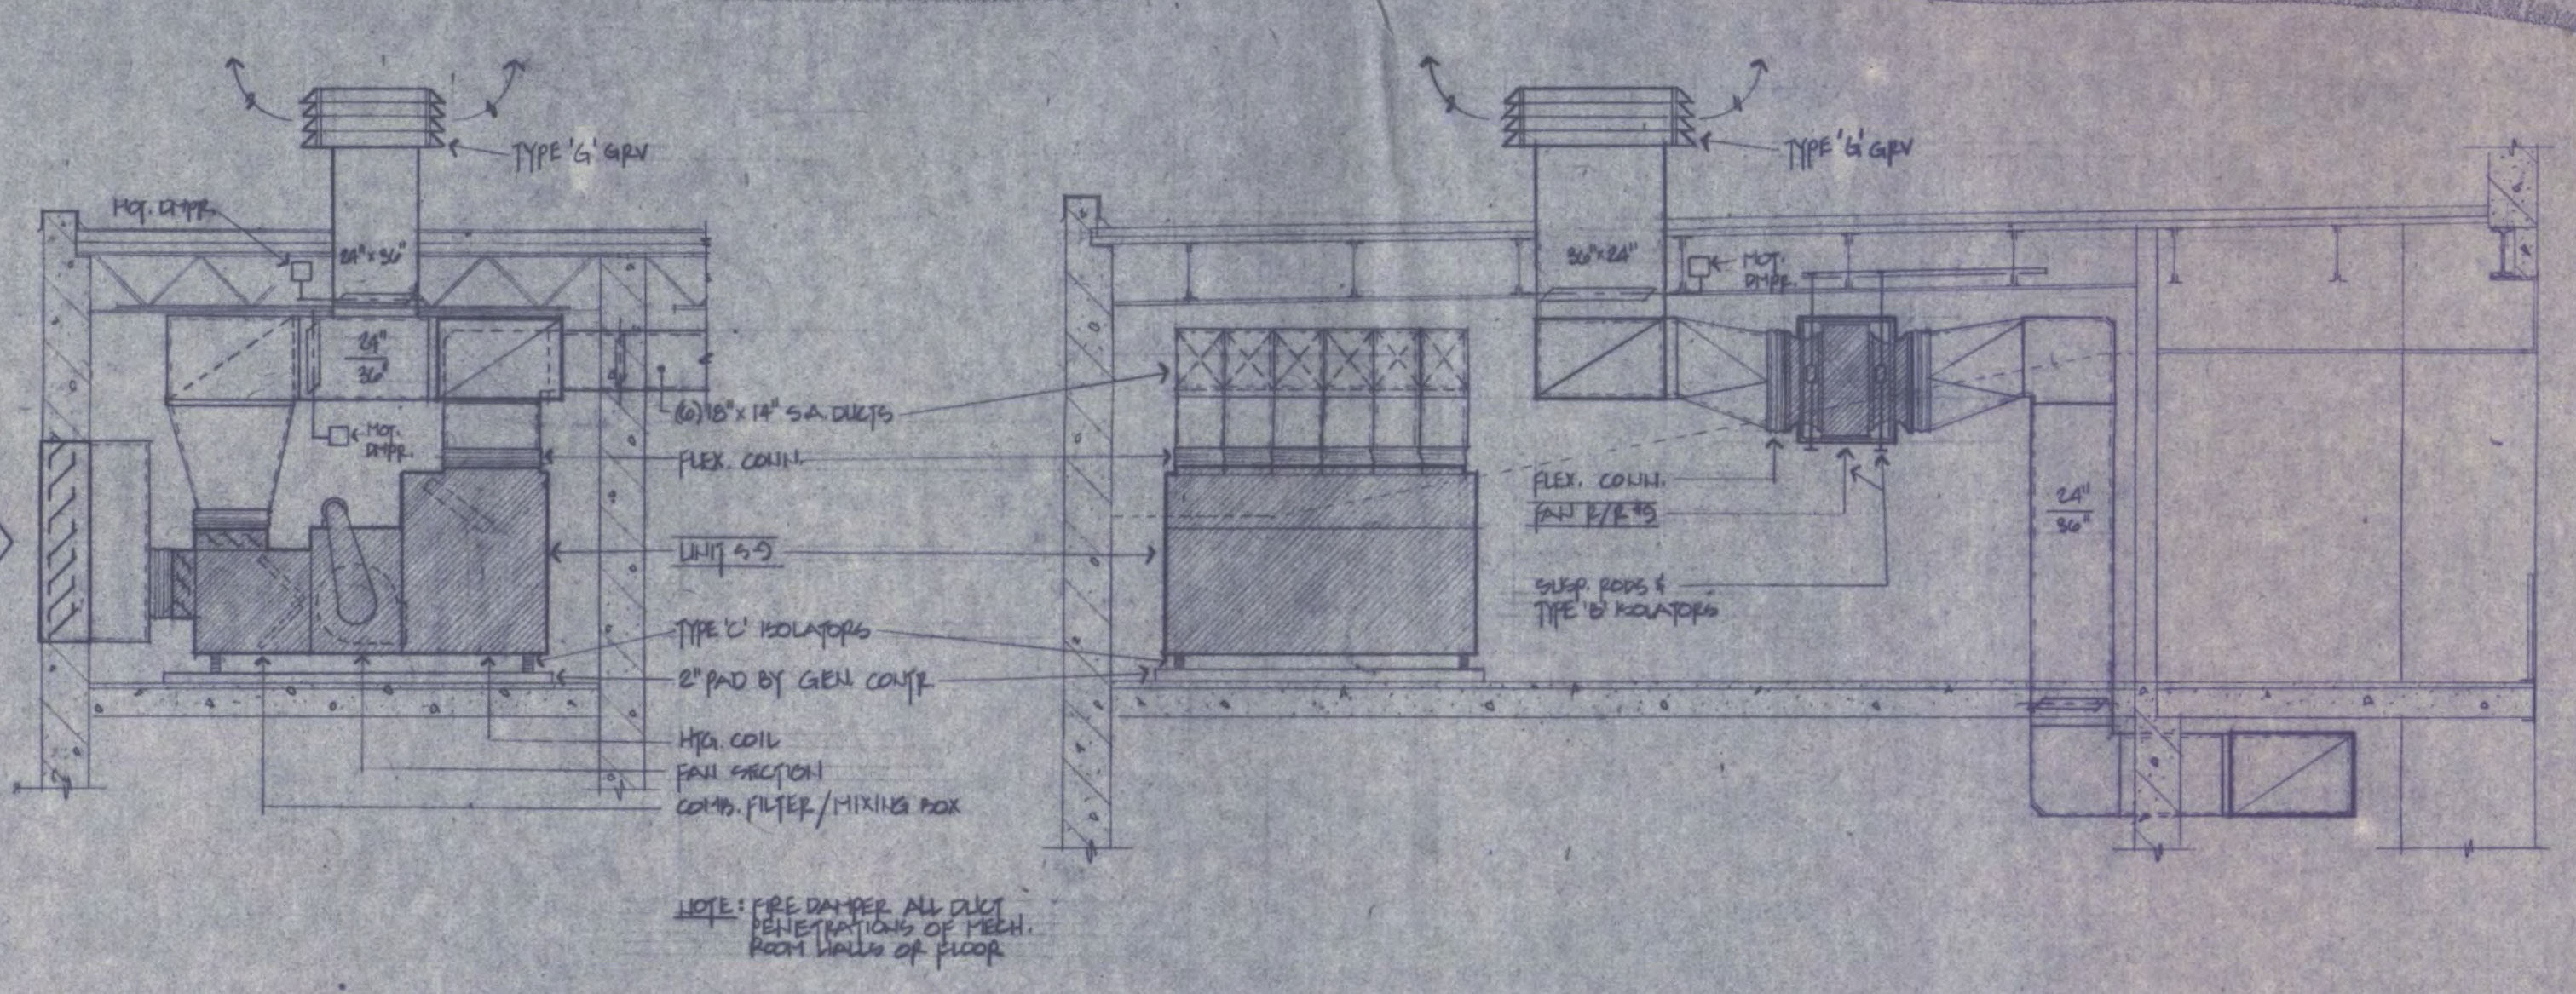


4 ELEVATION (BASE BID)
SCALE: 1/4" = 1'-0"


5 ELEVATION (BASE BID)
SCALE: 1/4" = 1'-0"

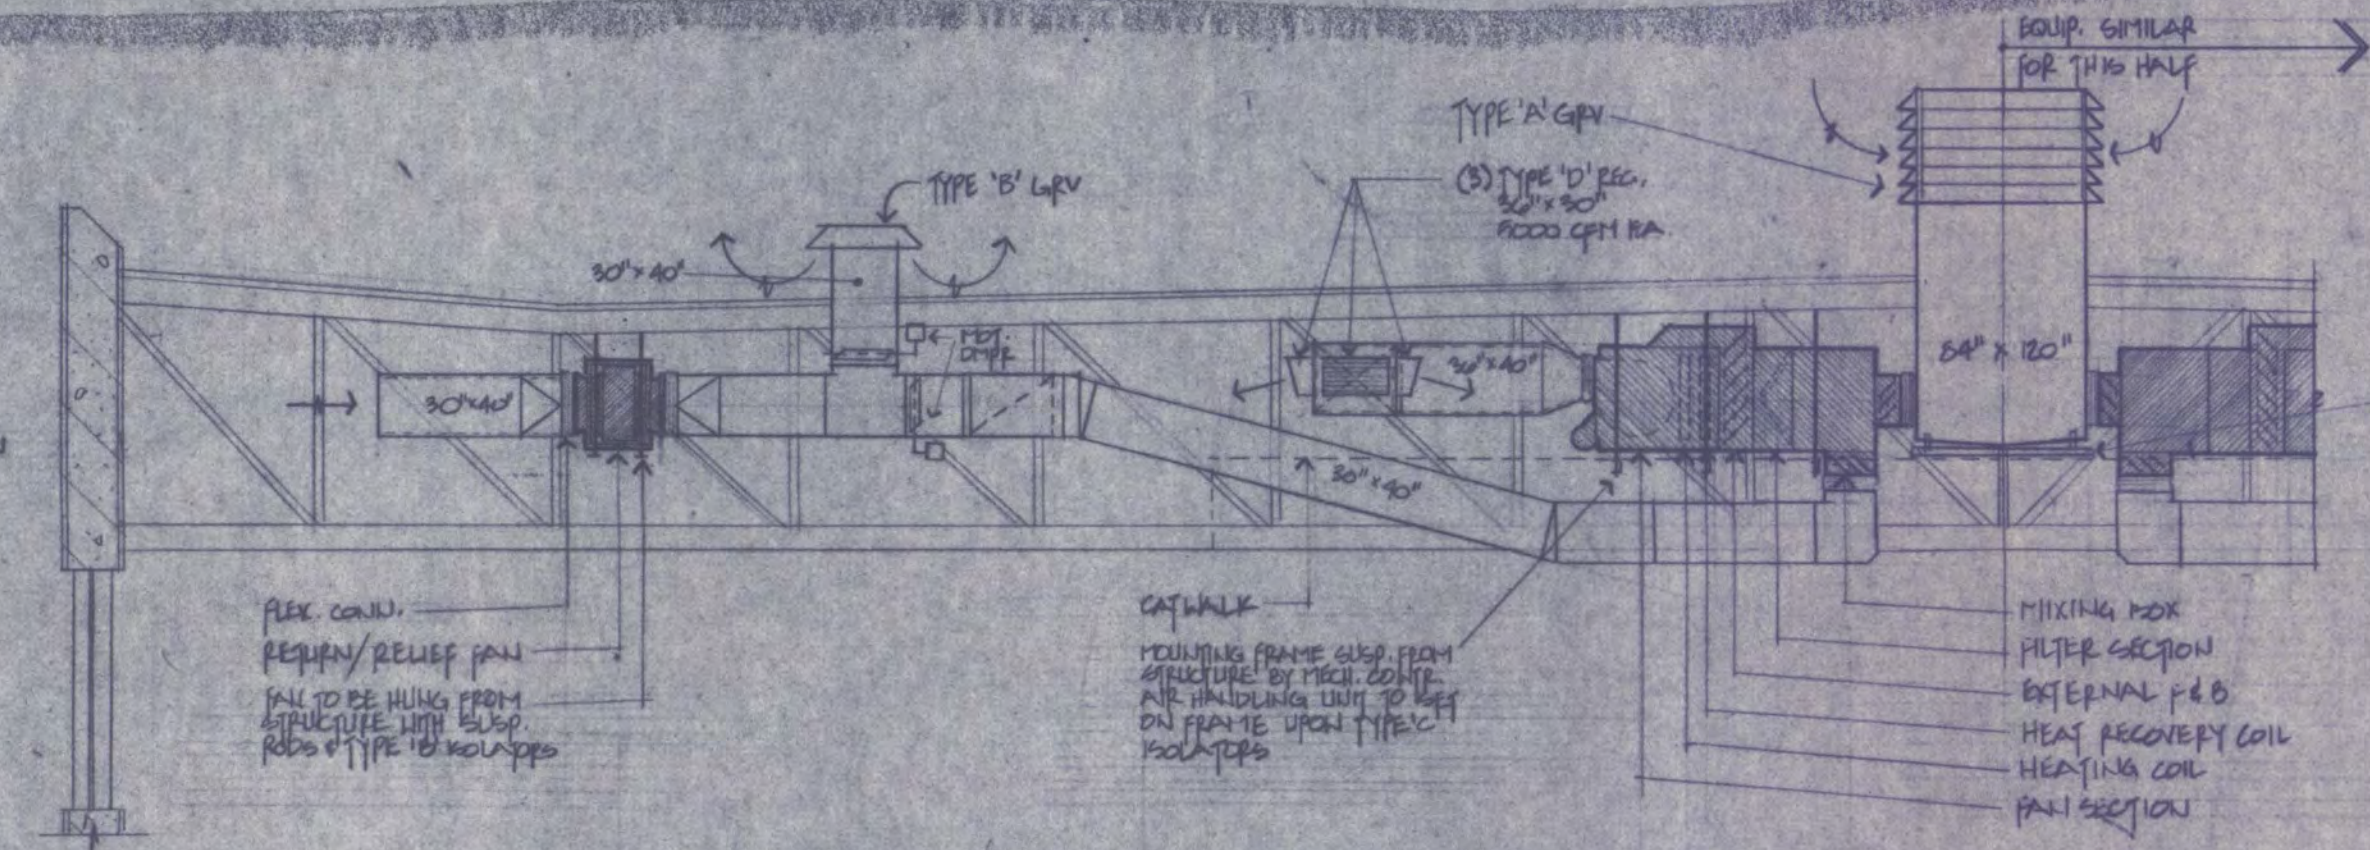


6 ACTIVITY CENTER UNITS-ELEVATION
SCALE: 1/8" = 1'-0"

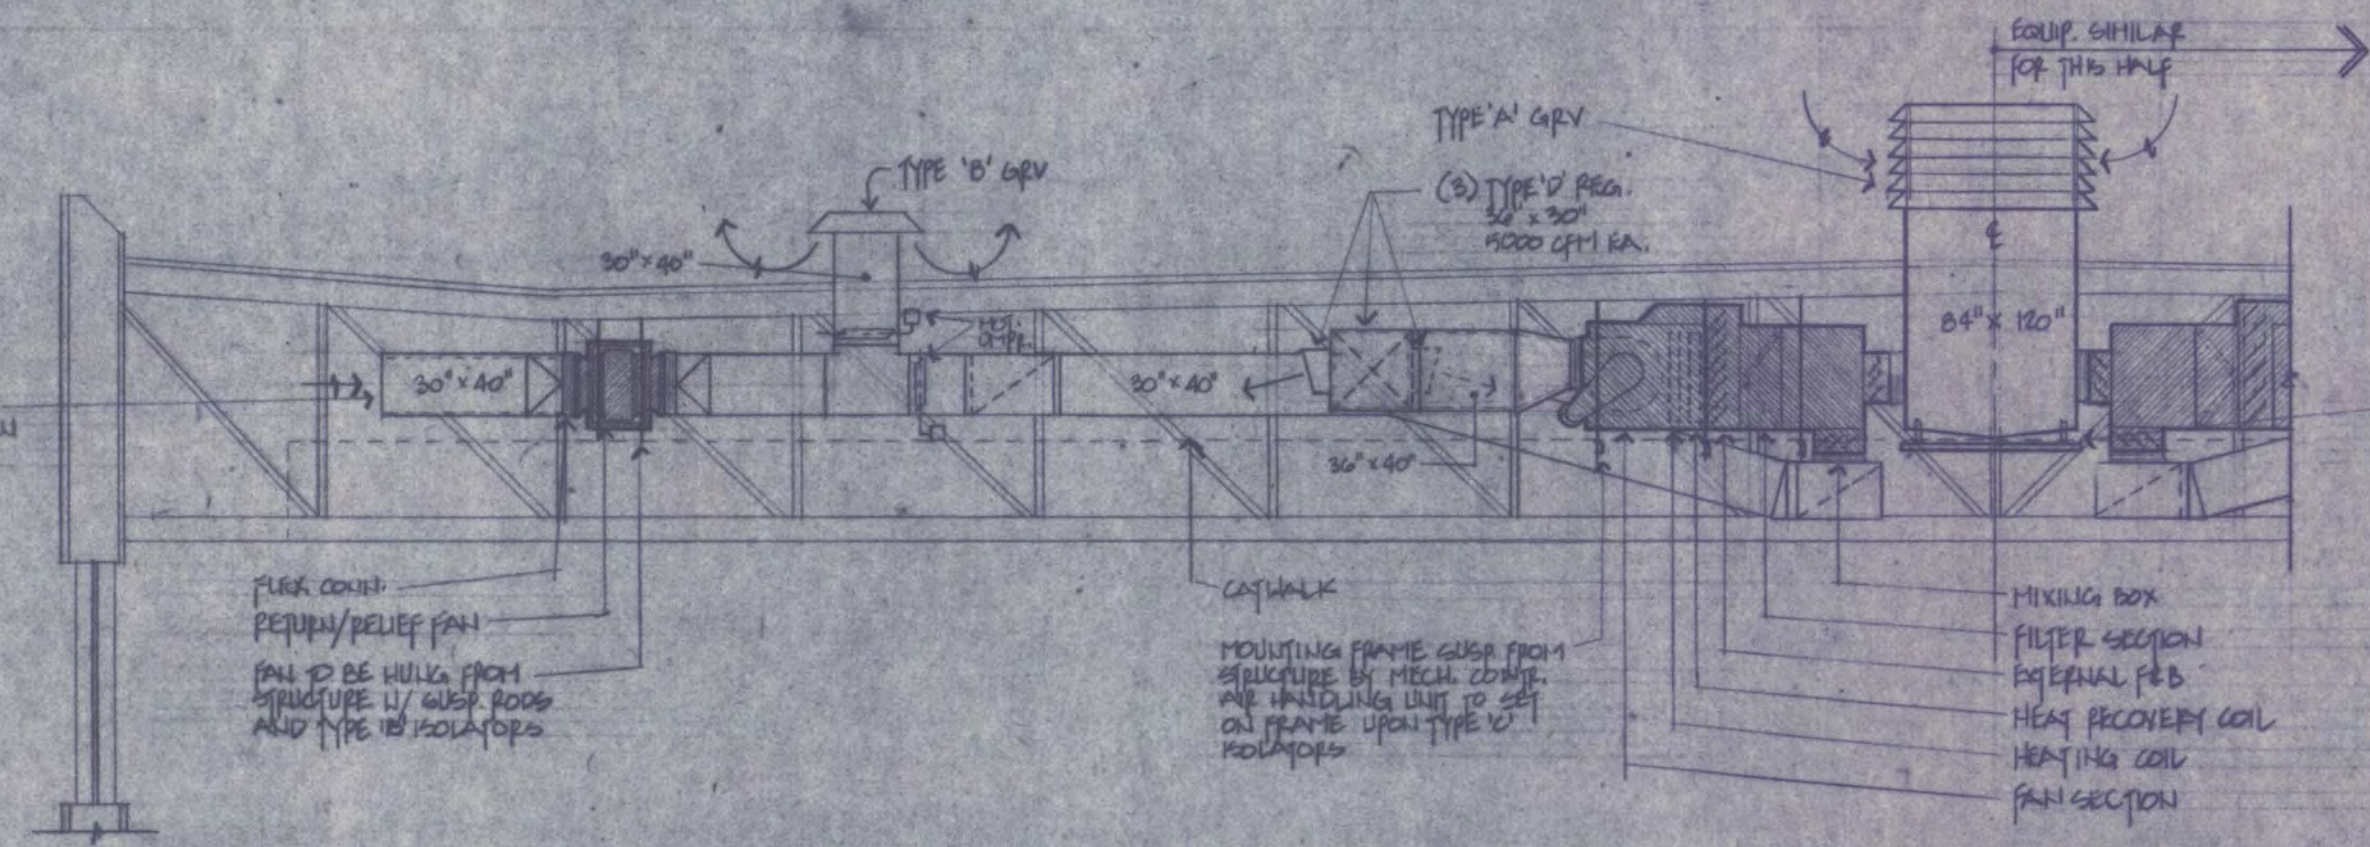

7 ACTIVITY CENTER UNITS-ELEVATION
SCALE: 1/8" = 1'-0"

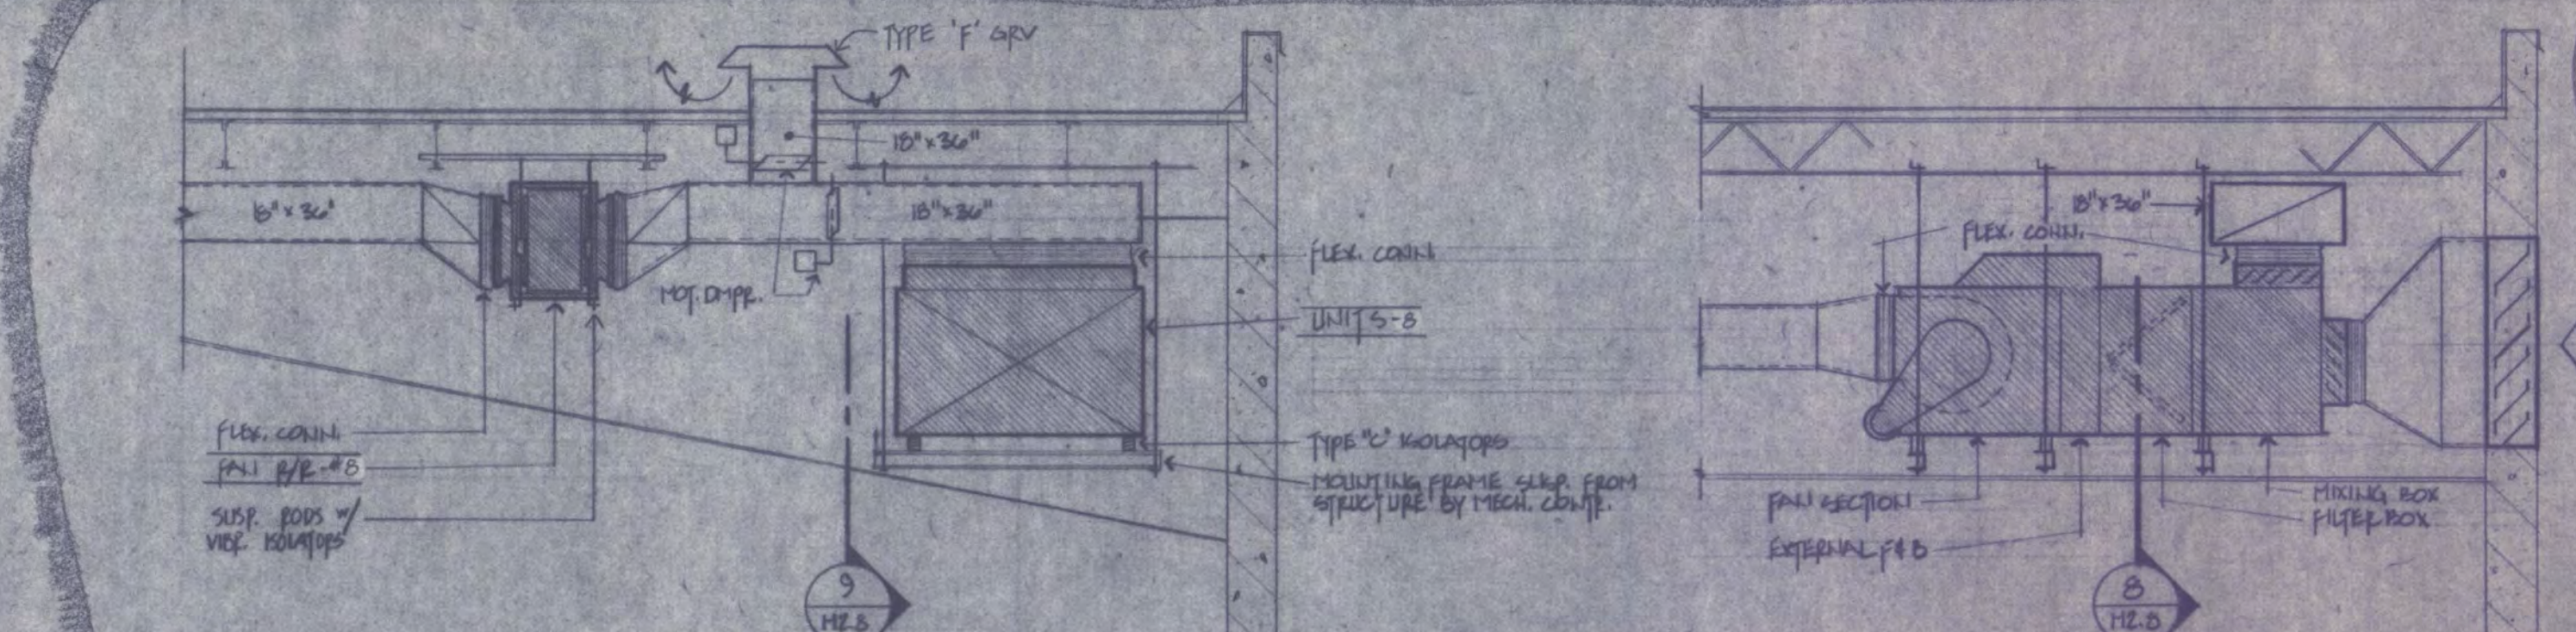

8 WRESTLING ROOM UNIT-SECTION
SCALE: 1/8" = 1'-0"

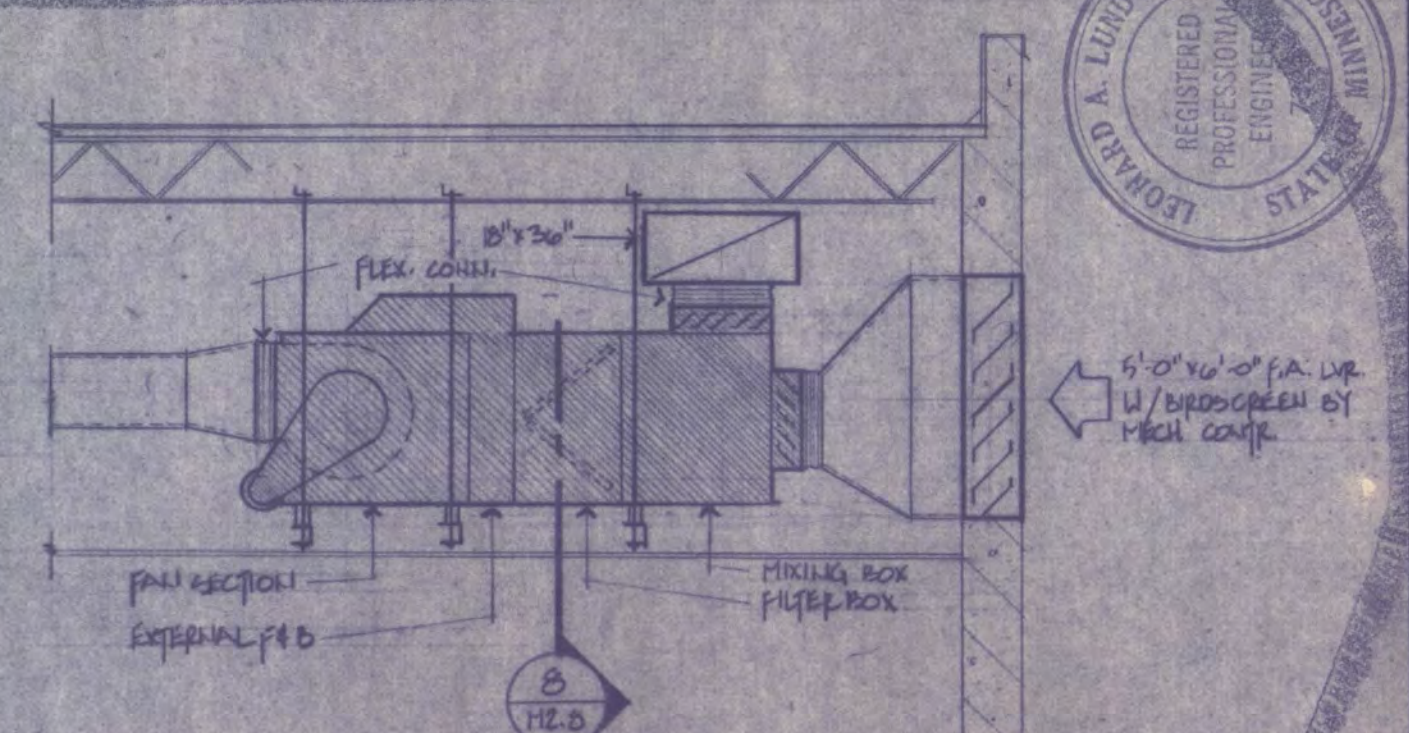

9 WRESTLING ROOM UNIT-ELEVATION
SCALE: 1/4" = 1'-0"

PHASE TWO work indicated thus. All other information is Phase One, under construction, and is for reference only. Coordinate all PHASE TWO activity with Donlar Corp., Phase One General Contractor.

