
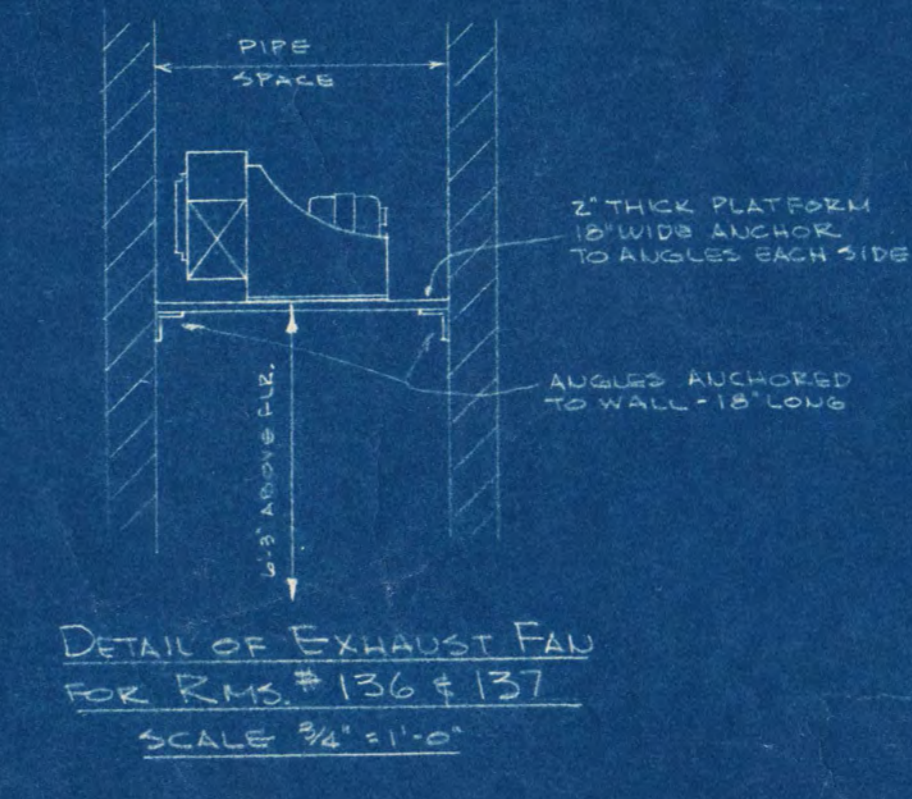
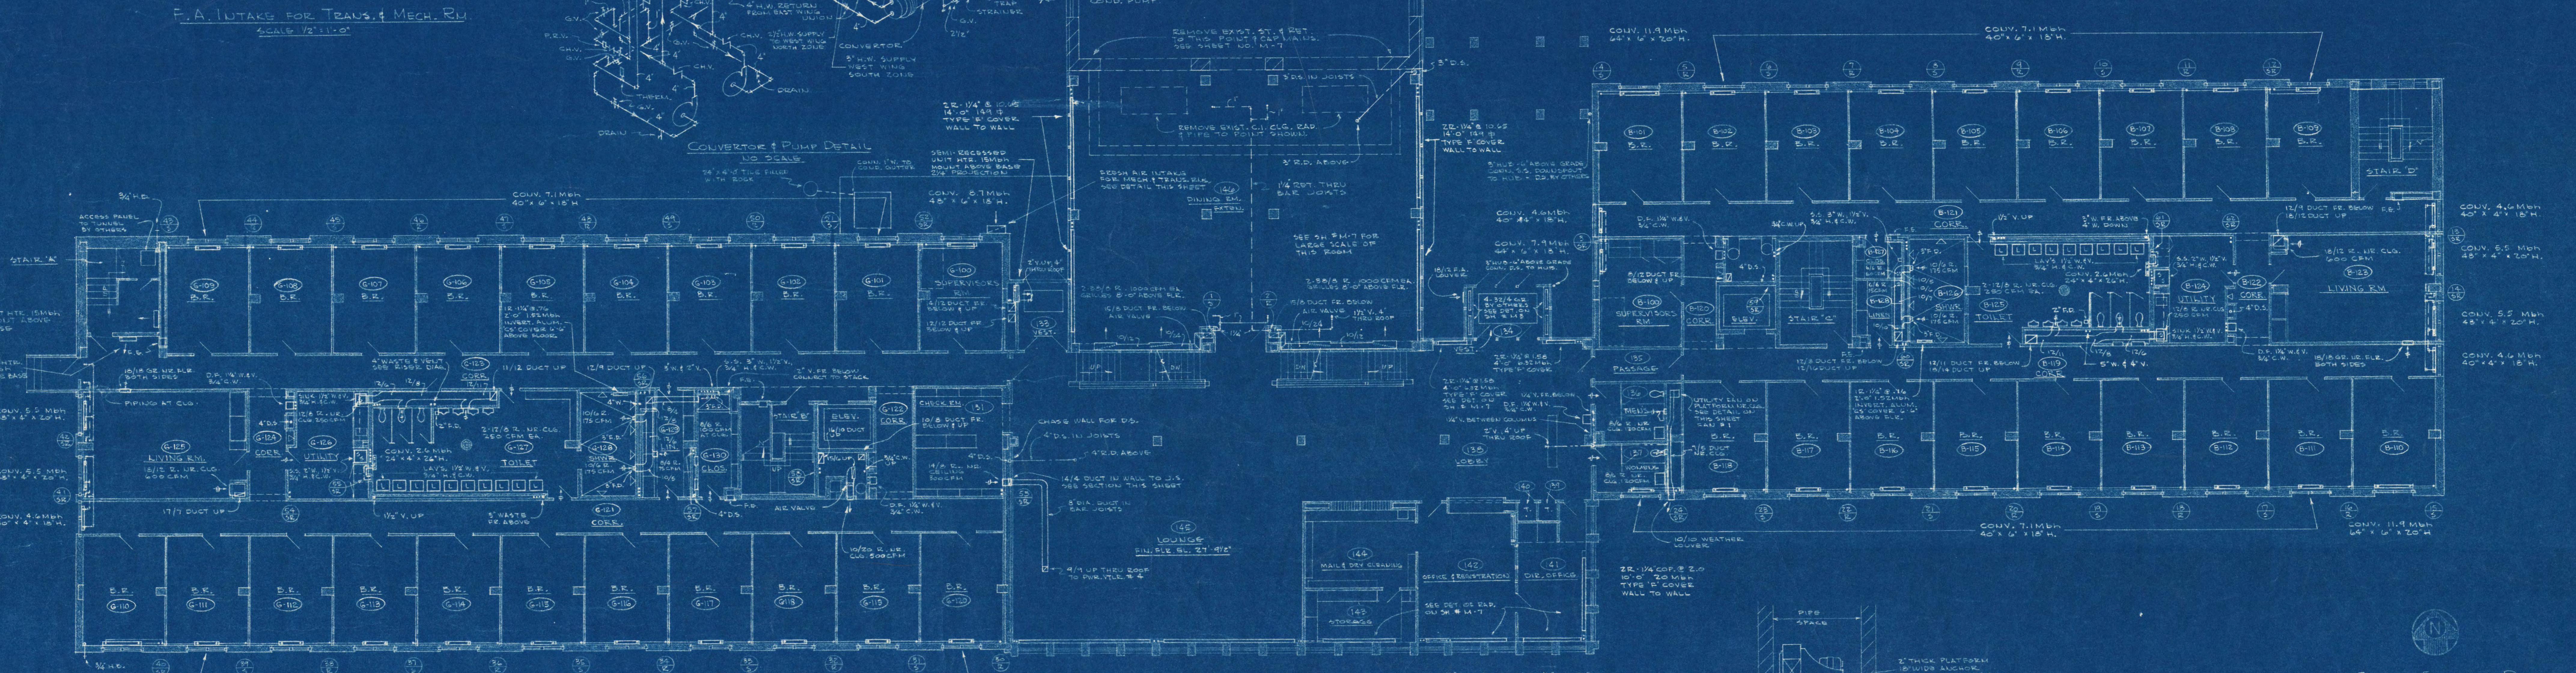
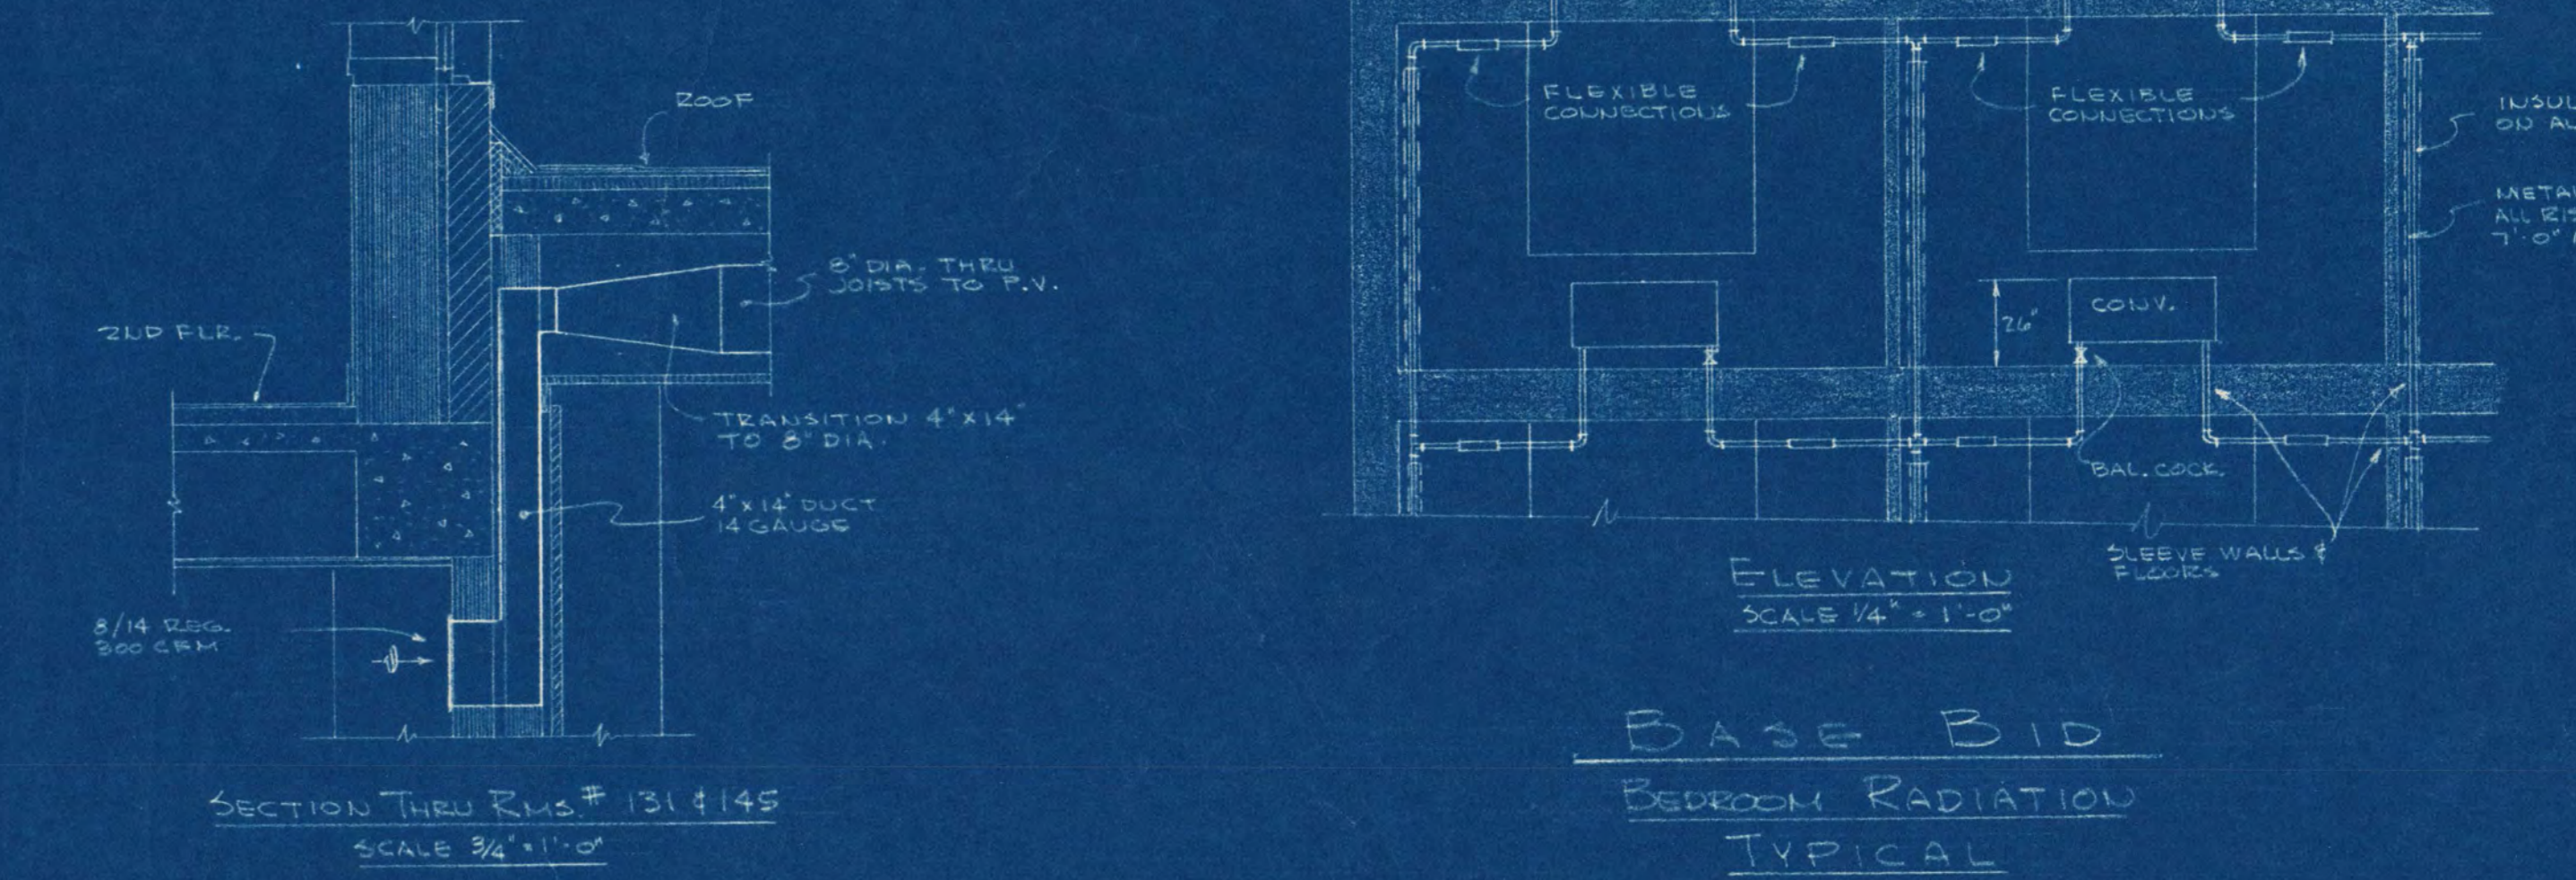
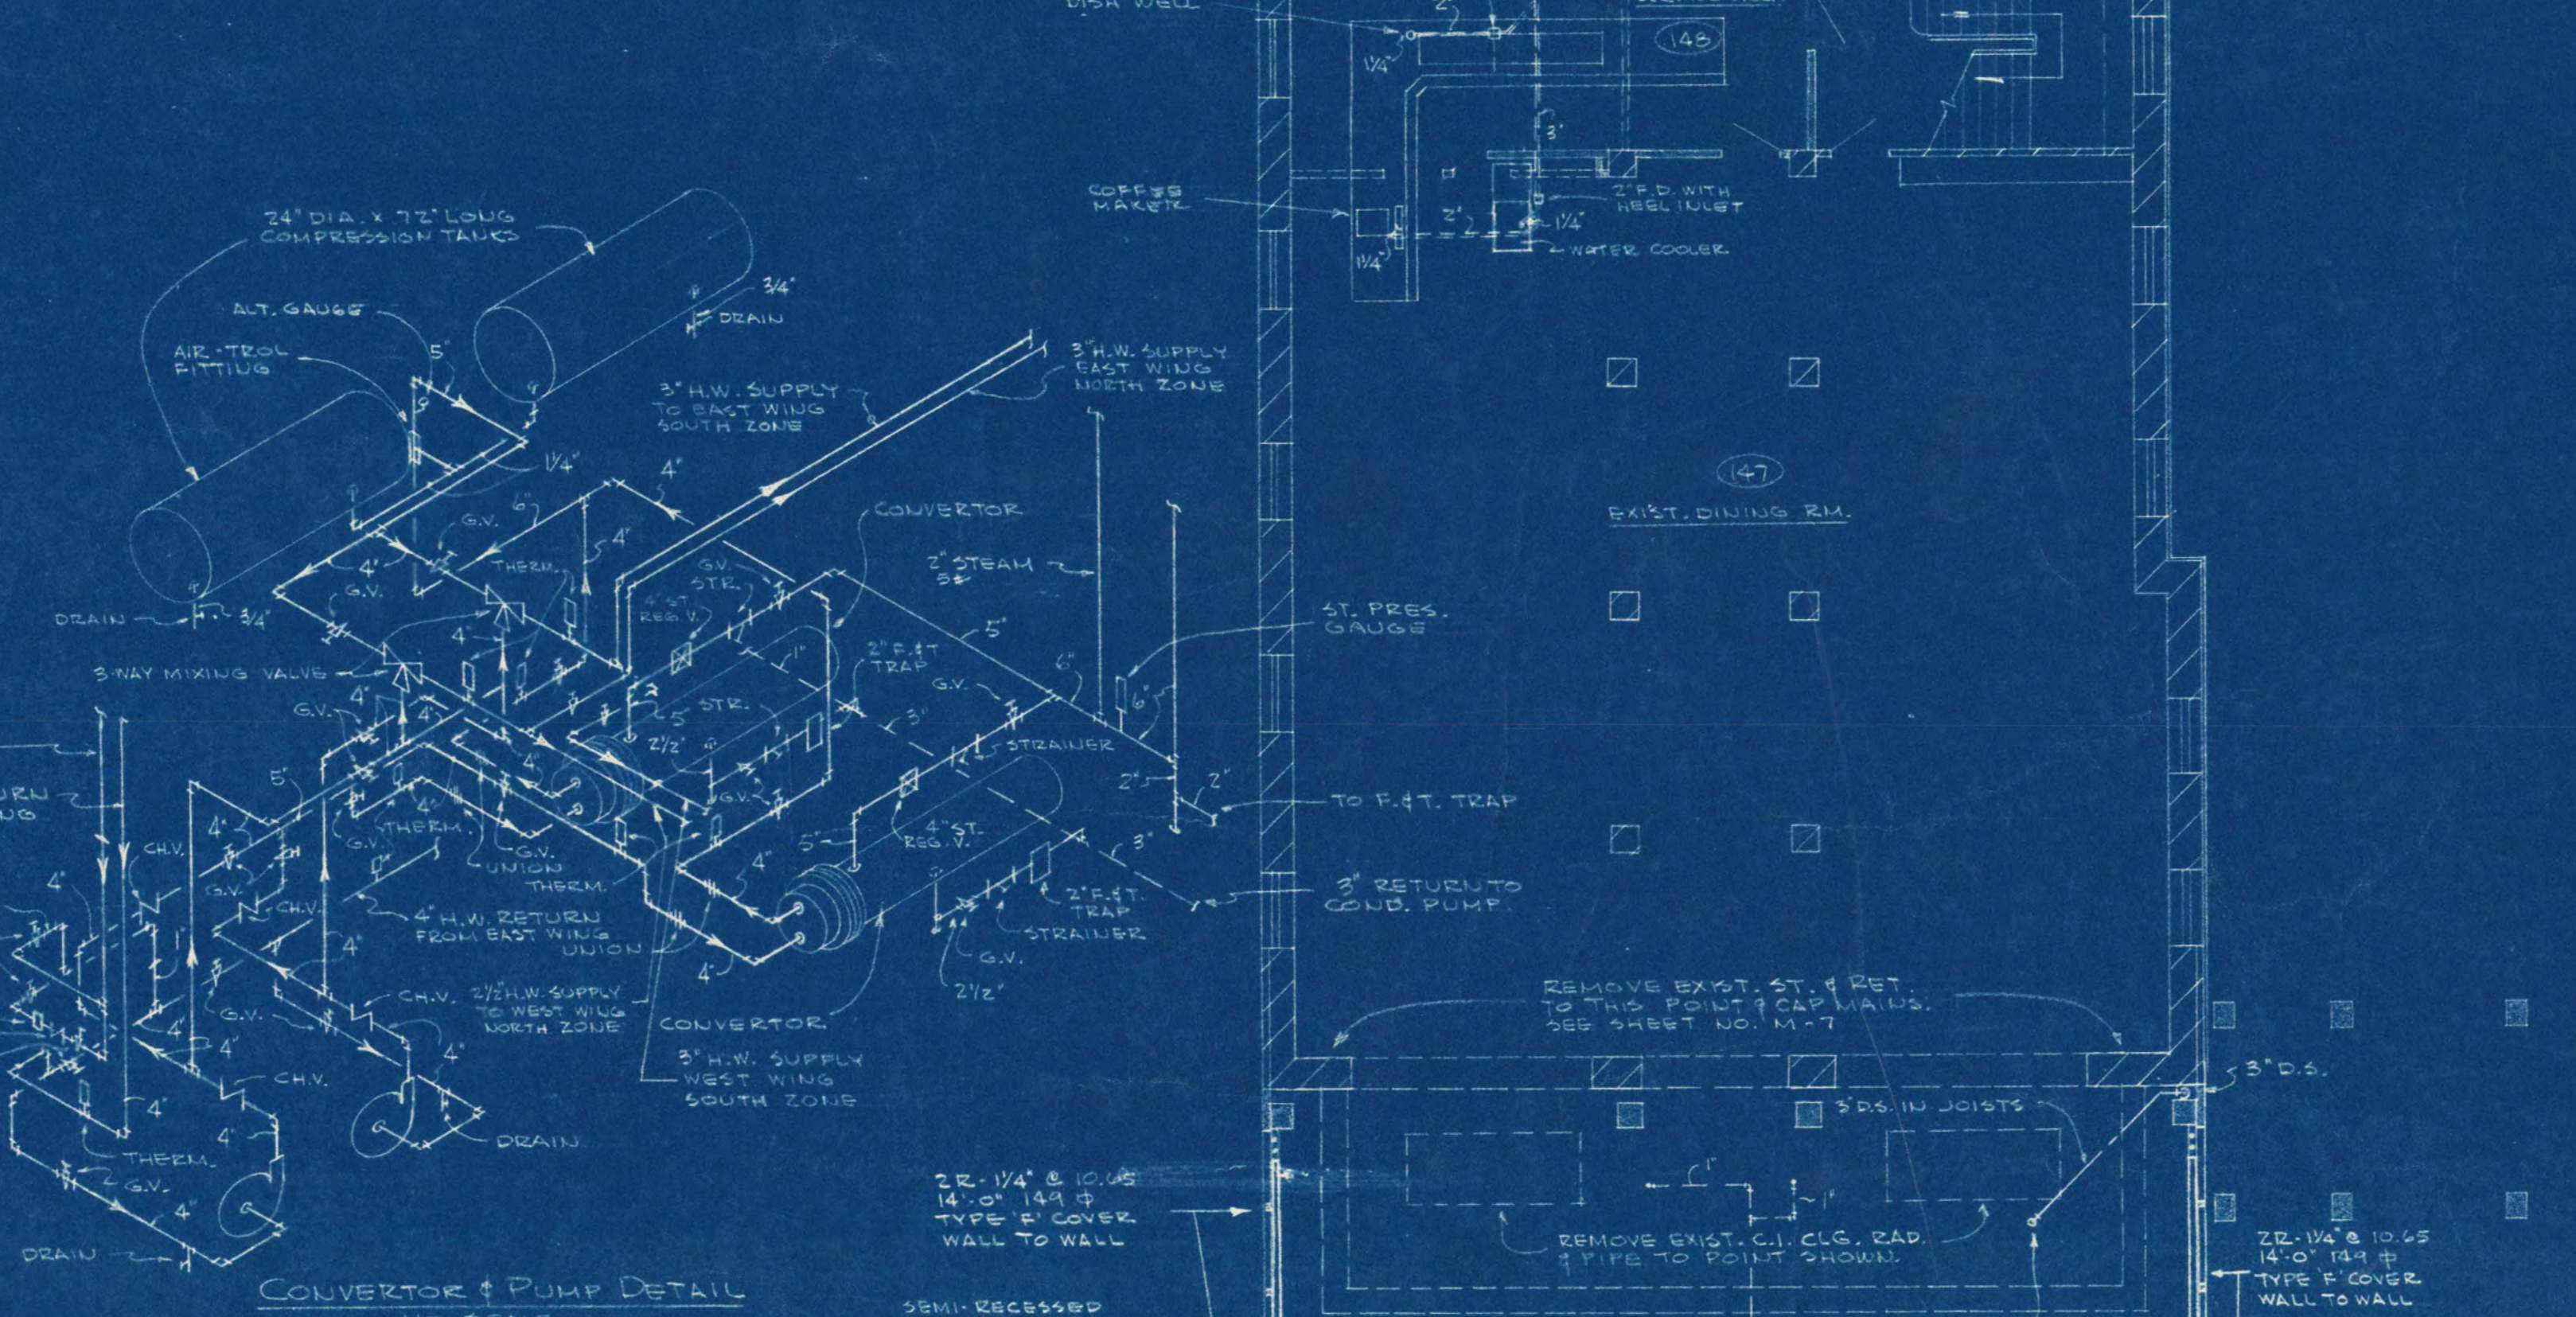


MECHANICAL EQUIPMENT ROOM

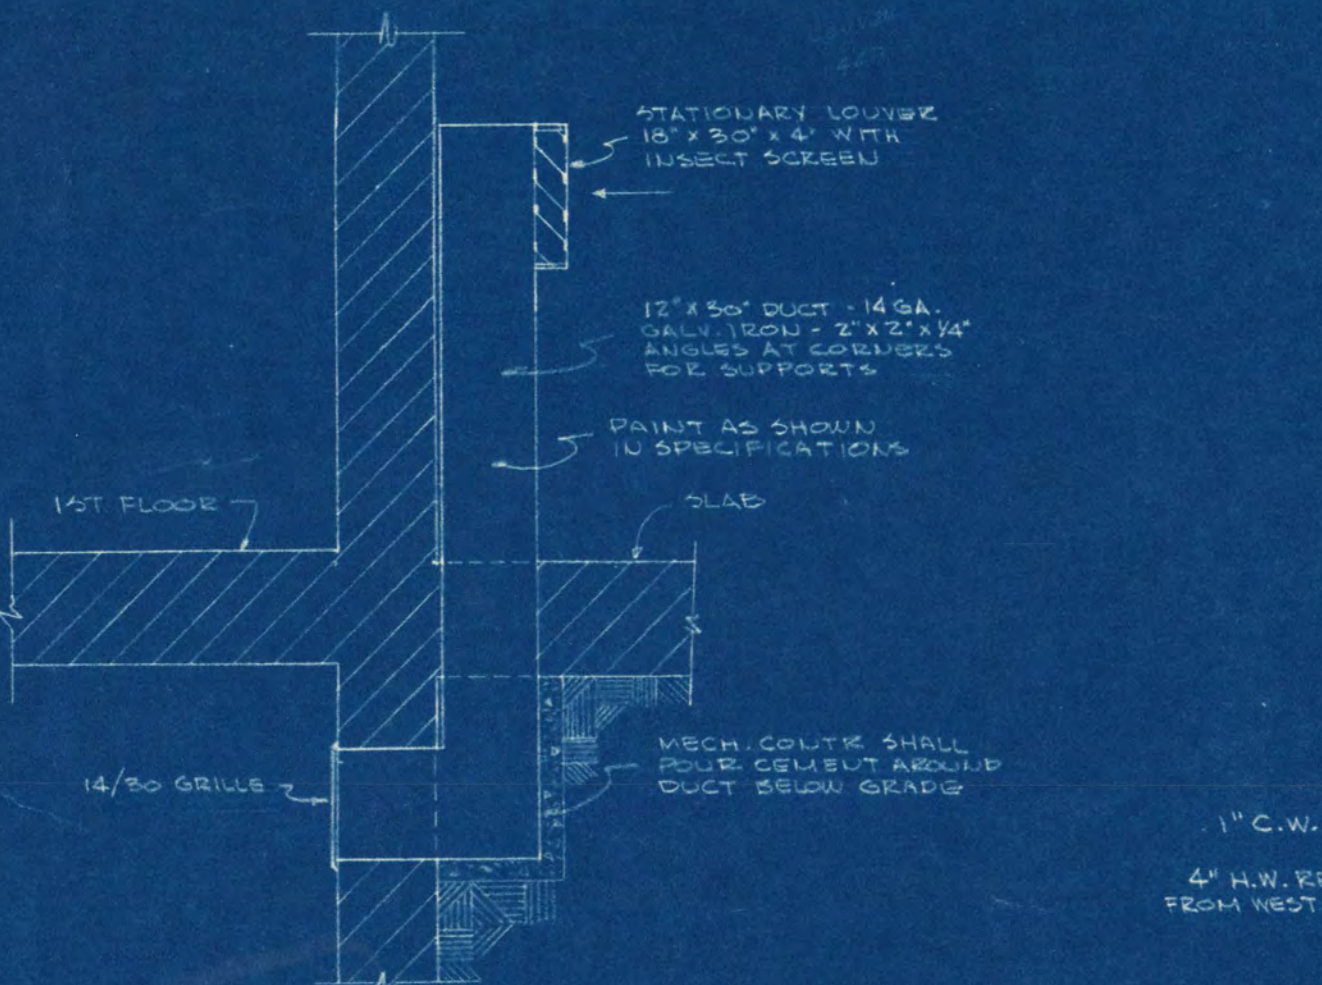

FIRST FLOOR PLAN
SCALE 1/8" = 1'-0"

DETAILS & SECTIONS
SCALE AS SHOWN

ADDITION TO SHOEMAKER HALL
ST. CLOUD STATE COLLEGE
ST. CLOUD, MINNESOTA

DATE: 10-24-54
DESIGNED BY: FRANK W. JOHNSON & ASSOCIATES, INC.
ENGINEERS & ARCHITECTS
ST. CLOUD, MINNESOTA

DRAWN BY: ORR-SCHULEN, INC.
CONSULTING ENGINEERS
MINNEAPOLIS, MINNESOTA


DATE: 3-2-55

APPROVED BY: [Signature]


PREPARED BY: [Signature]

APPENDED BY: [Signature]

ST. CLOUD
B-1-B

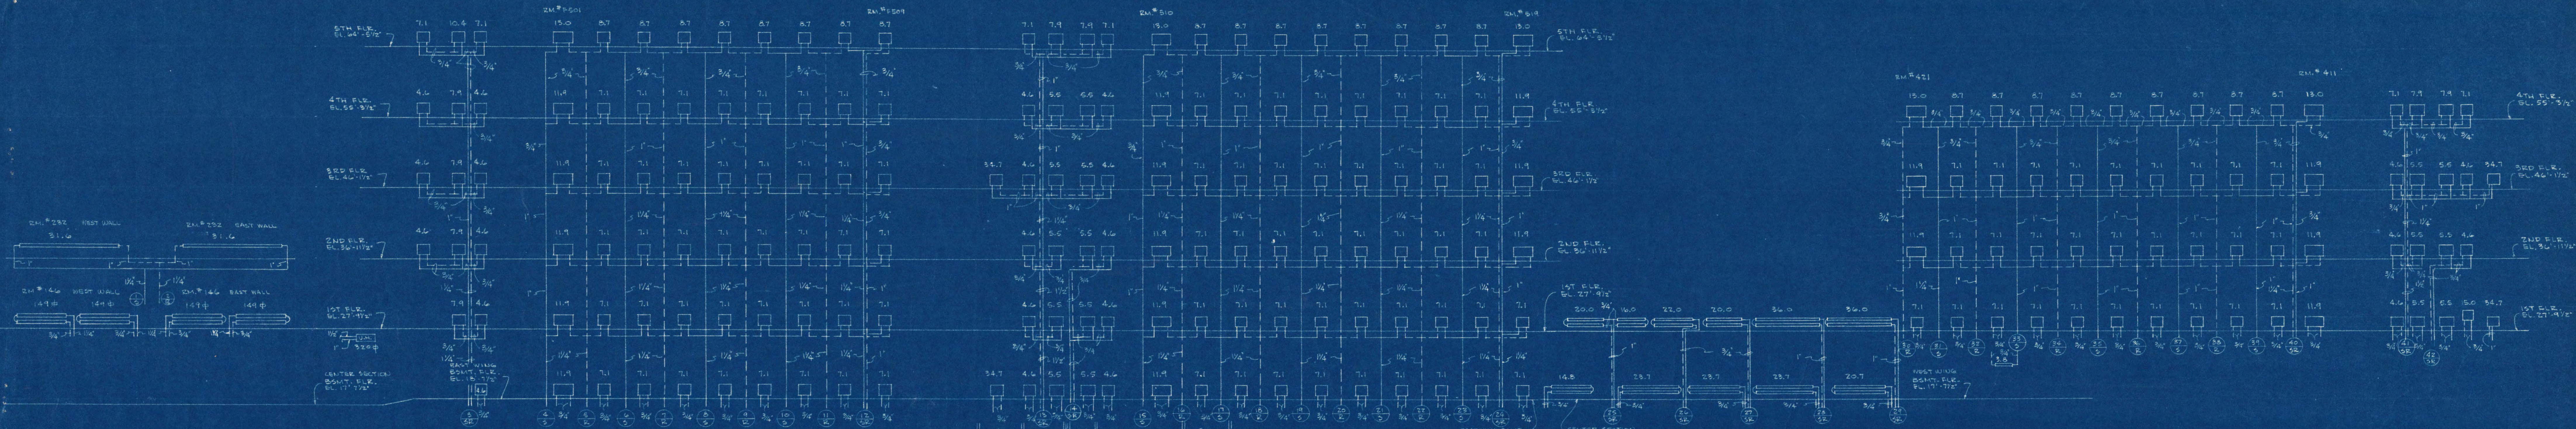

HEATING RISER DIAGRAM
NO SCALE

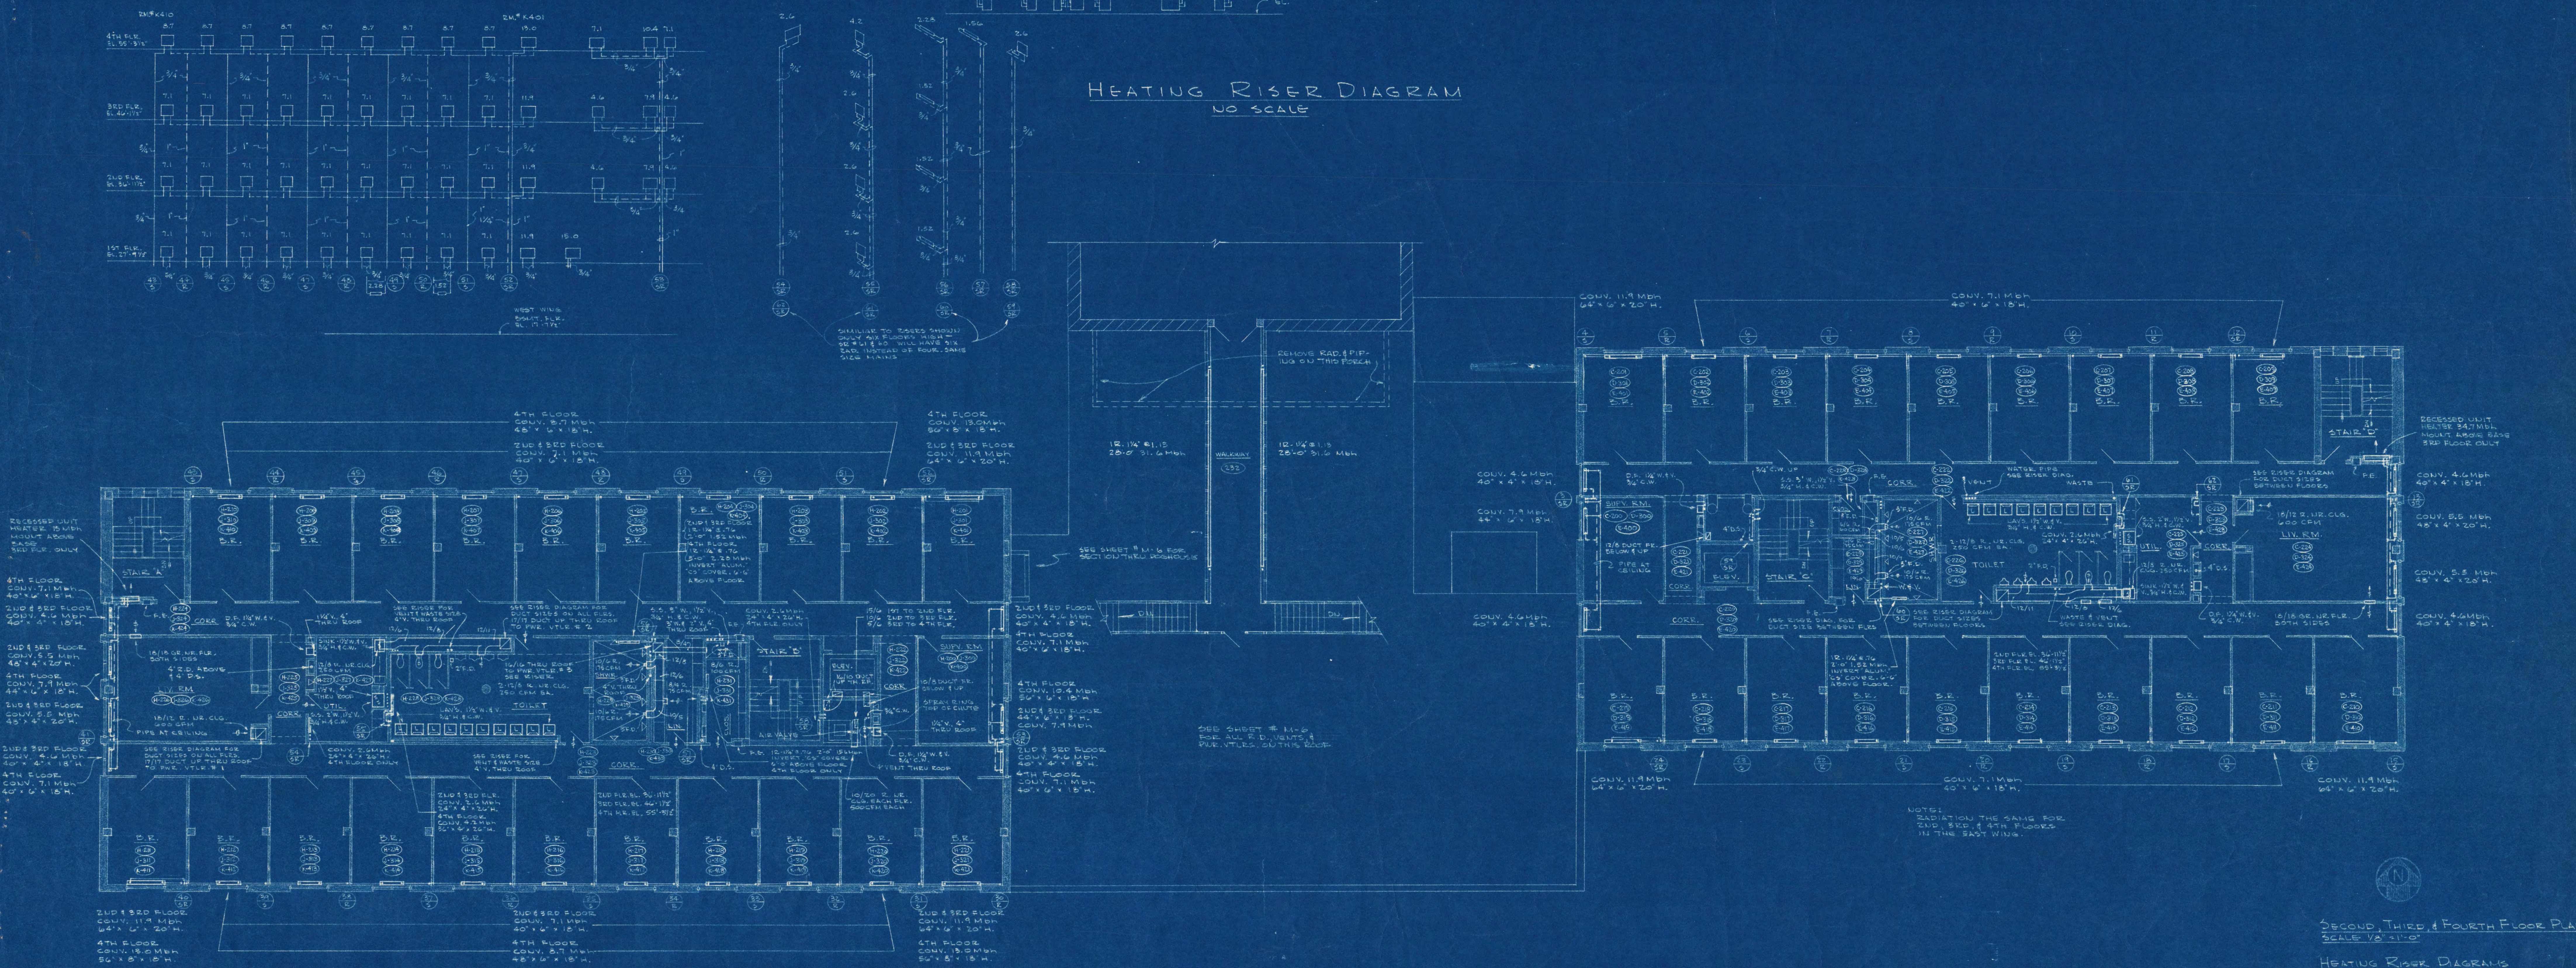

SECOND, THIRD & FOURTH FLOOR PLANS
SCALE 1/8" = 1'-0"

SECOND, THIRD & FOURTH FLOOR PLANS
SCALE 1/8" = 1'-0"

HEATING RISER DIAGRAM
SCALE - NONE

ADDITION TO SHOEMAKER HALL
ST. CLOUD STATE COLLEGE
ST. CLOUD, MINNESOTA

DATE: 3-2-24

BY: FRANK W. JACOBSON & ASSOCIATES, INC.
ST. CLOUD, MINNESOTA

BY: ORR - SCHELEN, INC.
CONSULTING ENGINEERS
MINNEAPOLIS, MINNESOTA



APPROVED BY: _____

APPROVED BY: _____

APPROVED BY: _____


SCALE: 1/8" = 1'-0"

SCALE: NONE

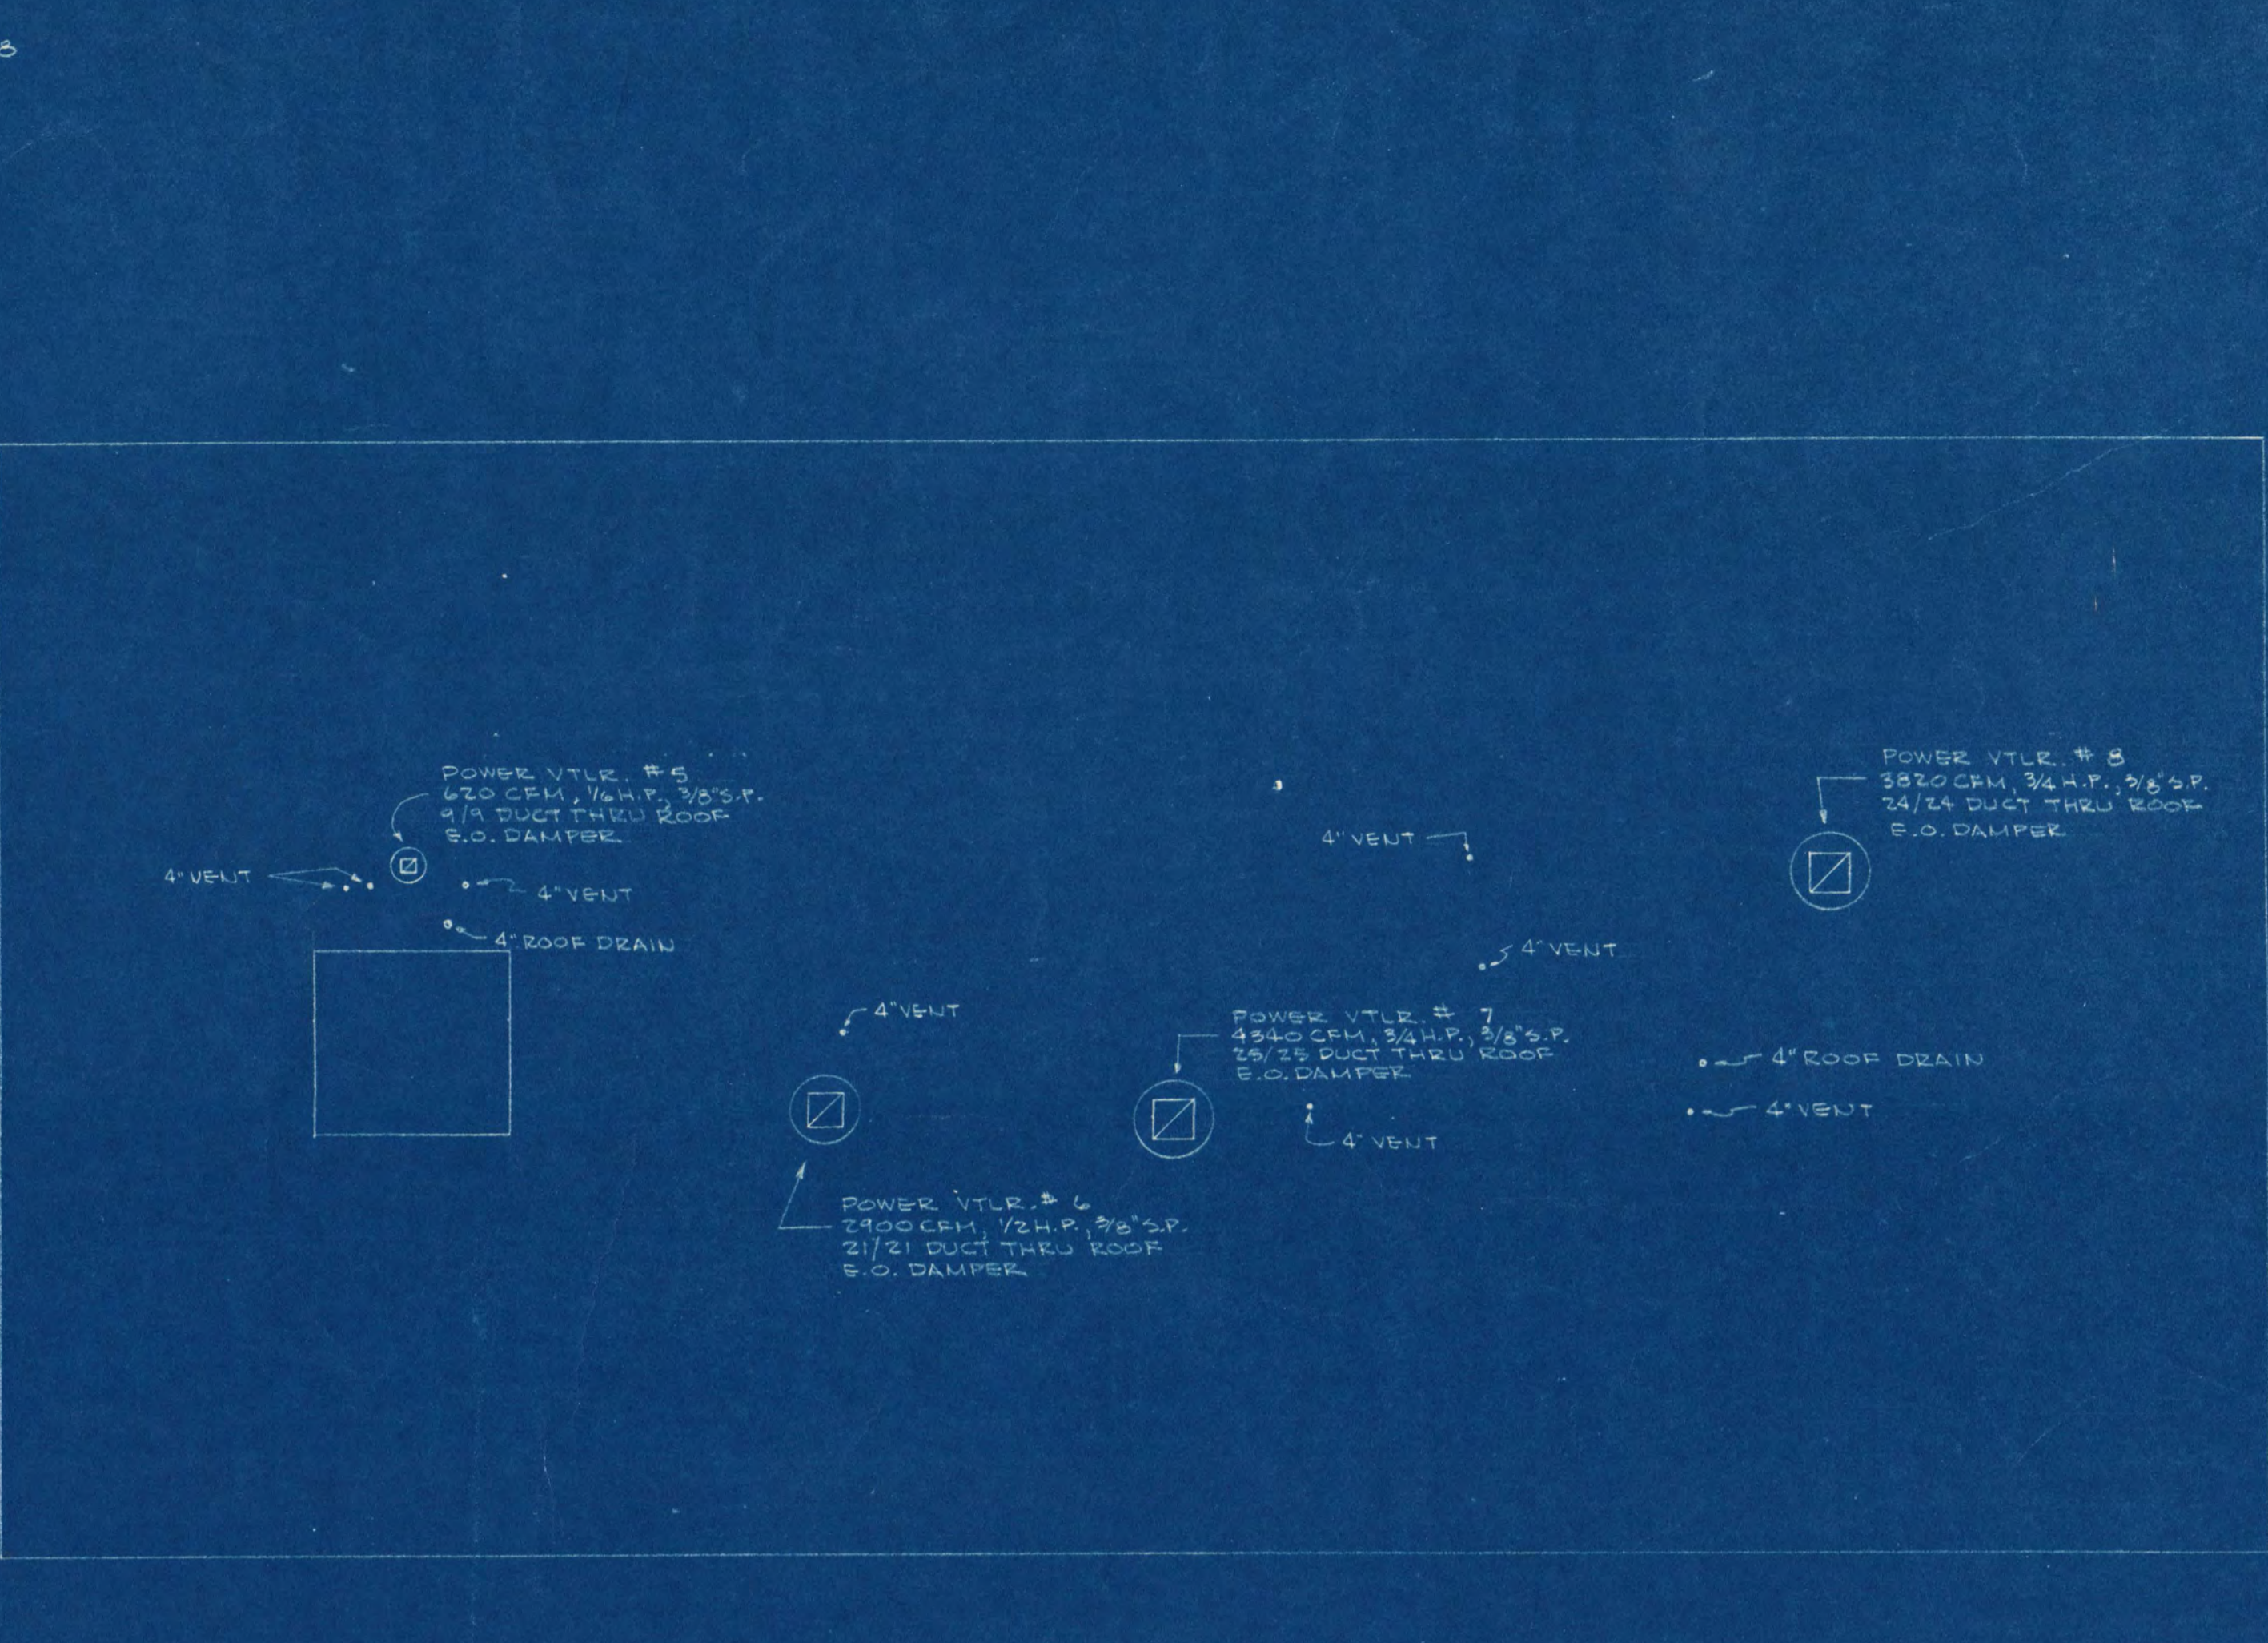
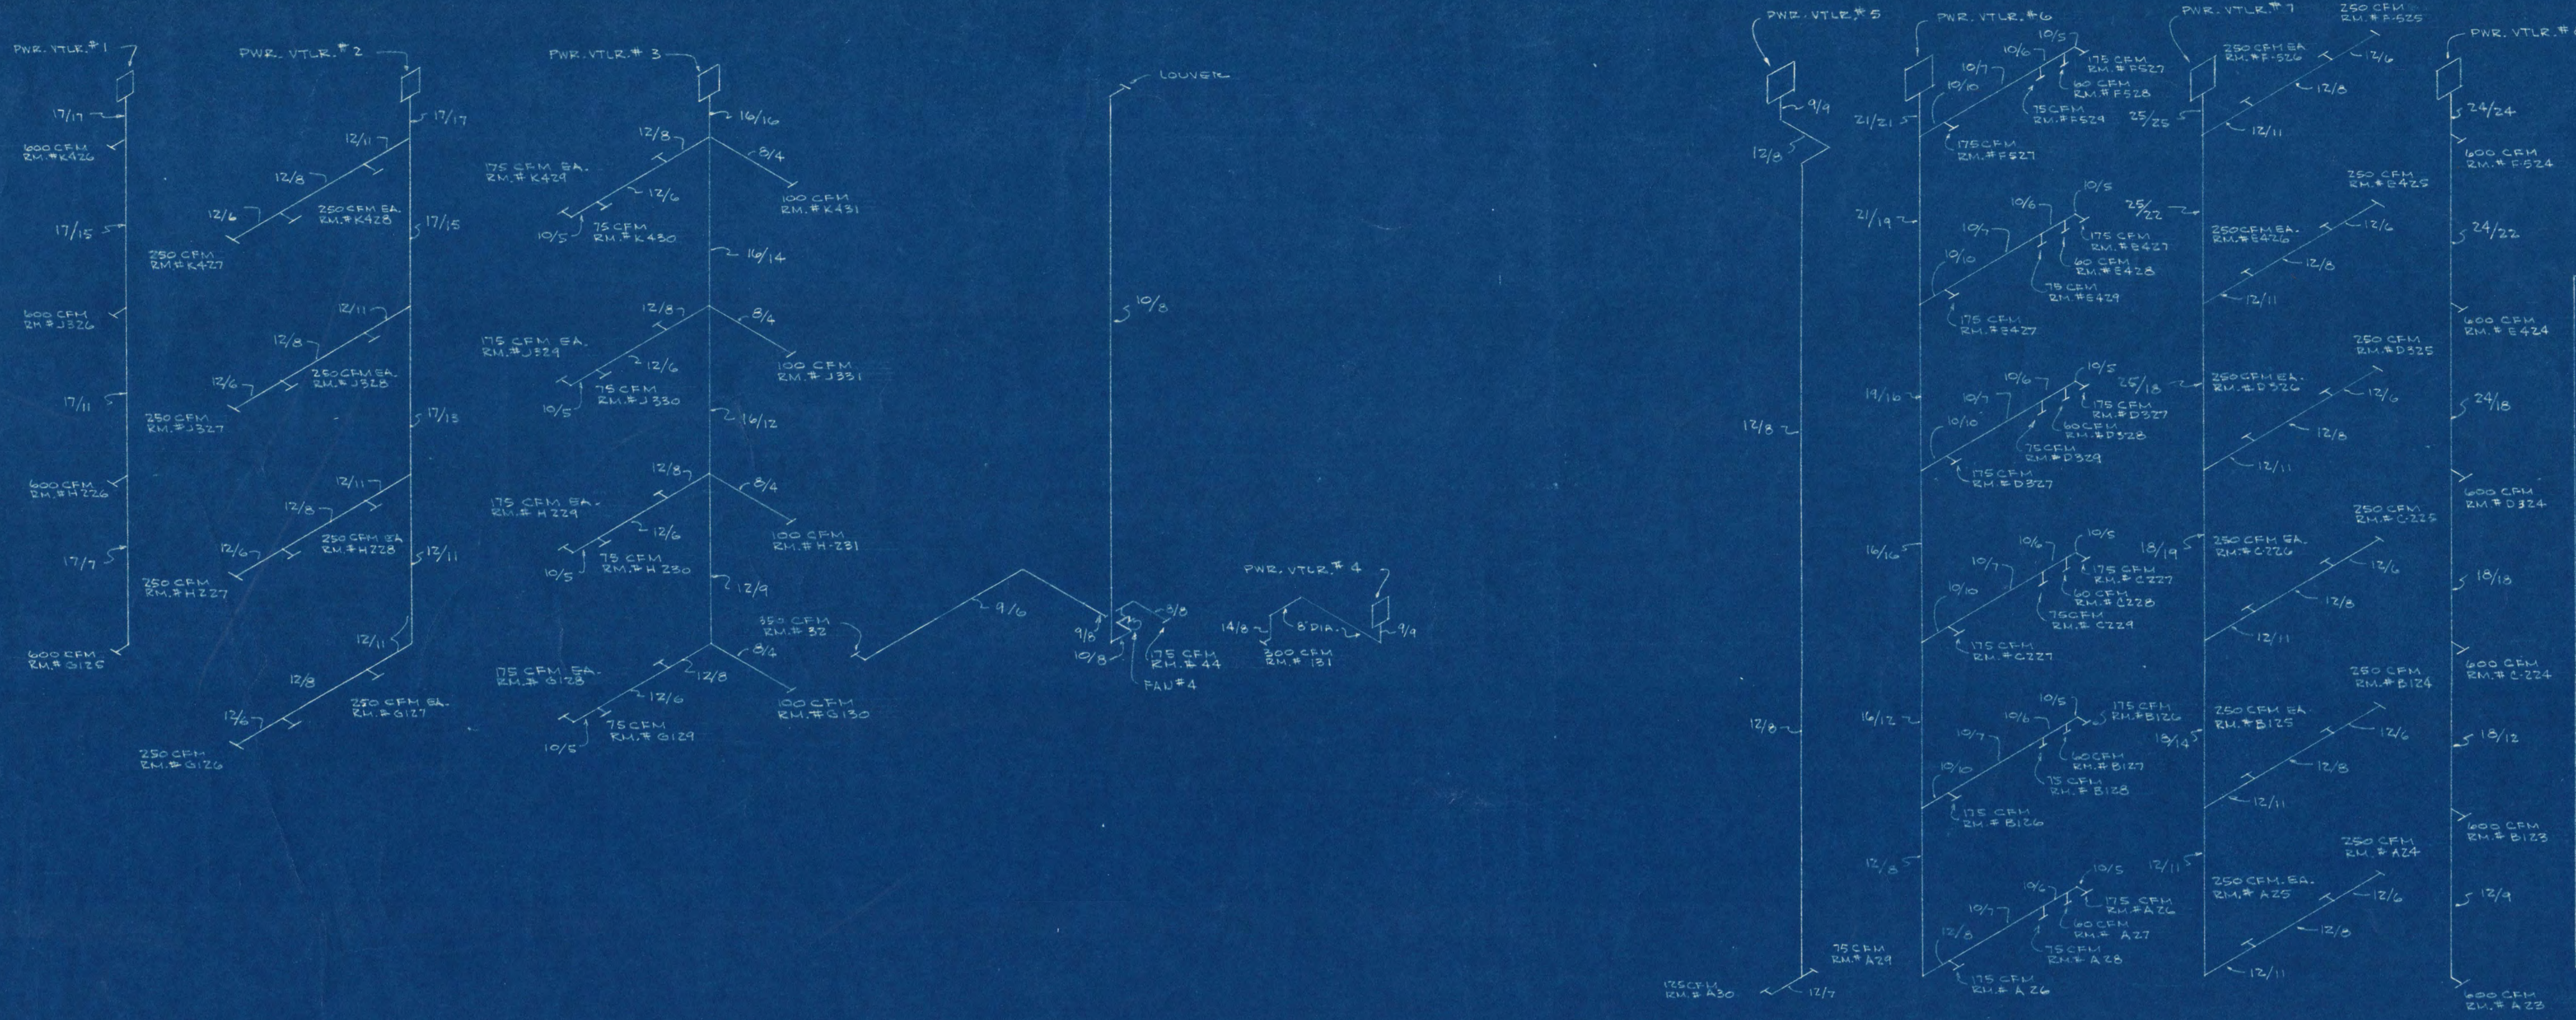


EXHAUST RISER DIAGRAMS
NO SCALE

ROOF PLAN
SCALE 1/8" = 1'-0"

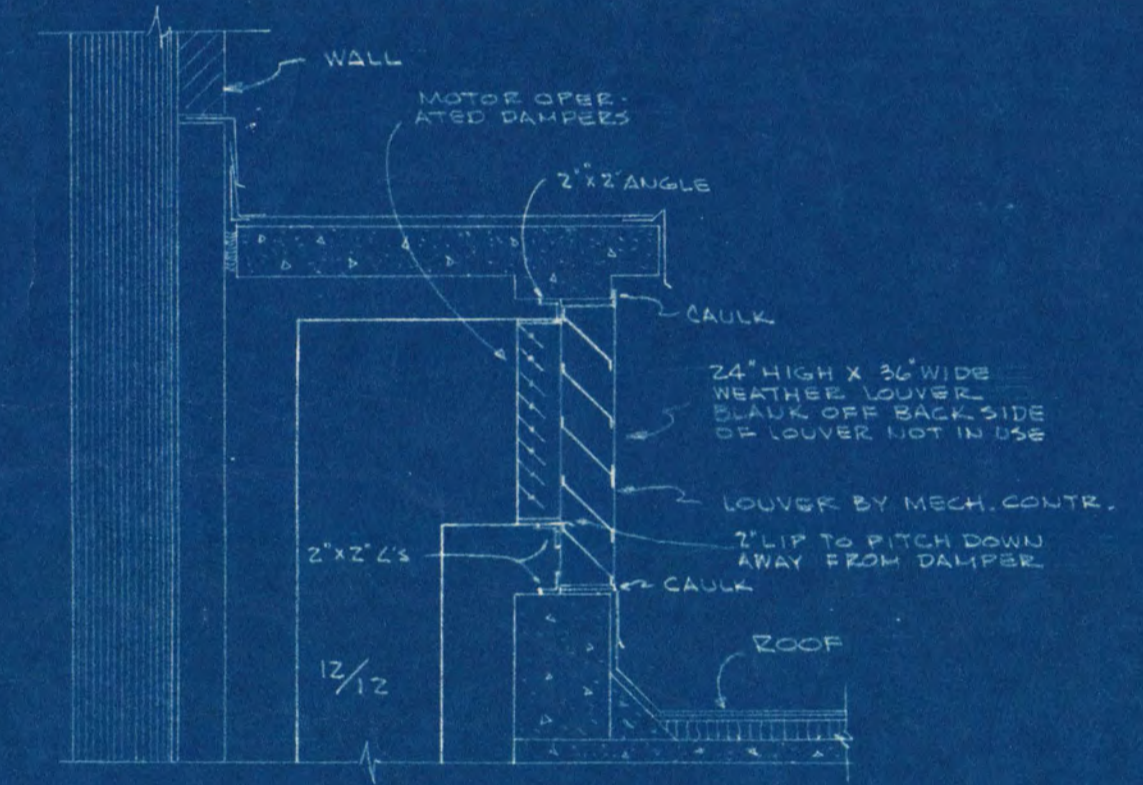

SECTION THROUGH DOGHOUSE
SCALE 3/8" = 1'-0"

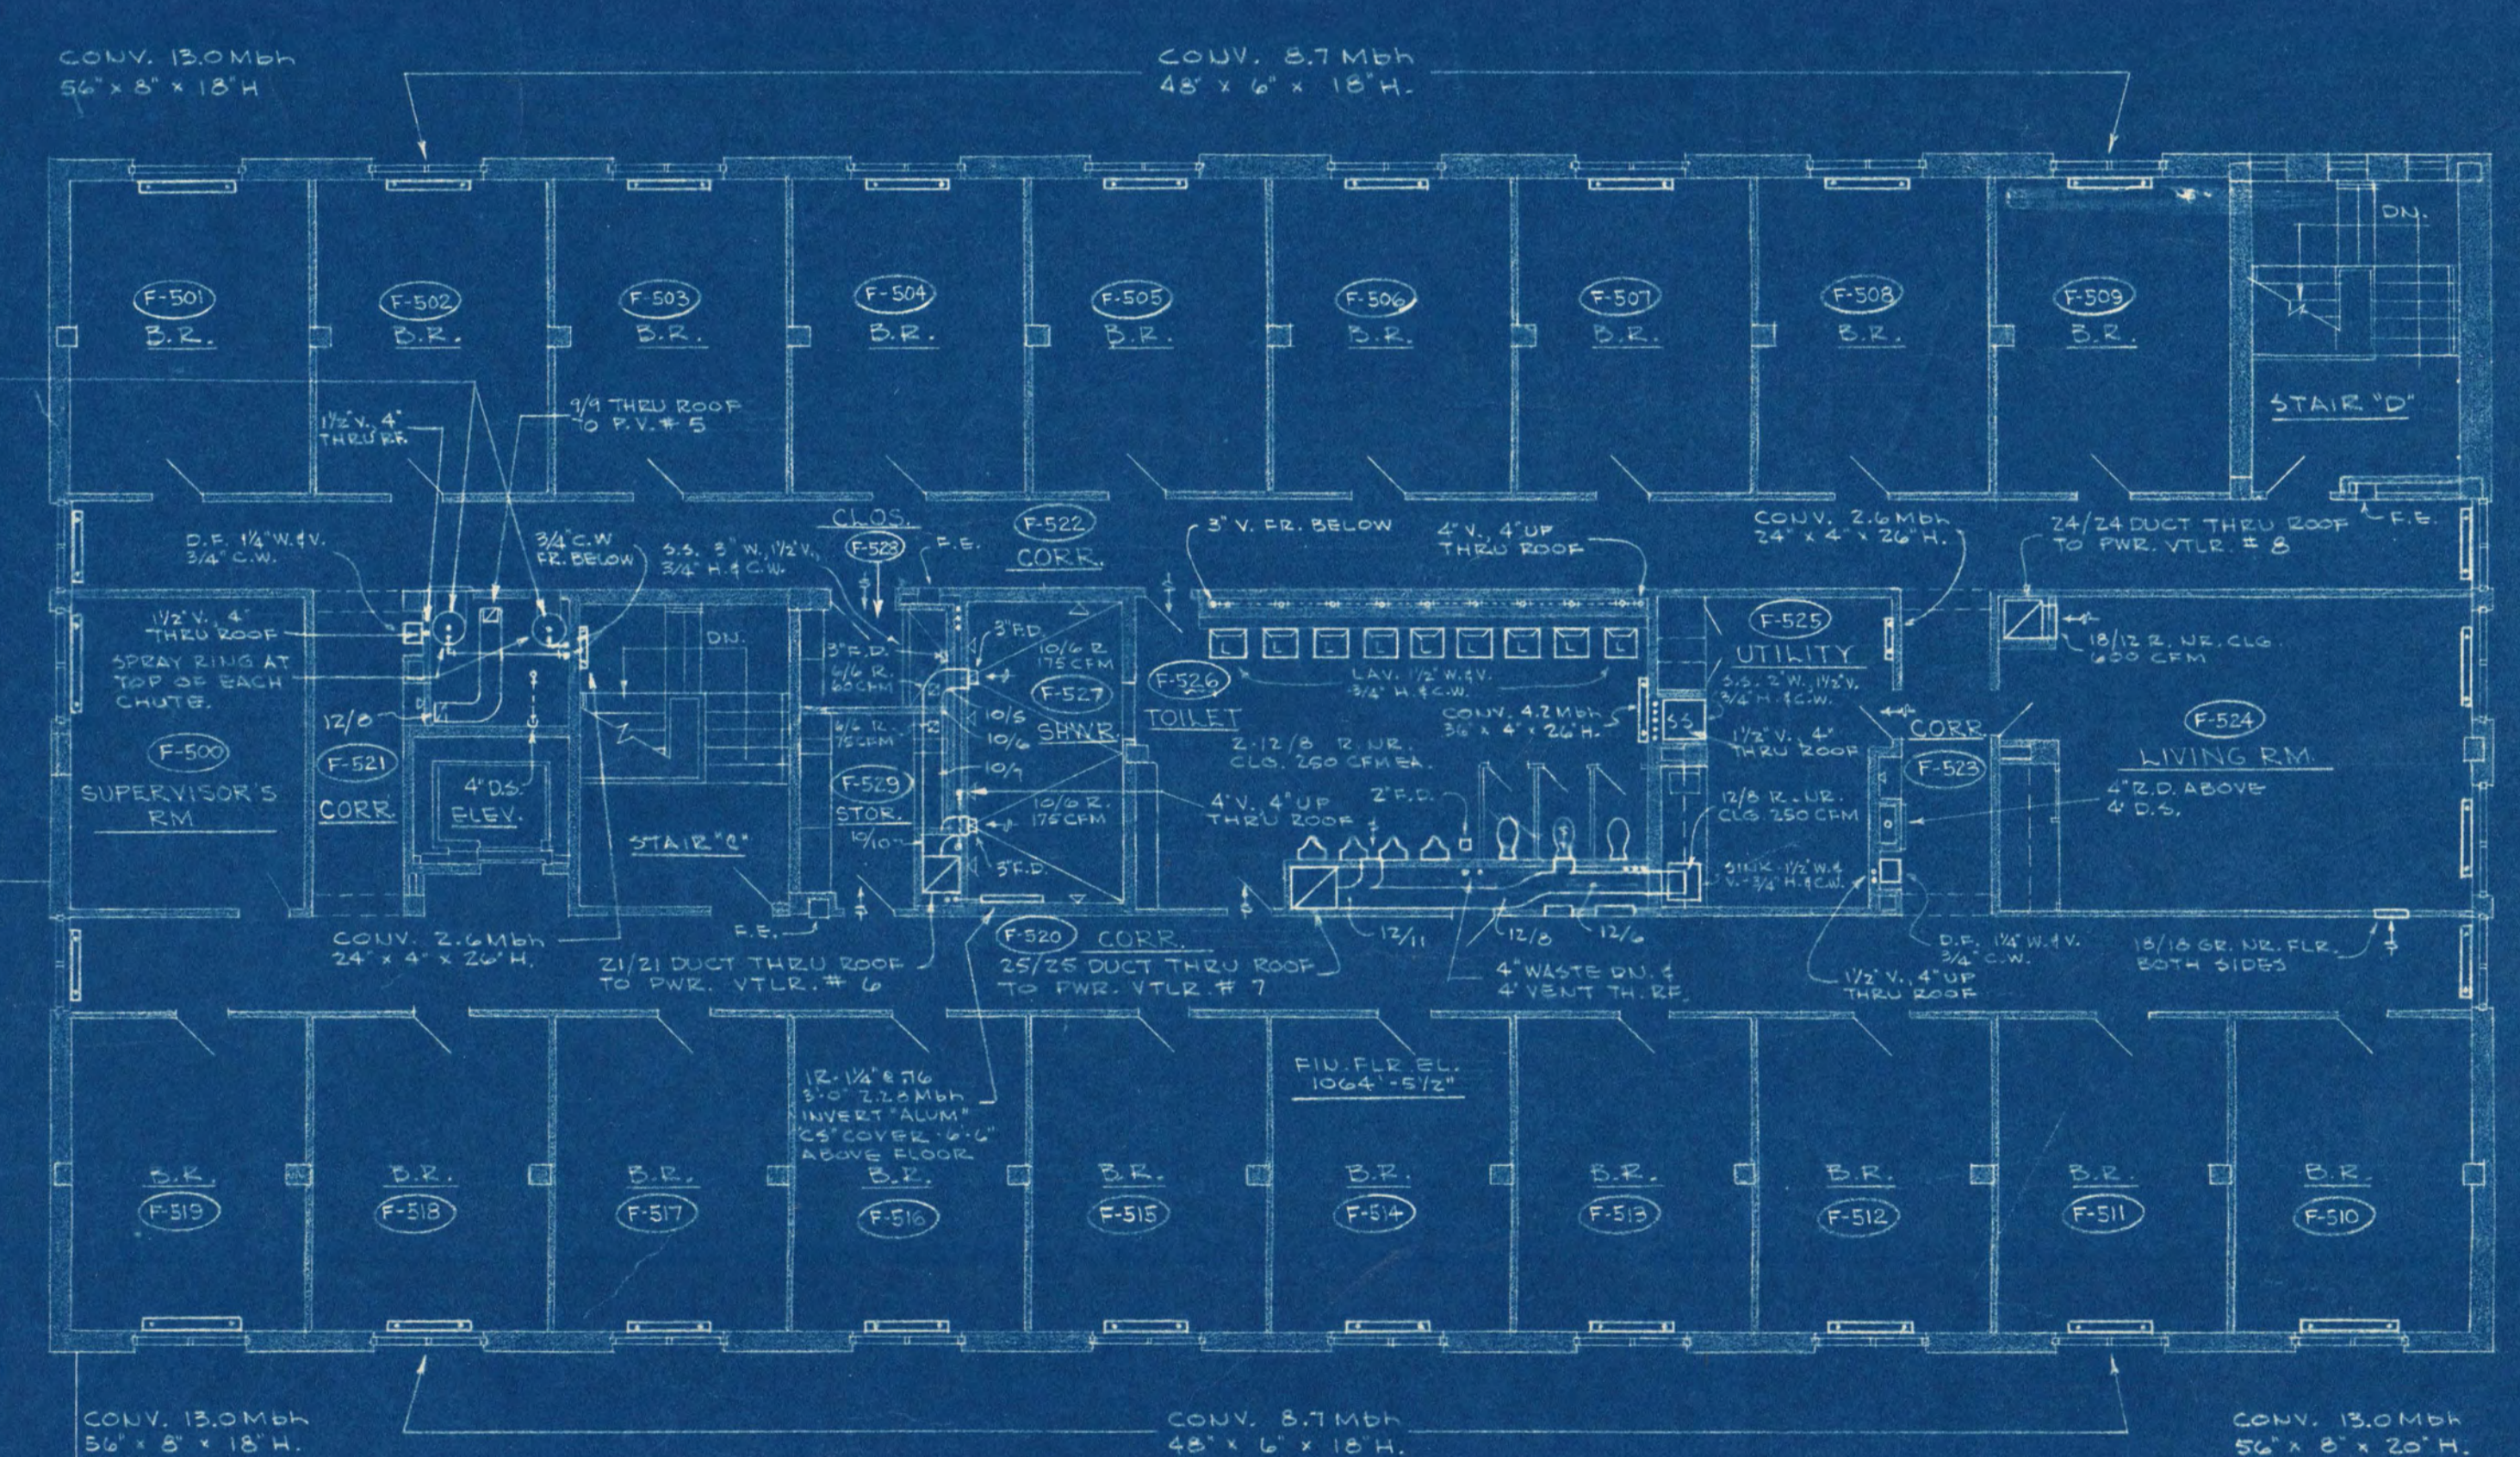
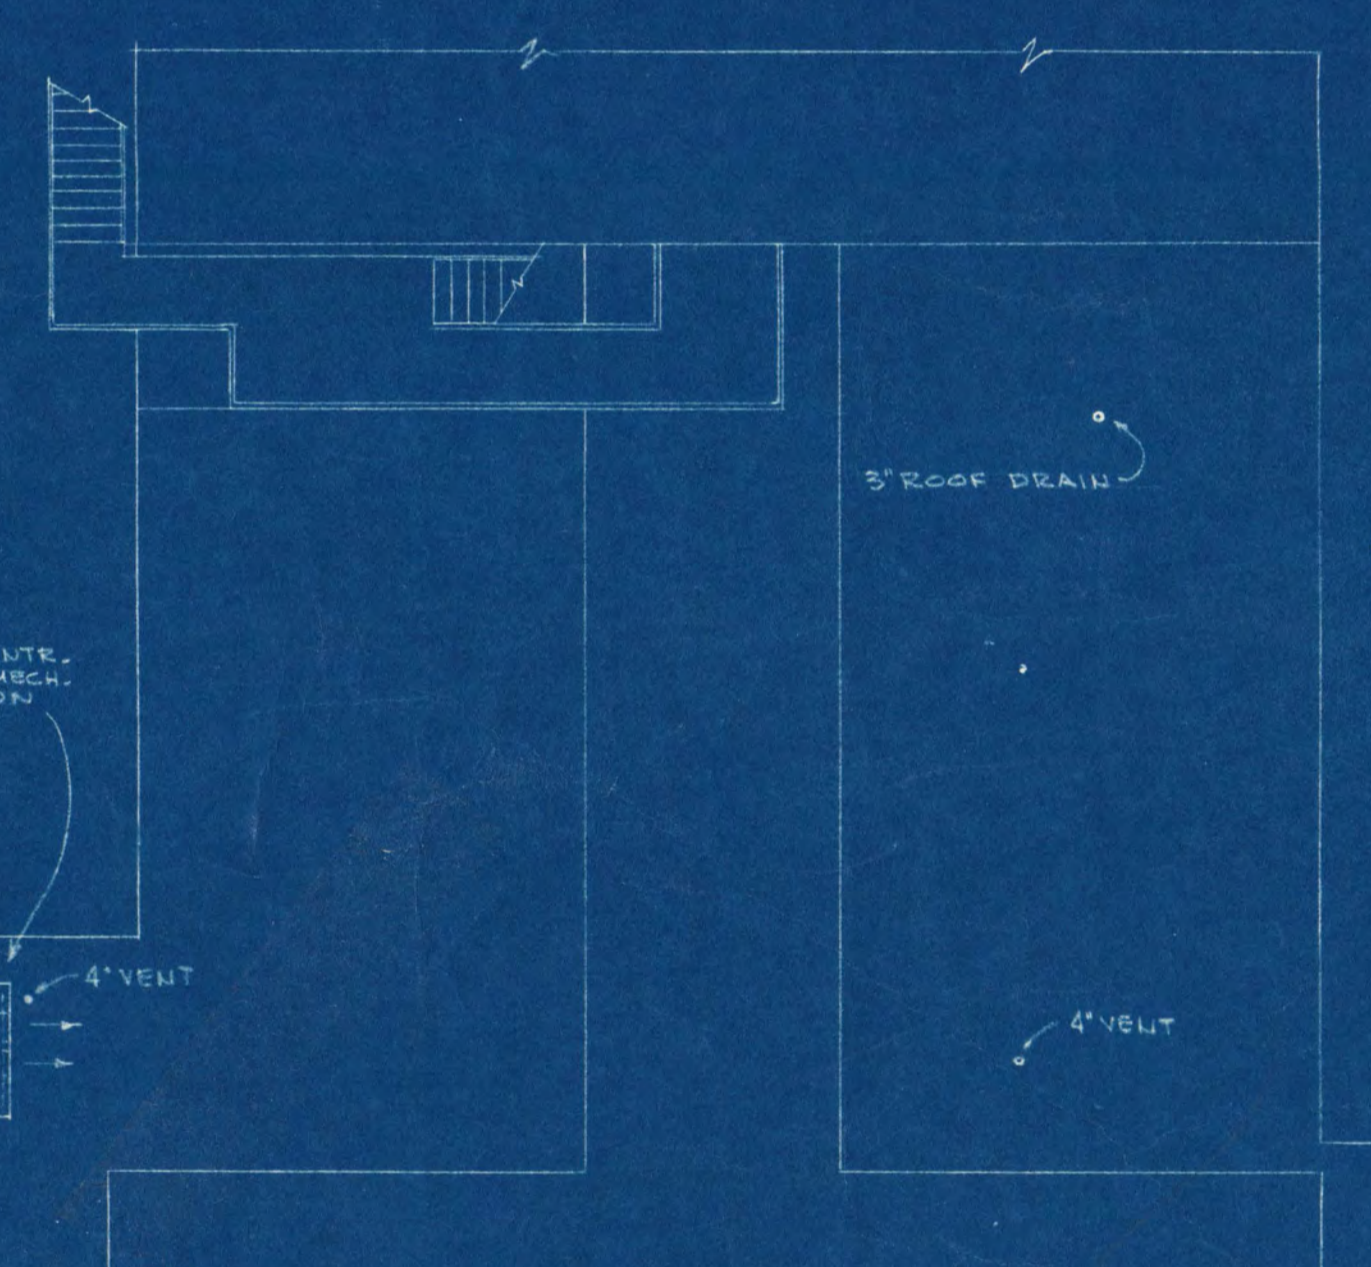


FIFTH FLOOR & ROOF PLAN
SCALE 1/8" = 1'-0"

FIFTH FLOOR PLAN
SCALE 1/8" = 1'-0"
ROOF PLAN
SCALE 1/8" = 1'-0"
EXHAUST RISER DIAGRAMS
SCALE AS SHOWN

ADDITION TO SHOEMAKER HALL ST. CLOUD STATE COLLEGE ST. CLOUD, MINNESOTA	
DESIGNED BY	FRANK W. JACKSON & ASSOCIATES, INC. ST. CLOUD, MINNESOTA
DRAWN BY	ORR, SCHELEN, INC. CONSULTING ENGINEERS MINNEAPOLIS, MINNESOTA
DATE	3-7-51
APPROVED BY	
APPROVED BY	
APPROVED BY	

M
6

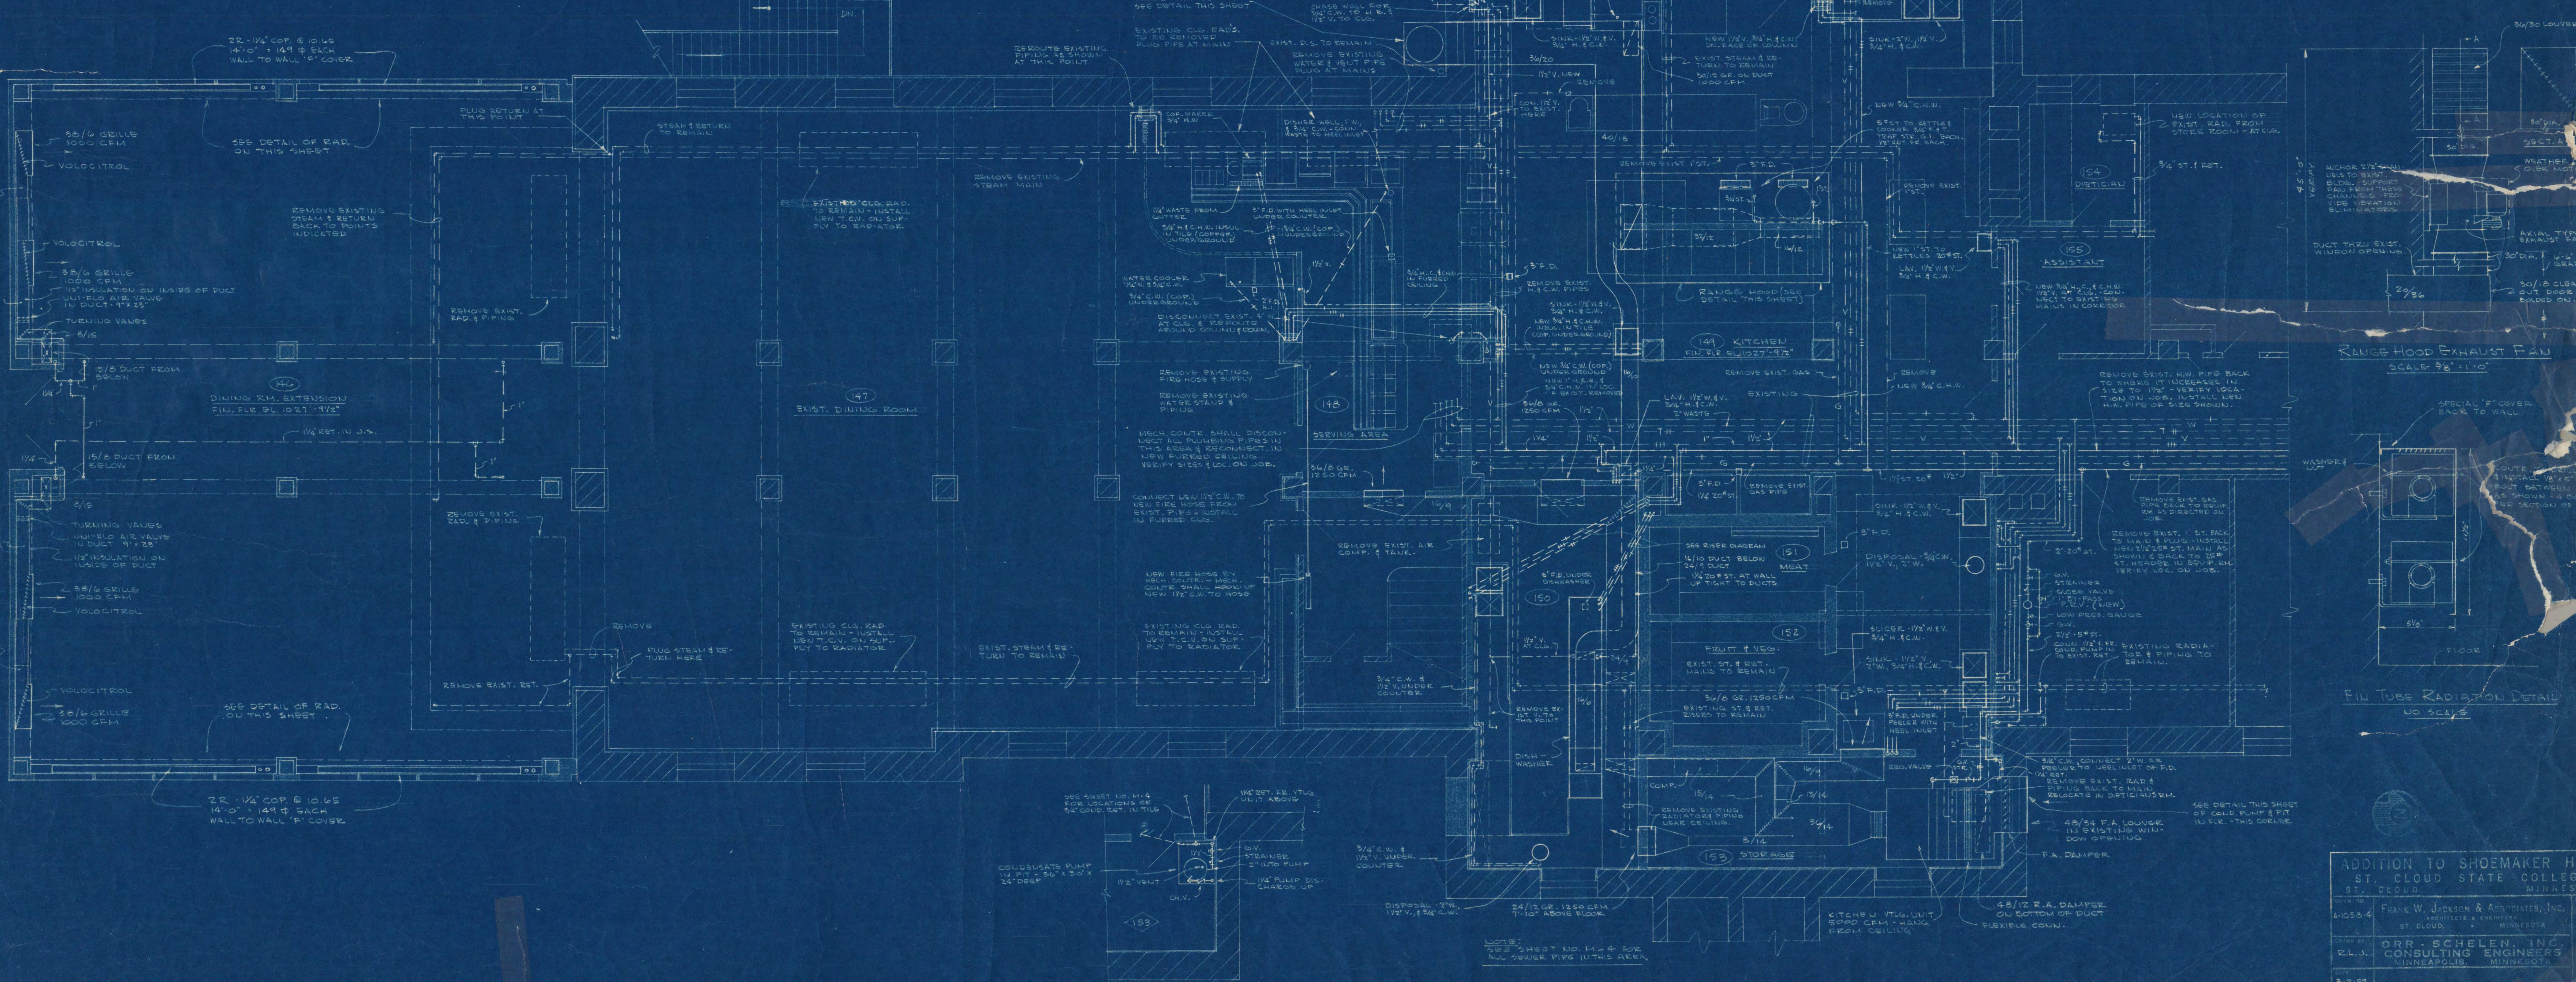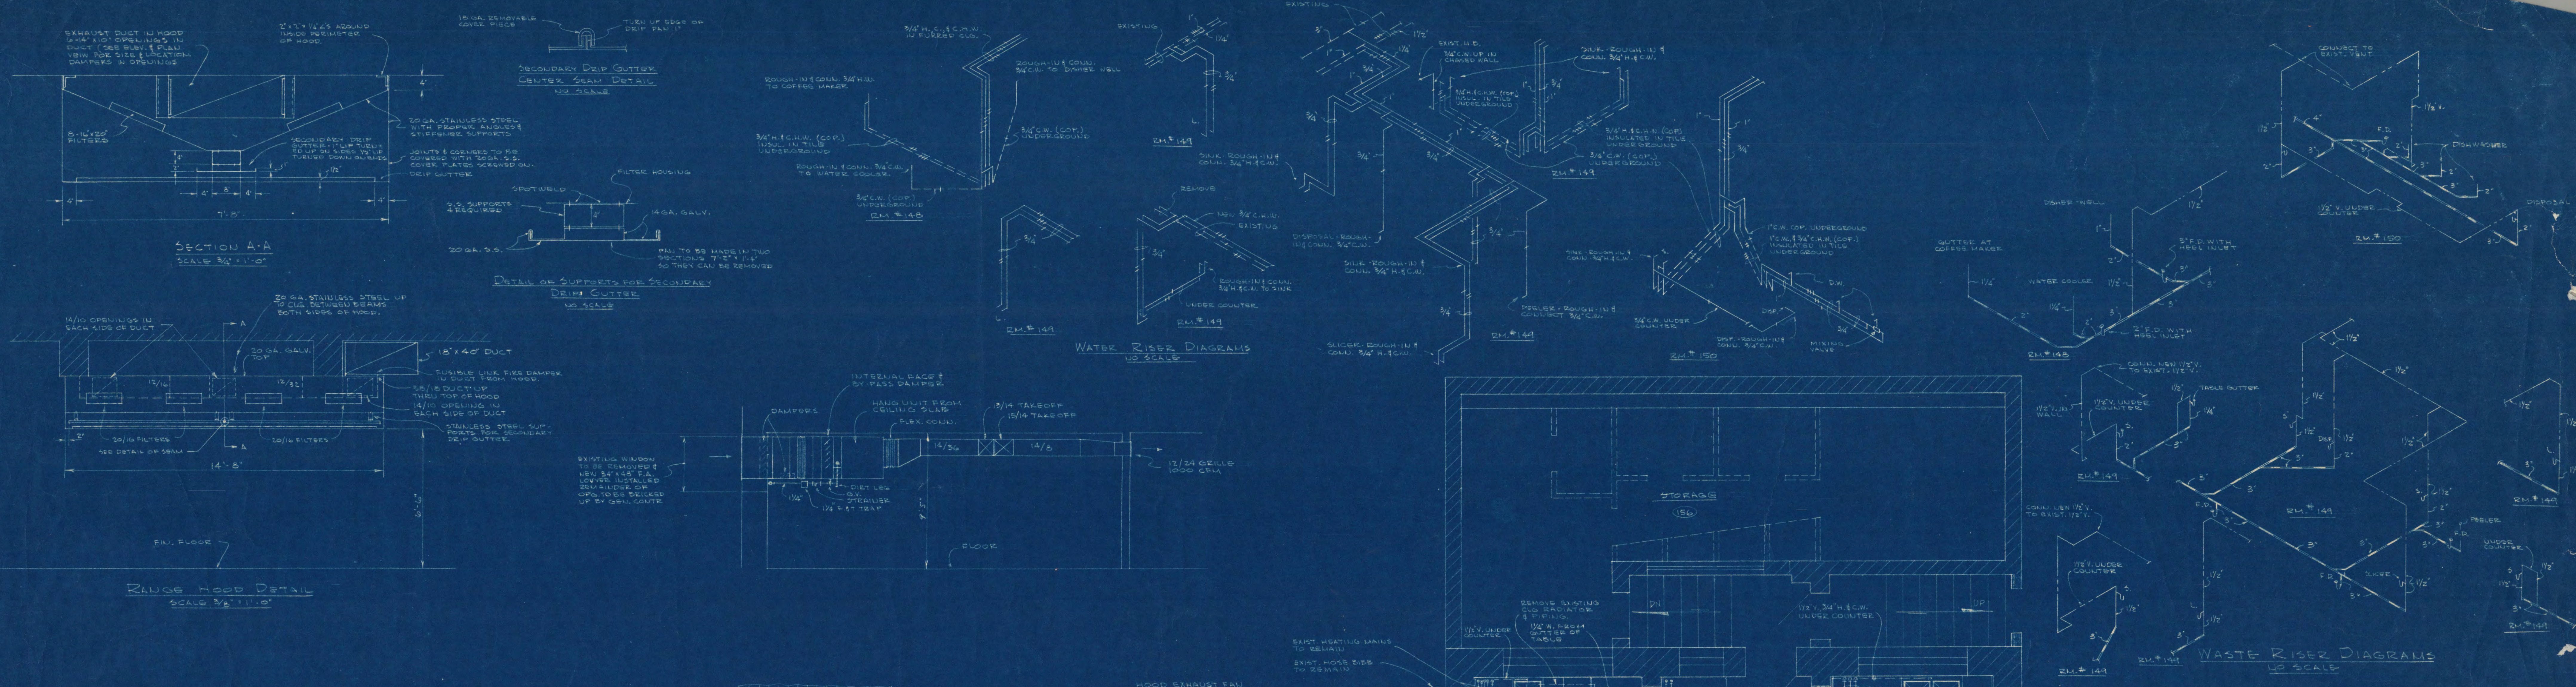

ADDITION TO SHOEMAKER HALL
ST. CLOUD STATE COLLEGE
ST. CLOUD, MINNESOTA
FRANK W. JOHNSON & ASSOCIATES, INC.
CONSULTING ENGINEERS
MINNEAPOLIS, MINNESOTA
SEP 29 1954