













ROOM USE	ROOM NUMBER
BED ROOMS	101 TO 150, INCLUDING
BED ROOMS	151 TO 160, INCLUDING
BED ROOMS	161 TO 170, INCLUDING
REST ROOM	171
CORRIDOR	151
CORRIDOR	152
CORRIDOR	153
CORRIDOR	154
CORRIDOR	155
CORRIDOR	156
REST ROOM	157
TOILET	158
TOILET	159
TOILET	160
TOILET	300

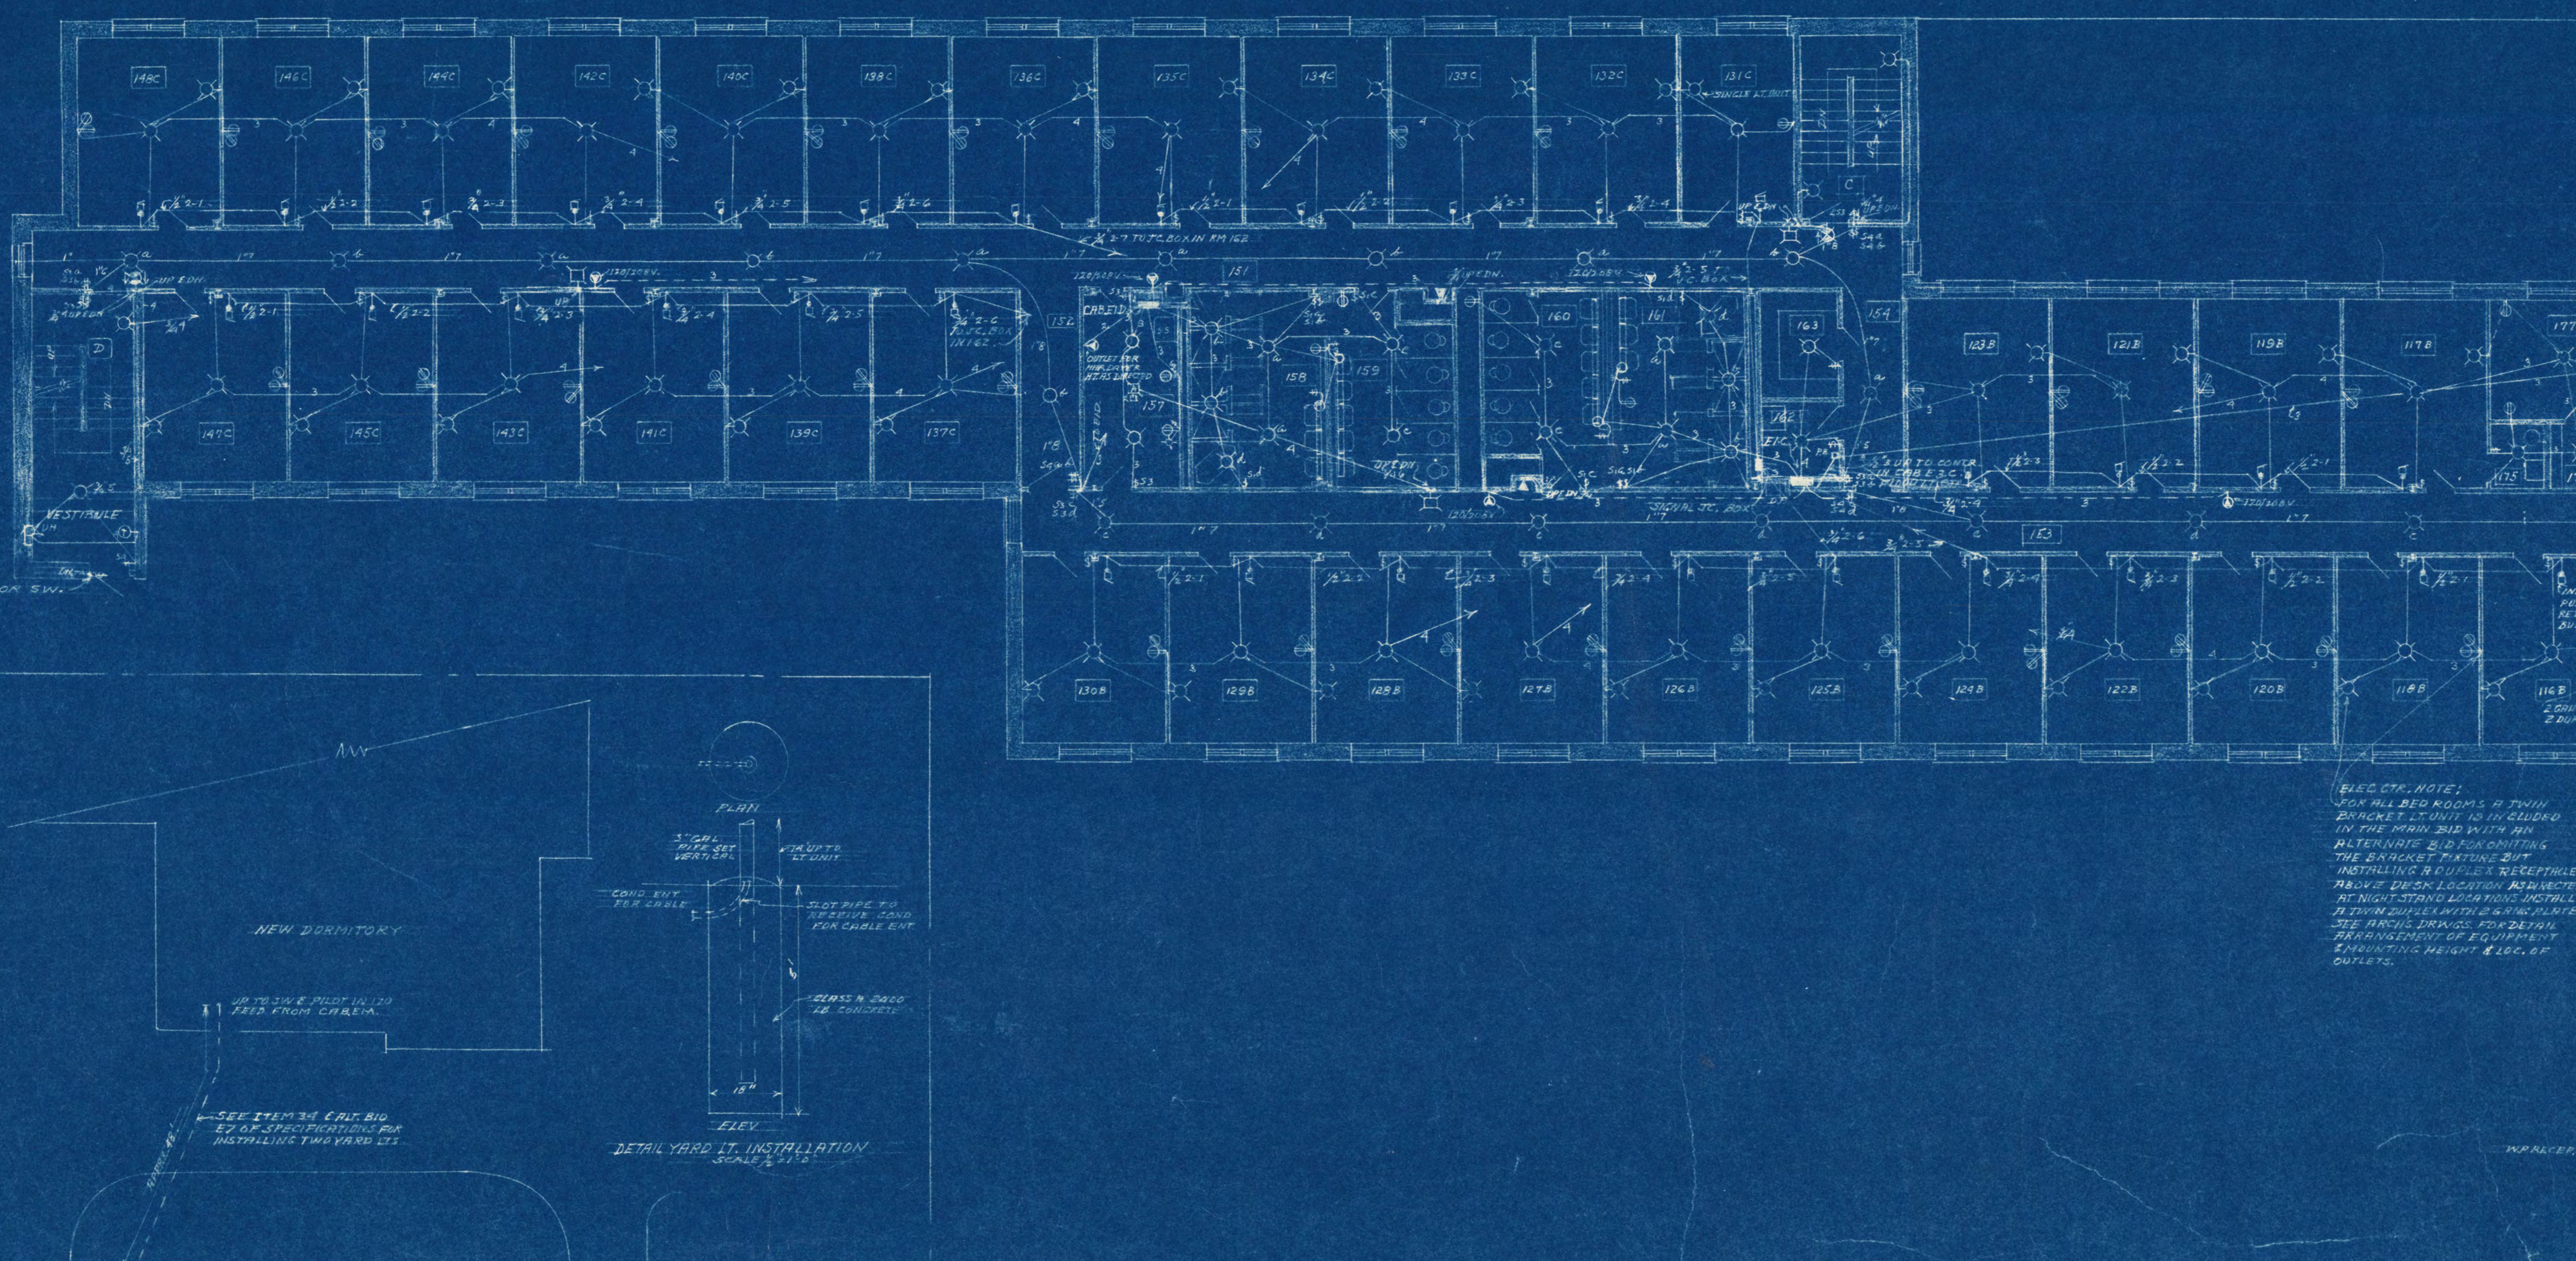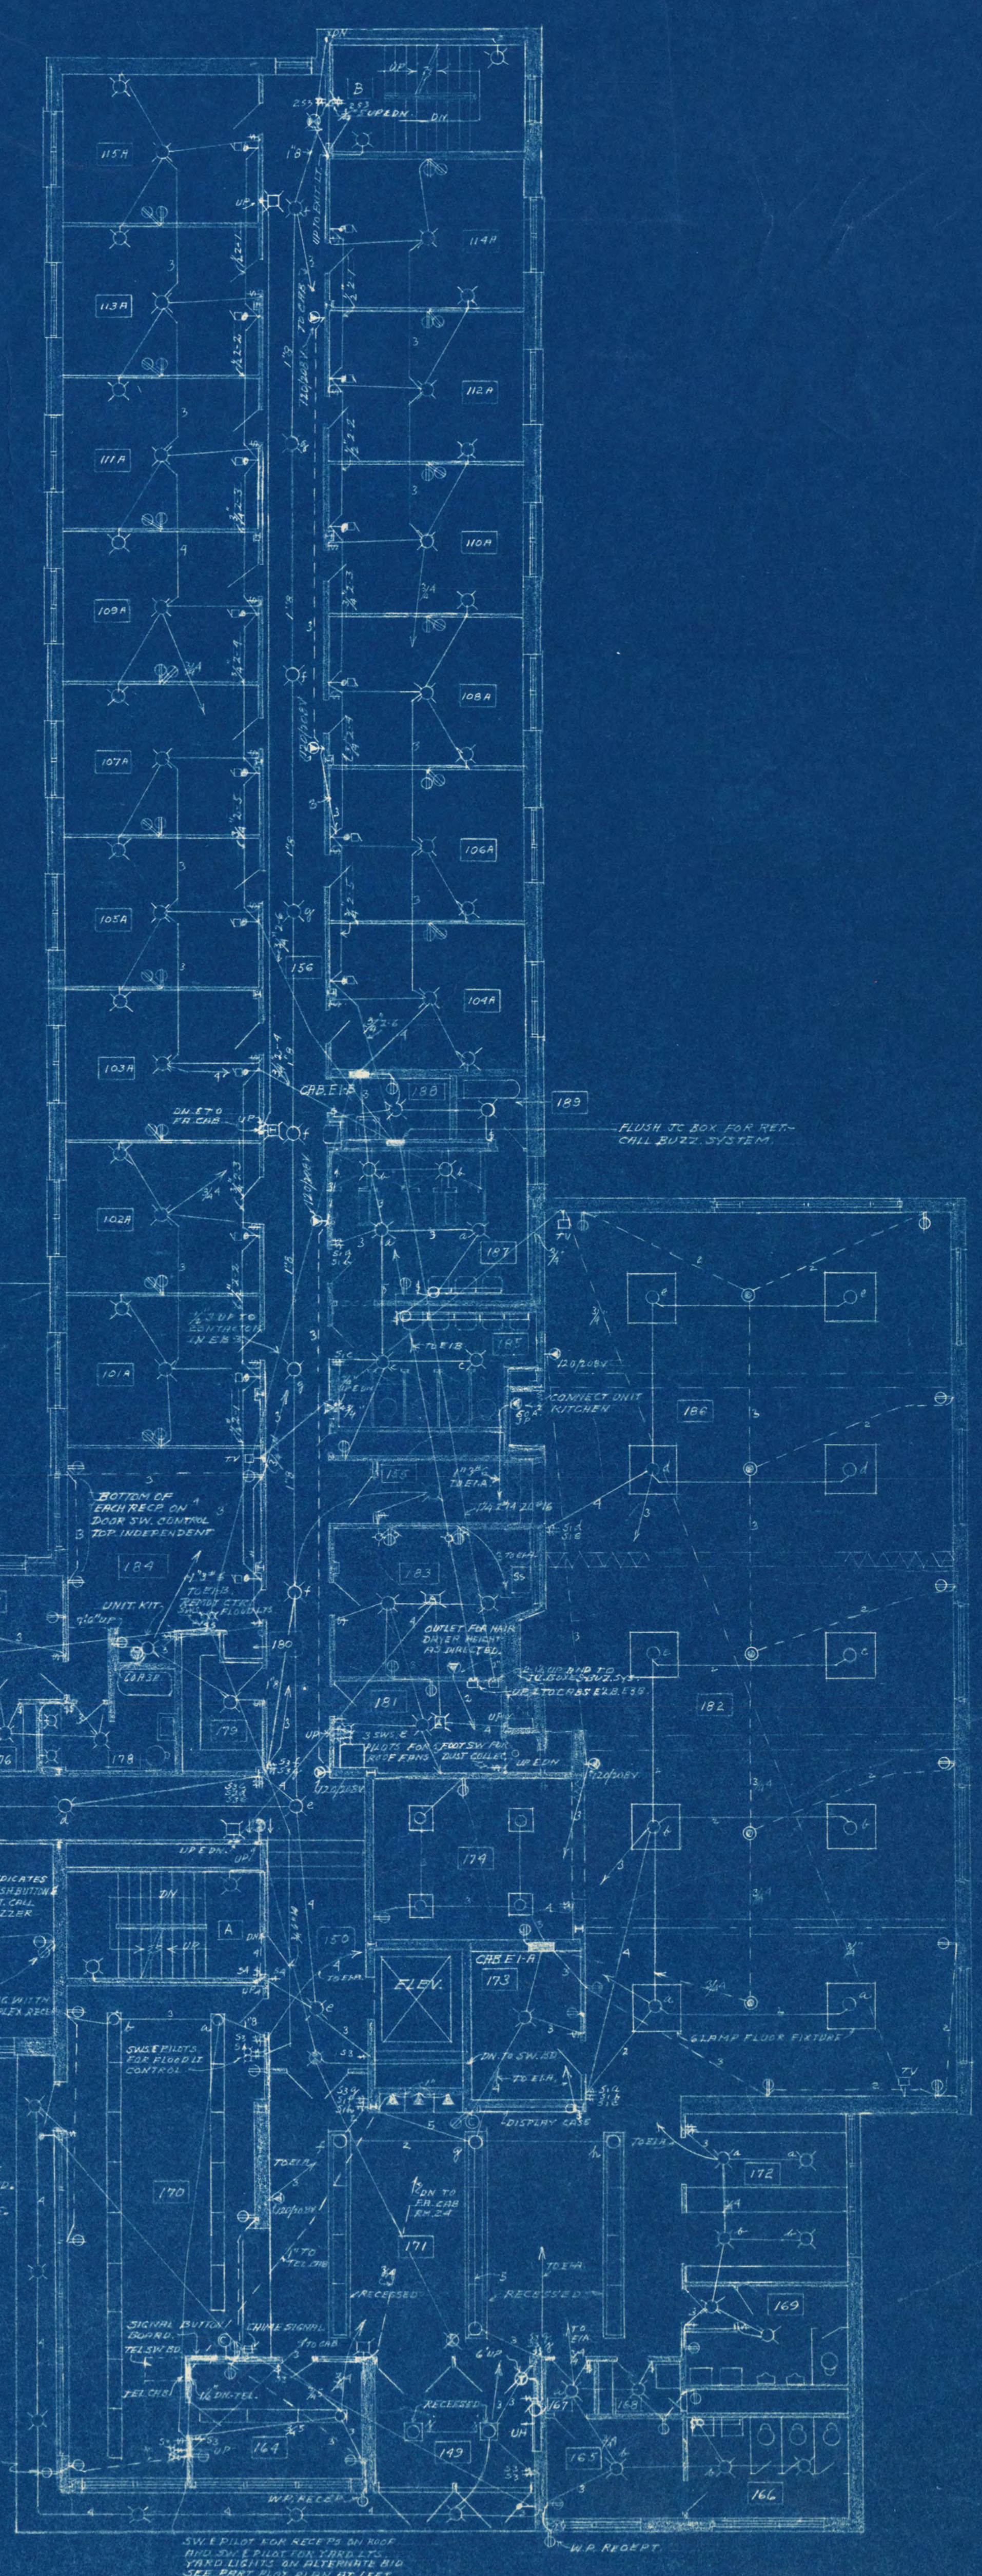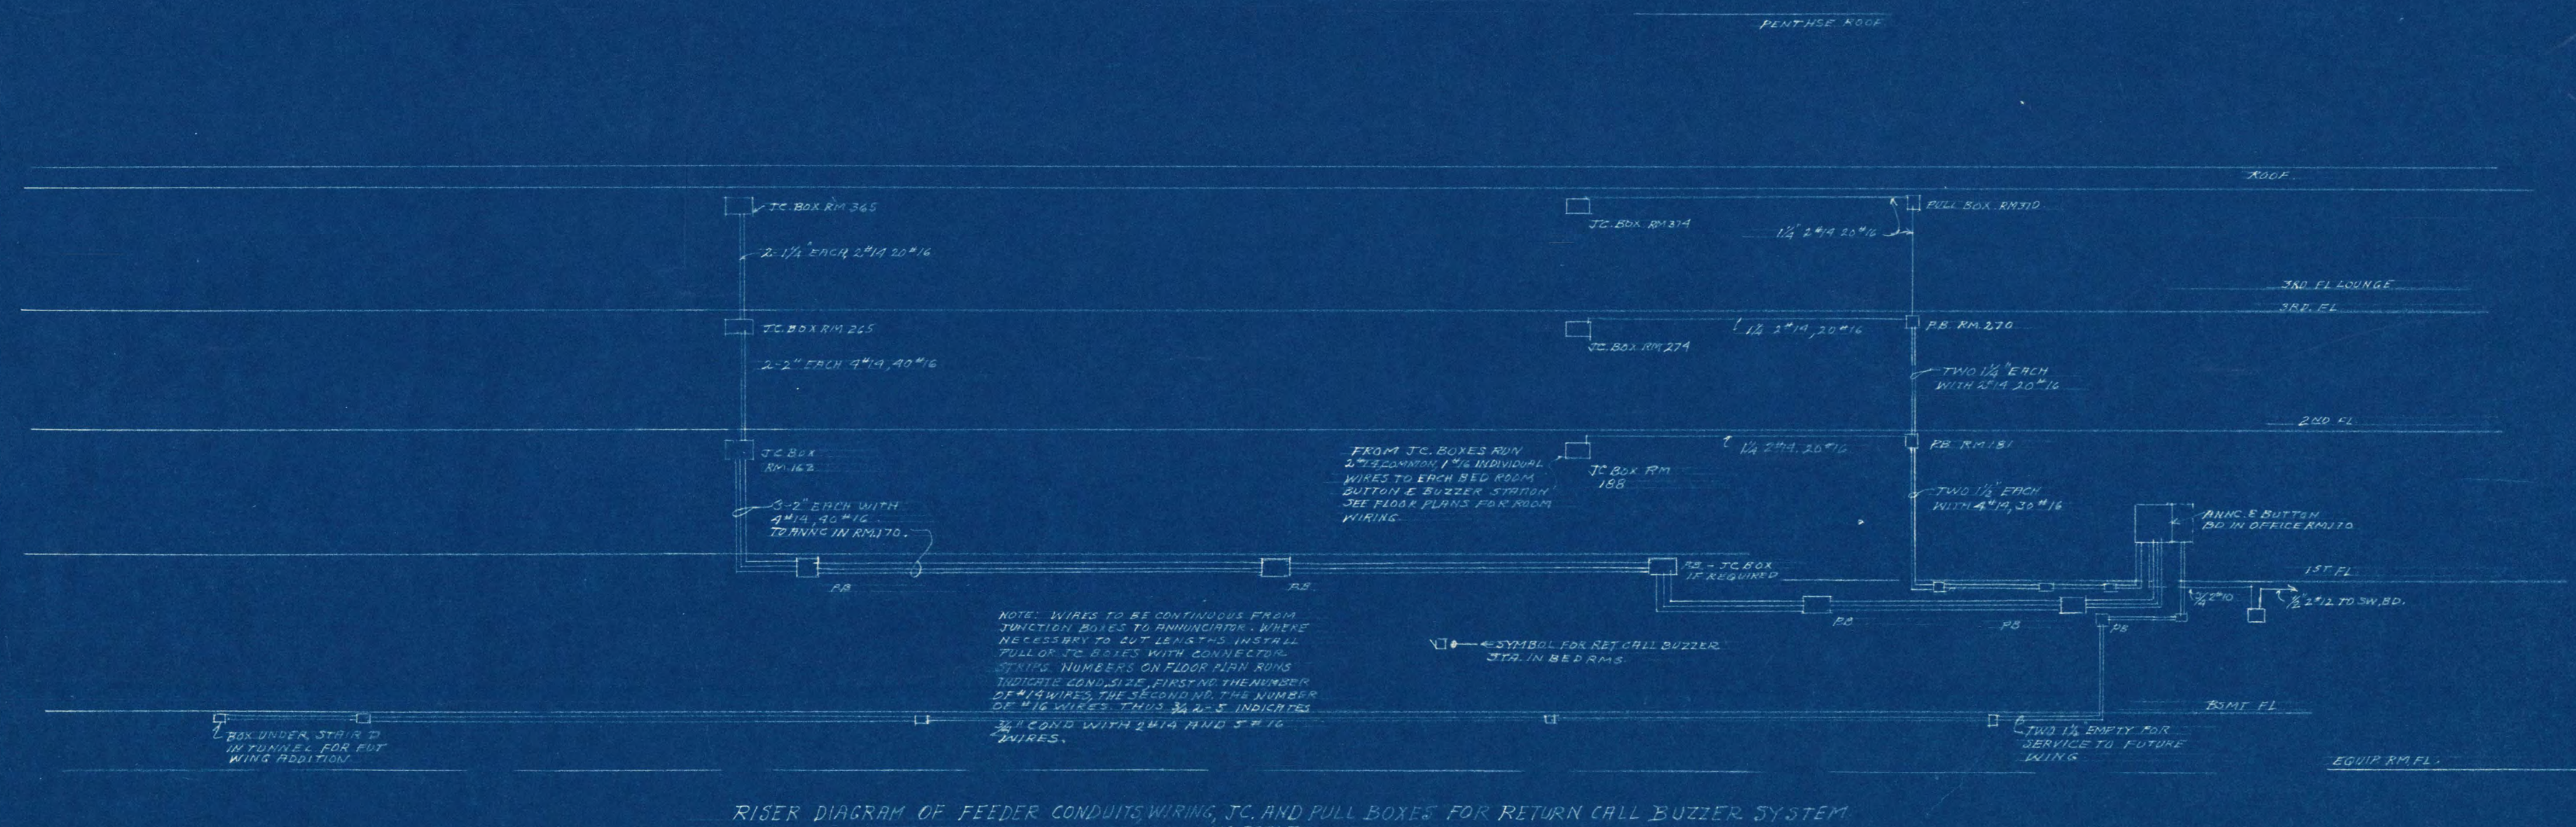




FIRST FLOOR PLAN  
SCALE - 1/8" = 1'-0"

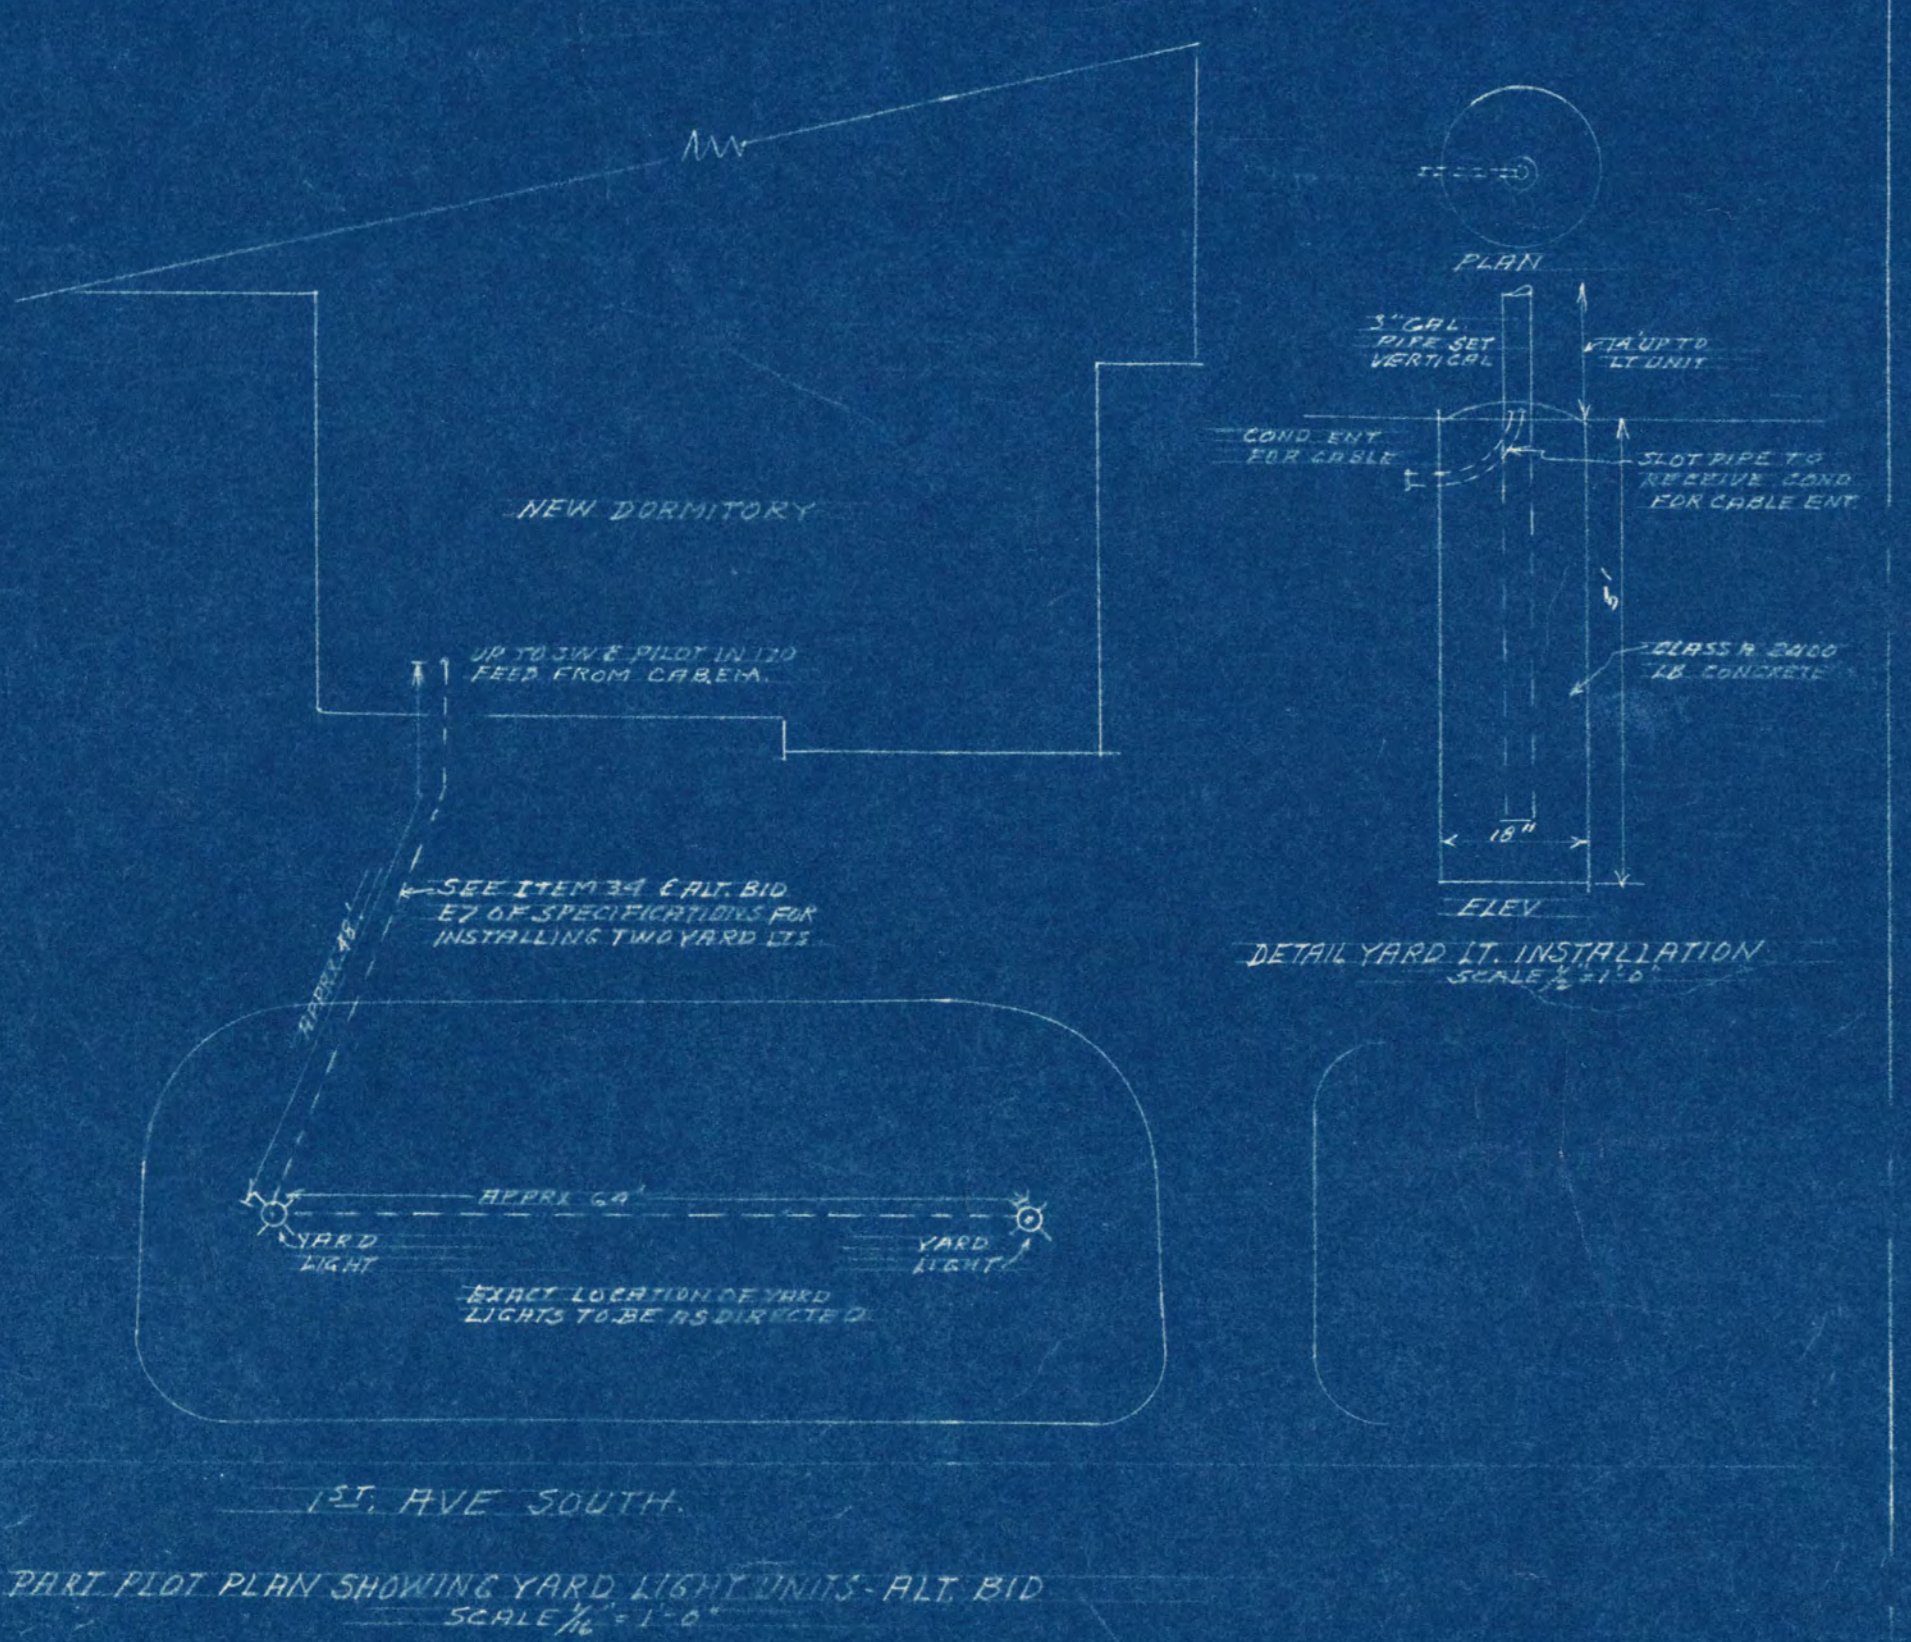

FIRST FLOOR PLAN - ELECTRICAL			
GIRL'S DORMITORY, ST. CLOUD STATE TEACHERS COLLEGE, ST. CLOUD, MINNESOTA.			
DATE	4-26-66	DESIGNED BY	FRANK W. JACKSON & ASSOCIATES, INC., ST. CLOUD, MINNESOTA
DRAWN BY	W. B. B.	CHECKED BY	G. M. ORR ENGINEERING CO., MINNEAPOLIS, MINNESOTA
DATE	JUNE 15, 1966	APPROVED BY	<i>[Signature]</i>
SCALE		PROJECT NO.	E 4








ROOM SCHEDULE		
ROOM USE	SQ. FT.	3RD FL.
REG. ROOMS	2500	2500
ASSIST. DIR. BED RM	276	276
REG. ROOMS	2340	2340
REG. ROOMS	2340	2340
ELEV. SHAFT	222	222
CORRIDOR	213	213
CORRIDOR	214	214
CORRIDOR	215	215
CORRIDOR	400	400

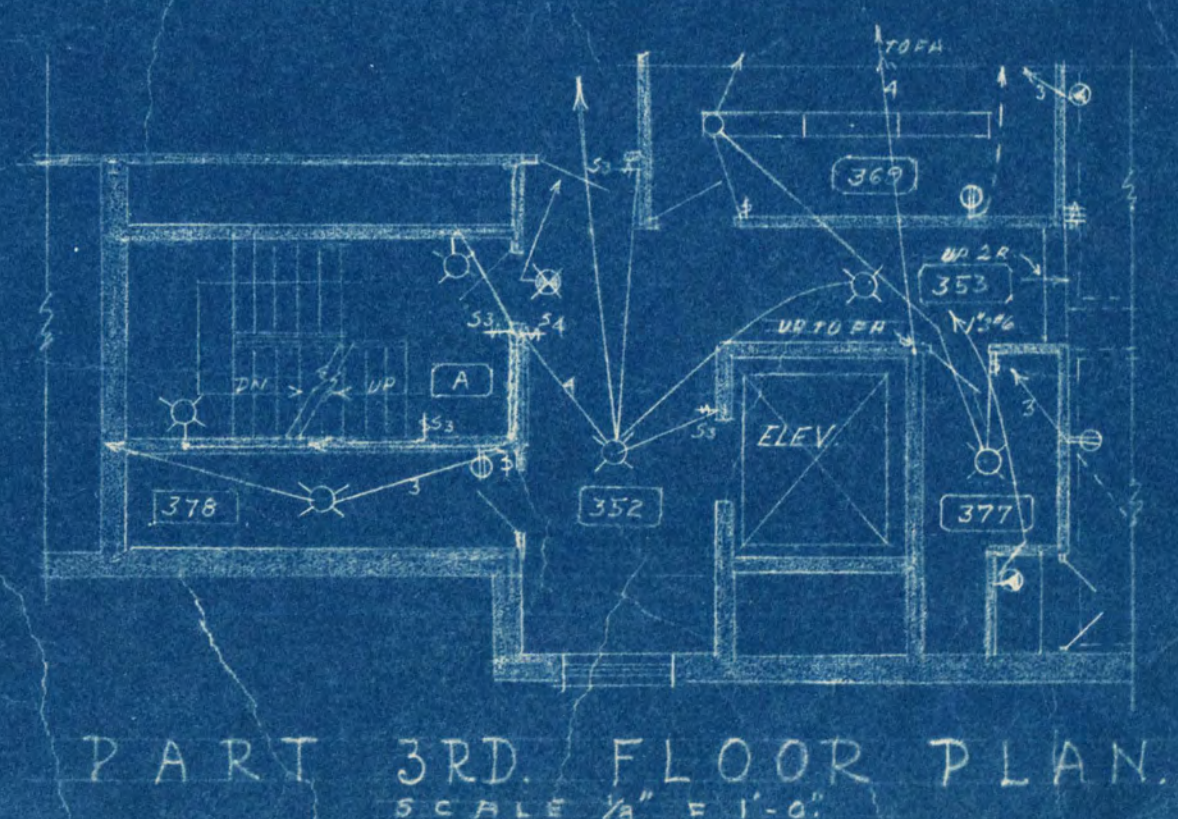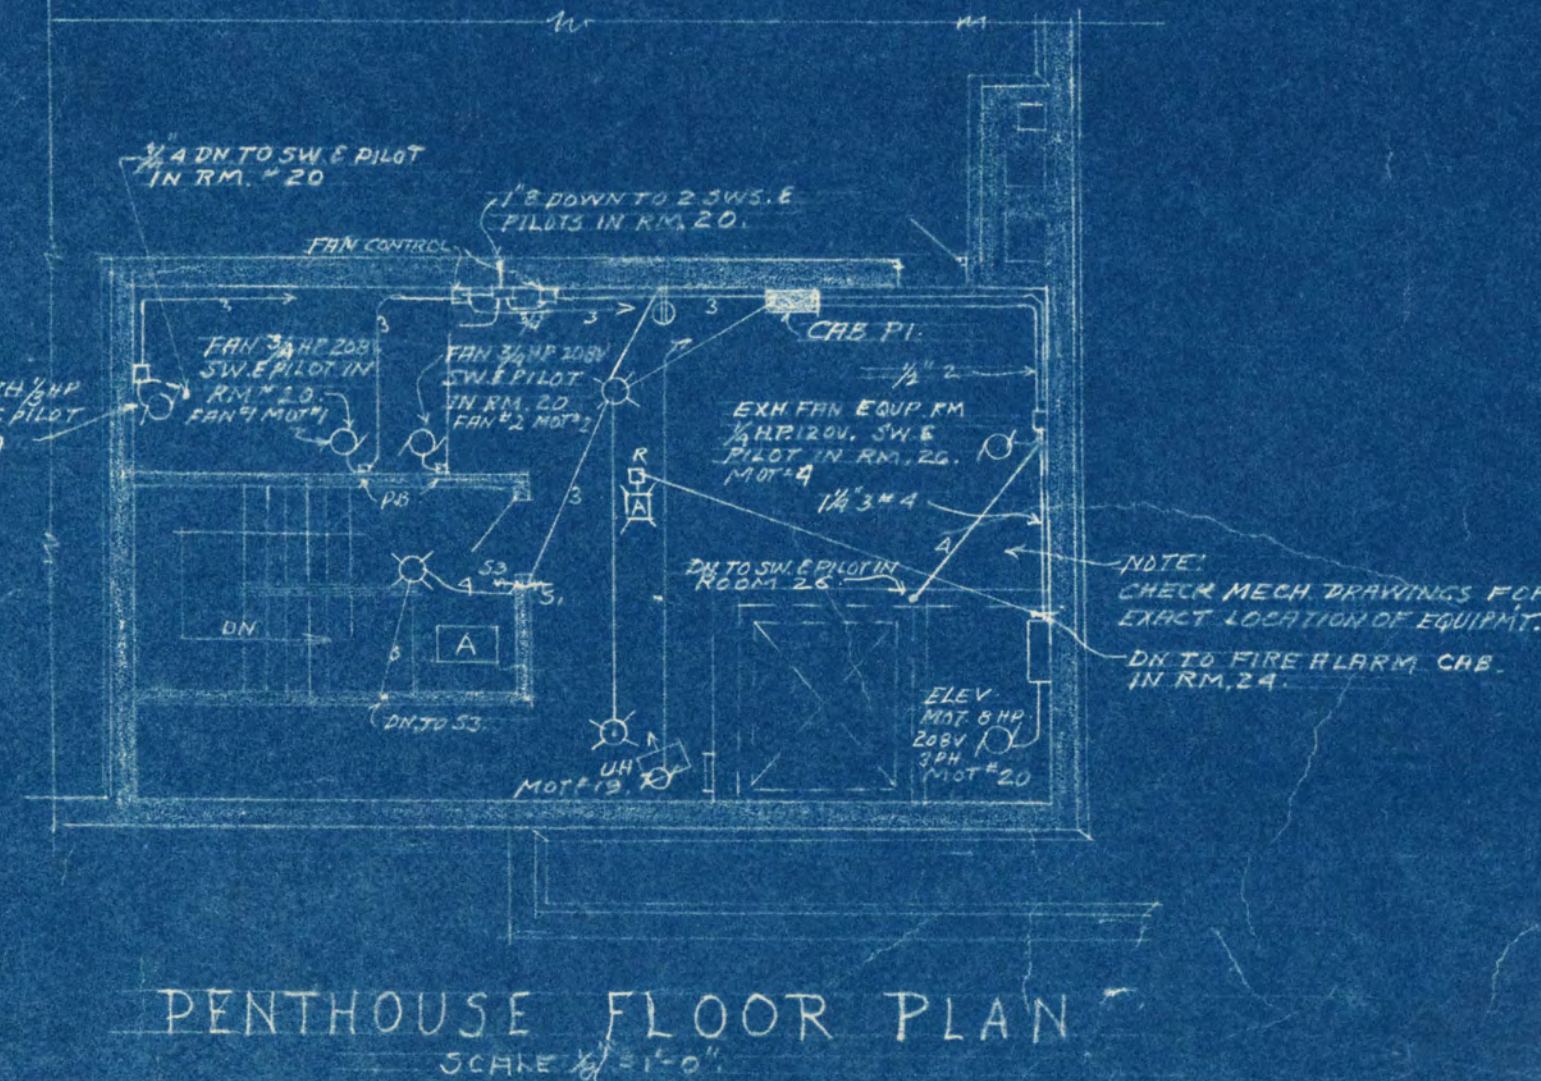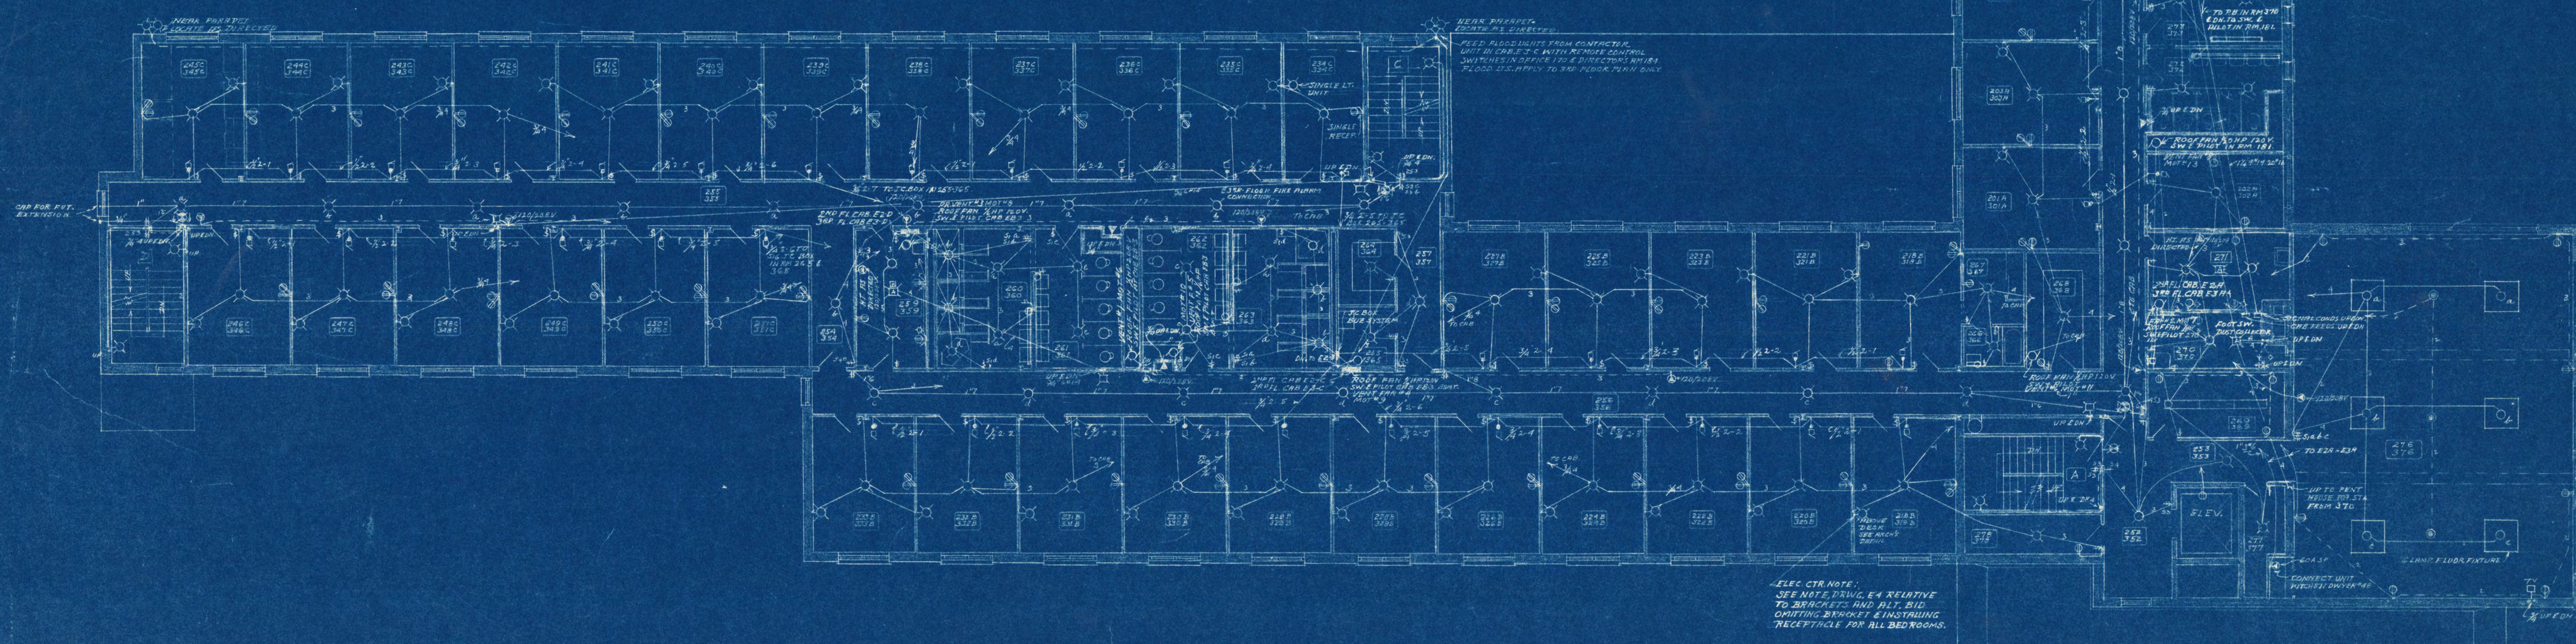

SECOND AND THIRD FLOOR PLAN - ELECTRICAL		
GIRL'S DORMITORY, ST. CLOUD STATE TEACHERS COLLEGE, ST. CLOUD, MINNESOTA.		
DRAWN BY 456-G	FRANK W. JACKSON & ASSOCIATES INC. ARCHITECTS ST. CLOUD, MINNESOTA.	E5
CHECKED BY W.C.B.	G. M. ORR ENGINEER (NO. 00) MINNESOTA ST. CLOUD, MINNESOTA.	
DATE JUNE 15, 1926	APPROVED BY <i>Frank W. Jackson</i>	ELECTRICAL
REVISIONS	APPROVED BY <i>G. M. Orr</i>	



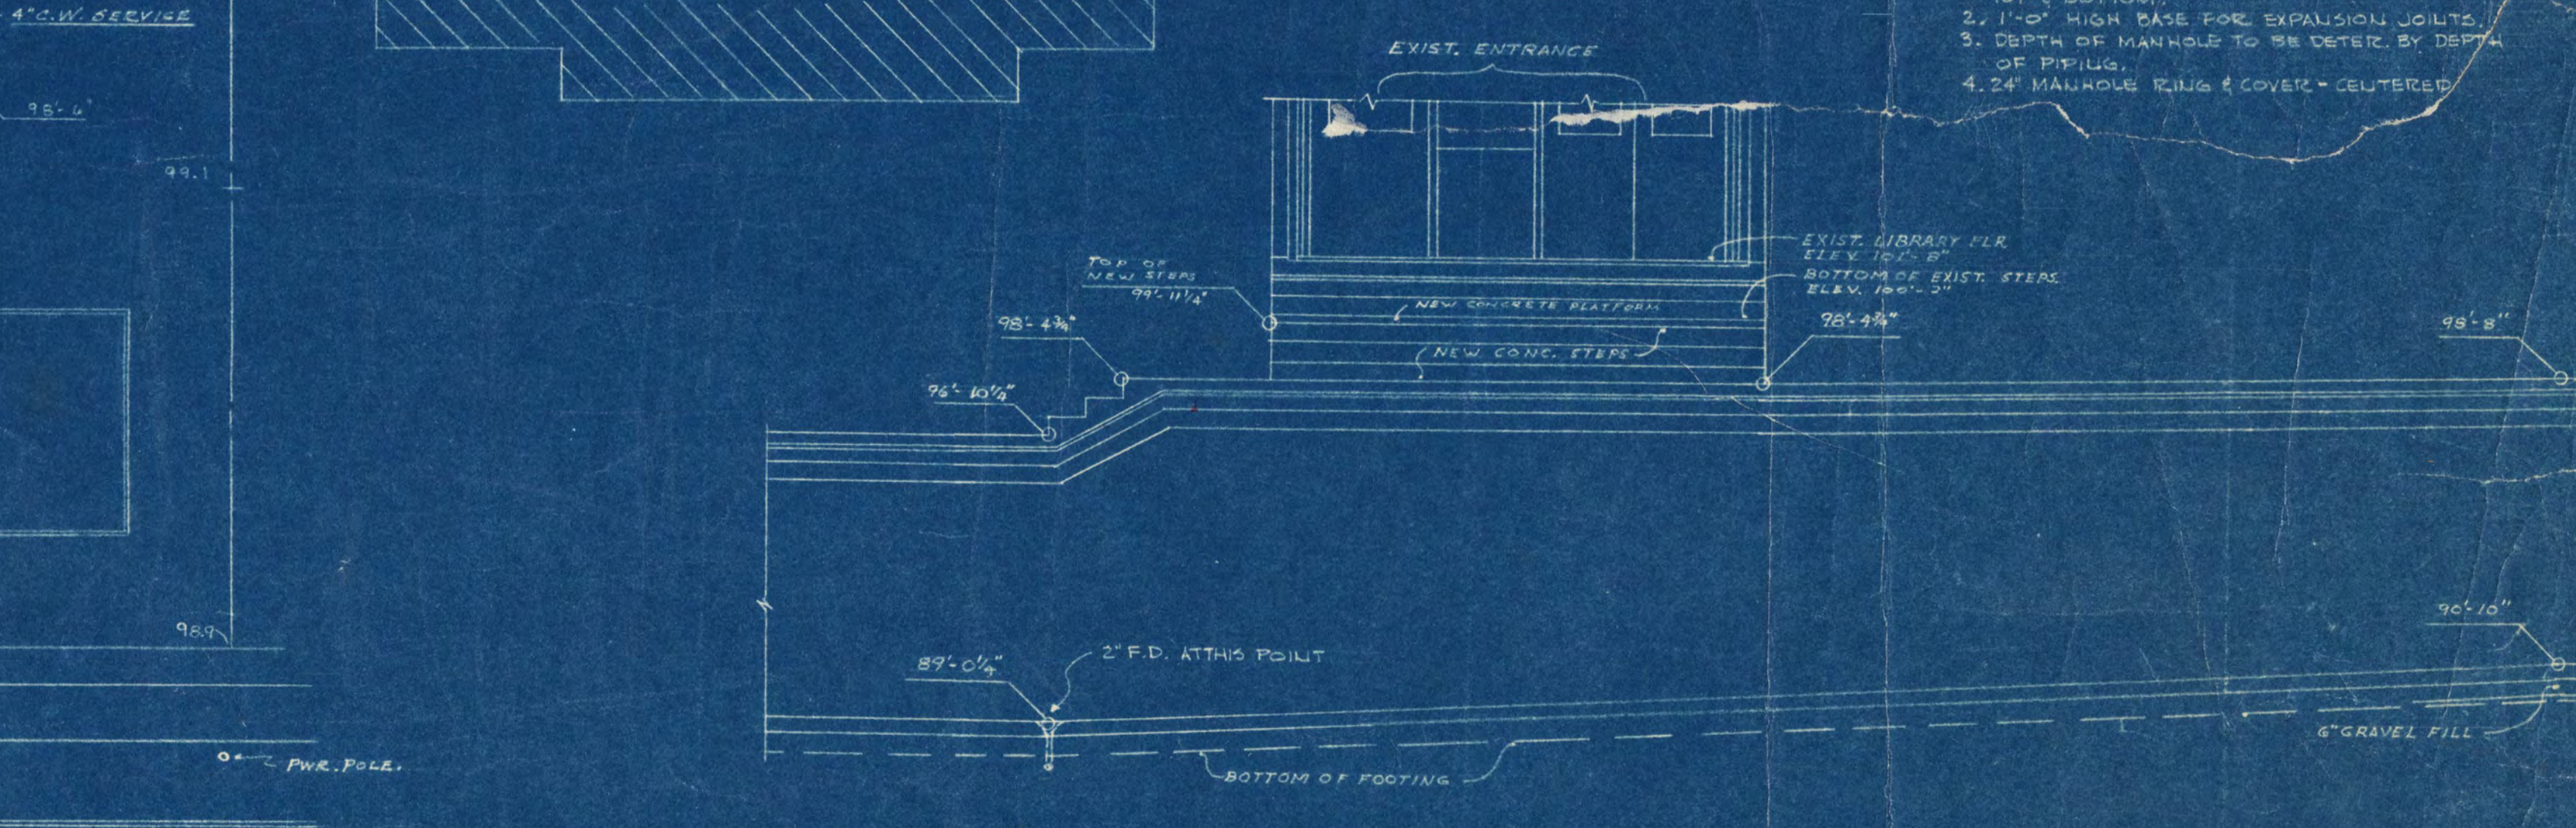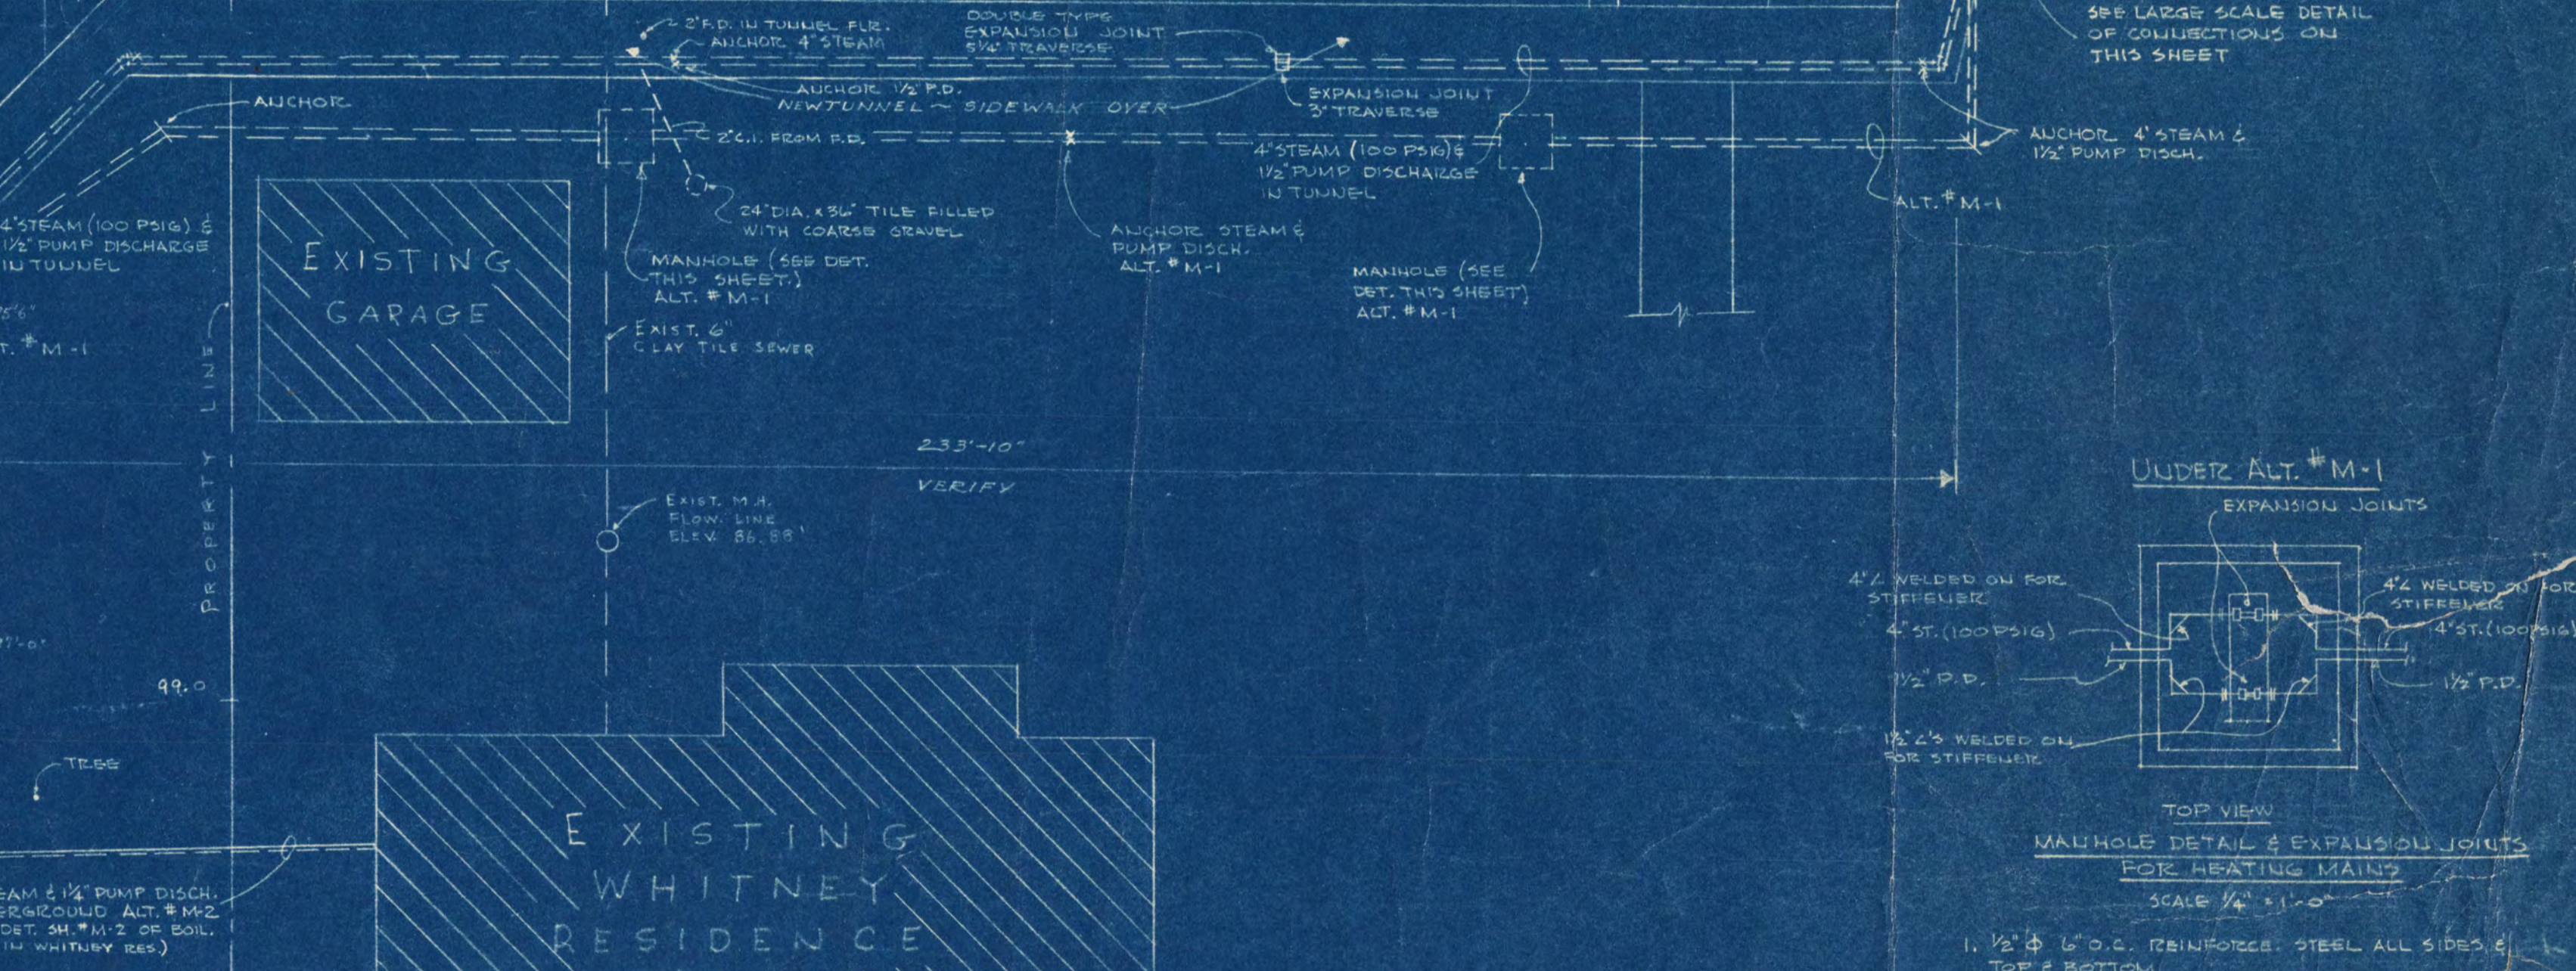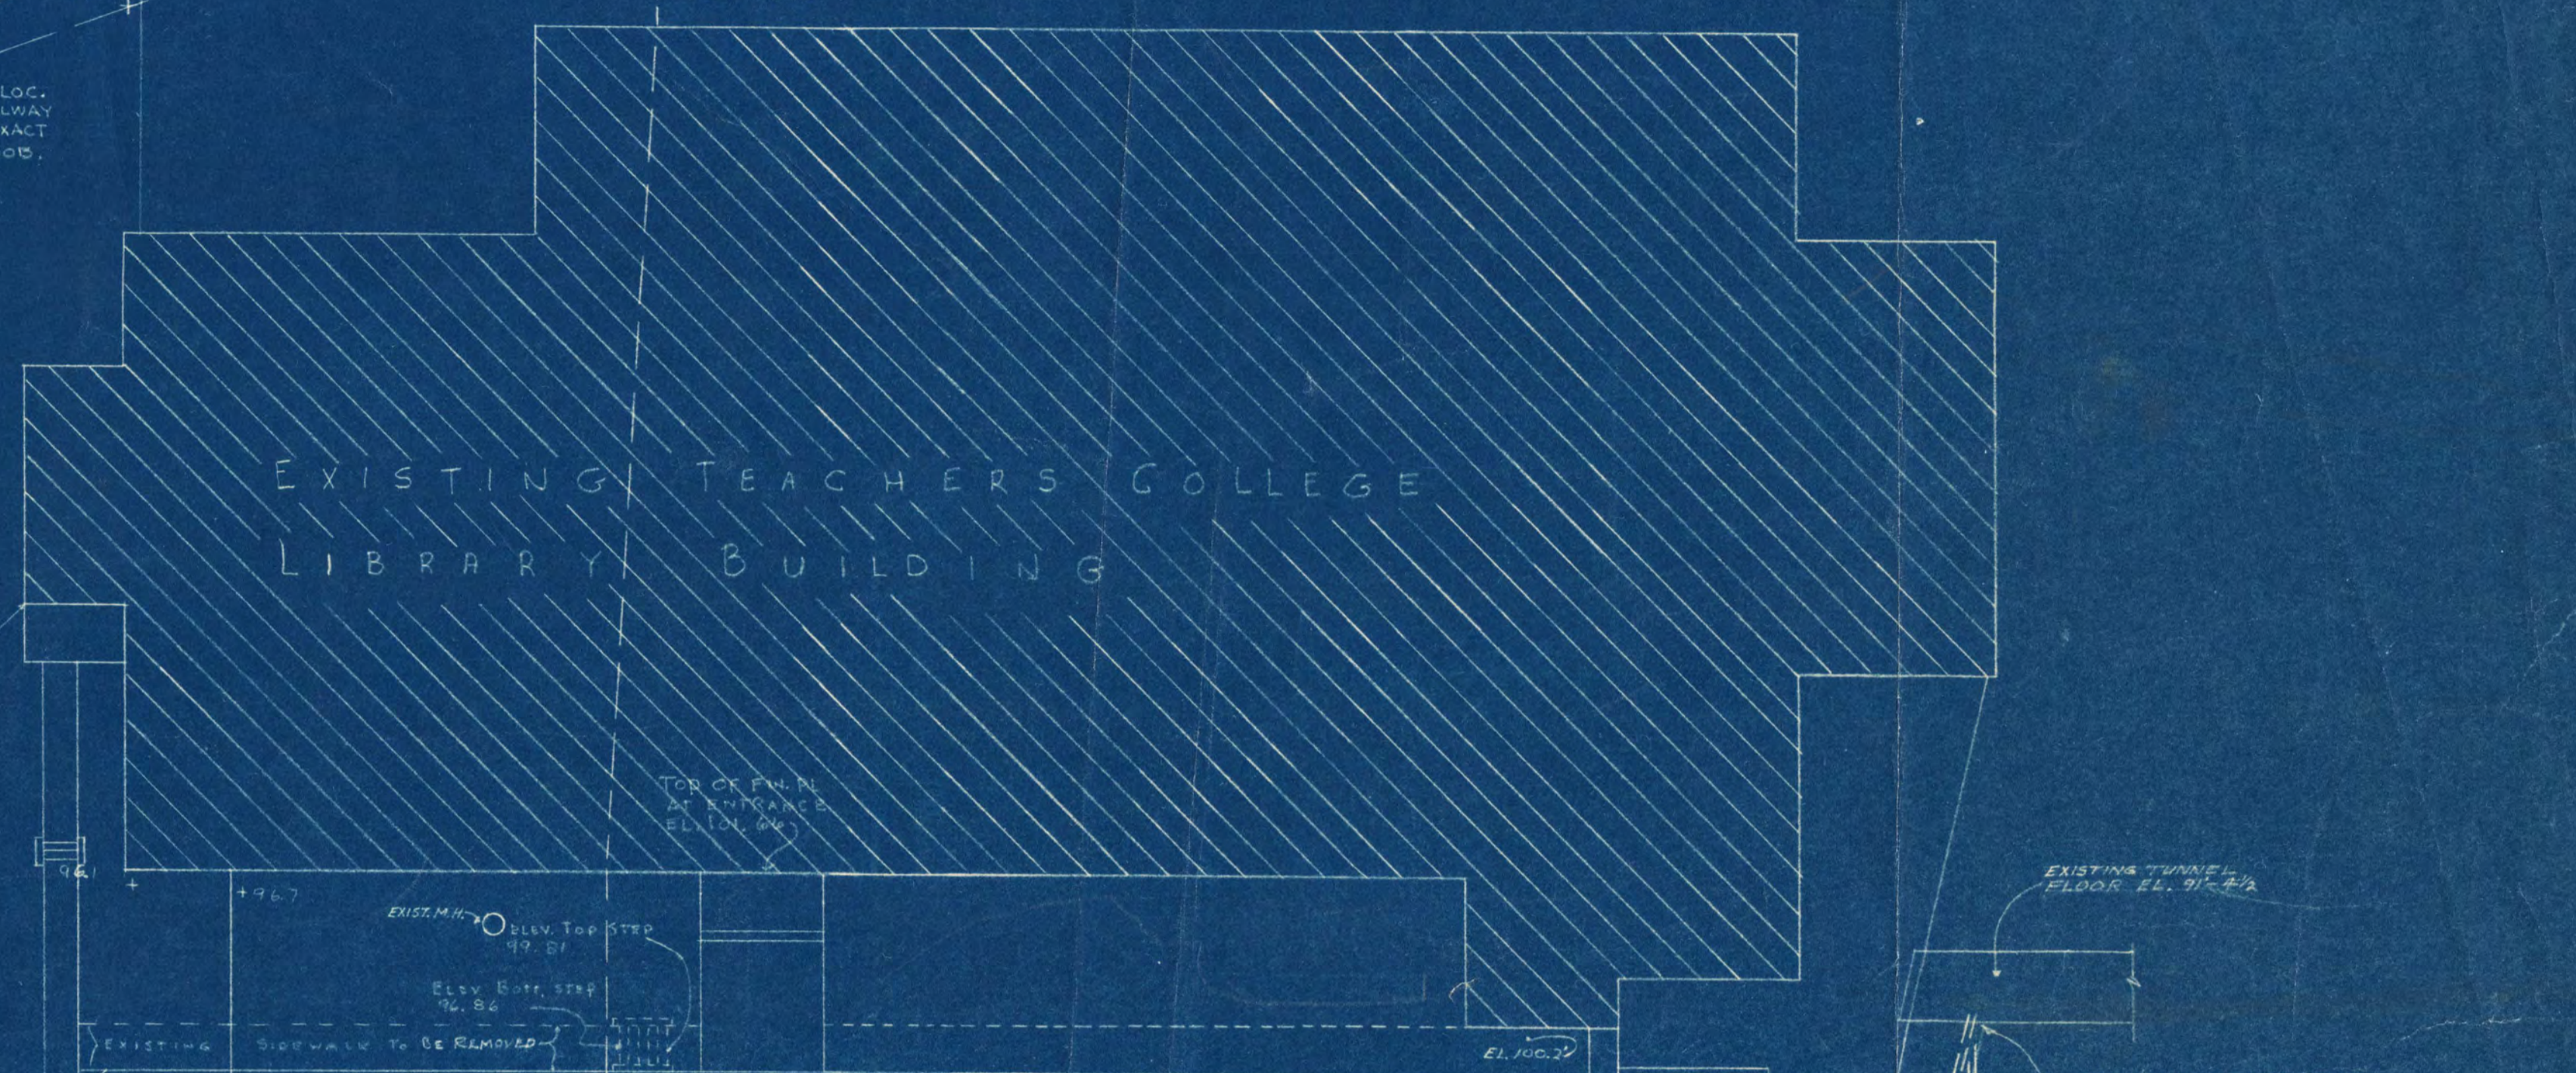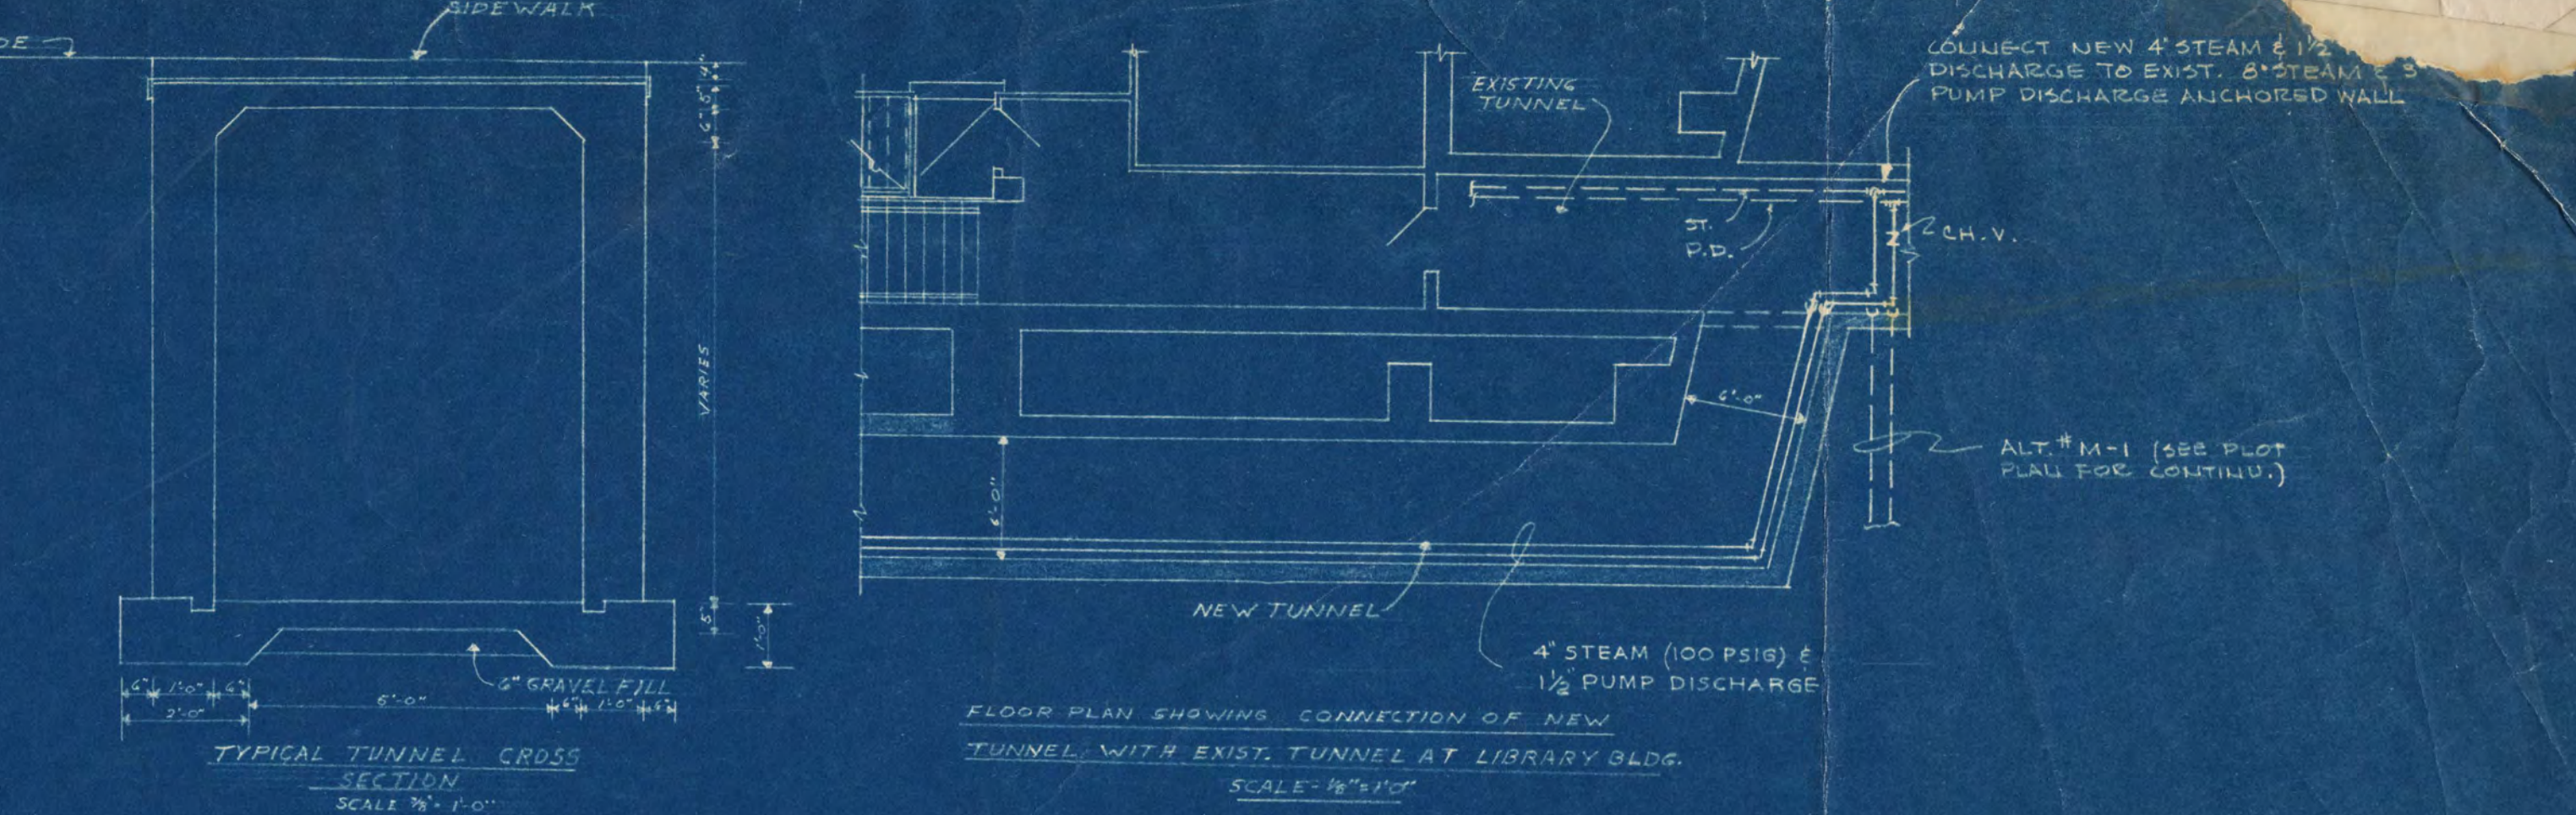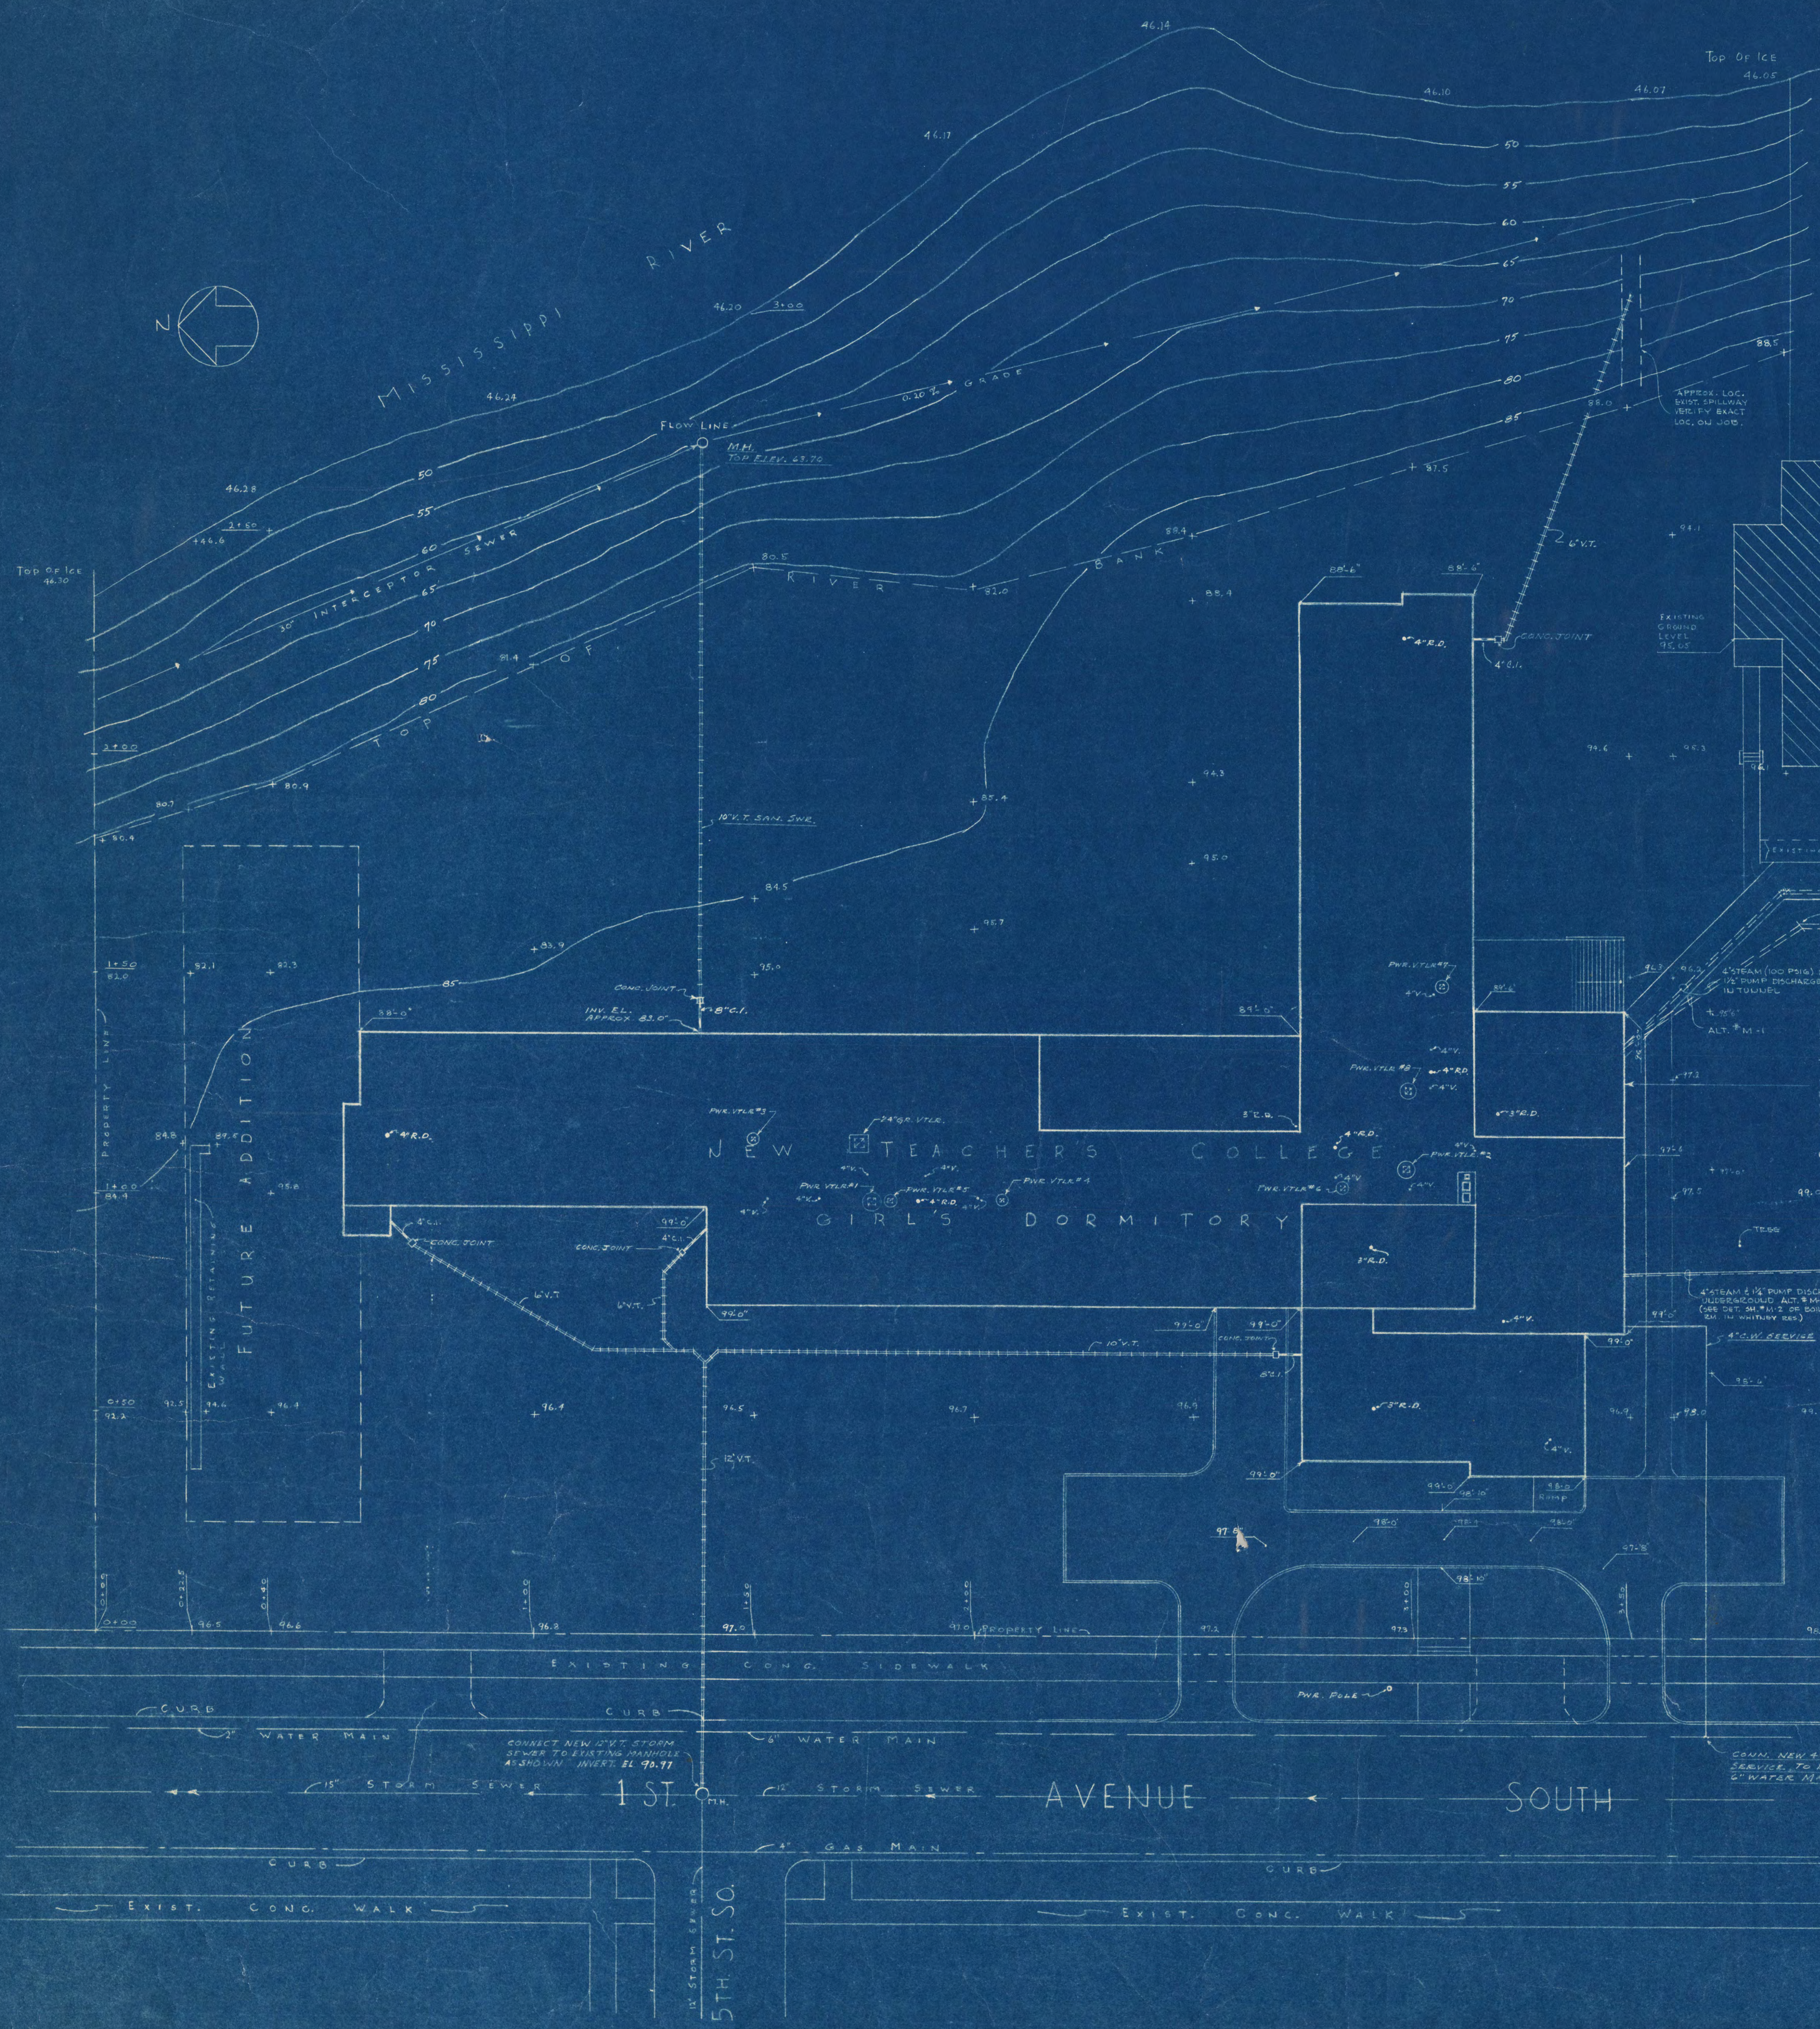

COLLECT NEW 4" STEAM & 1/2" PUMP DISCHARGE TO EXIST. 8" STEAM & 1/2" PUMP DISCHARGE ANCHORED WALL

ALT. # M-1 (SEE PLAN FOR VERTICAL)

NEW TUNNEL

4" STEAM (50 PSIG) & 1/2" PUMP DISCHARGE

FLOOR PLAN SHOWING CONNECTION OF NEW TUNNEL WITH EXIST. TUNNEL AT LIBRARY BLDG. SCALE 1/4" = 1'-0"

EXISTING TUNNEL ELEV. 94.29

SEE LARGER SCALE DETAIL OF CONNECTIONS ON THIS SHEET

ANCHOR, 4" STEAM & 1/2" PUMP DISCH.

ALT. # M-1

UNDER ALT. # M-1

EXPANSION JOINTS

1/2" WELDED ON FOR STEELWORK

4" WELDED ON FOR STEELWORK

1/2" P.D.

TOP VIEW

MANHOLE DETAIL & EXPANSION JOINTS FOR HEATING MAINS

SCALE 1/4" = 1'-0"

1. 1/2" & 1/4" O.D. REINFORCED STEEL ALL SIDES
2. 1'-0" HIGH BASE FOR EXPANSION JOINTS
3. DEPTH OF MANHOLE TO BE DETECTED BY DEPTH OF TUNNEL
4. 24" MANHOLE RINGS & COVERS - CAST IRON

Girls Dormitory St. Cloud State Teachers College St. Cloud - Minnesota		
CONTR. NO.	FRANK W. JACKSON & ASSOCIATES, INC. ARCHITECTS - MINNEAPOLIS, MINN.	DATE
45-16	51-10-11-11	M-1
DESIGN BY	G. M. ORR ENGINEERS CO. MINNEAPOLIS, MINN.	OF
7-14		6
SHEET	2-15-56	
DATE	6-15-56	
REG. NO.	7977	

I hereby certify that this plan, specification, or report was prepared by me or under my direct supervision and that I am a duly registered Professional Engineer under the laws of the State of Minnesota.

*G. M. Orr*

DATE: 6-15-56 Reg. No. 7977