



FOUNDATION & TUNNEL PLAN
SCALE 1/8" = 1'-0"

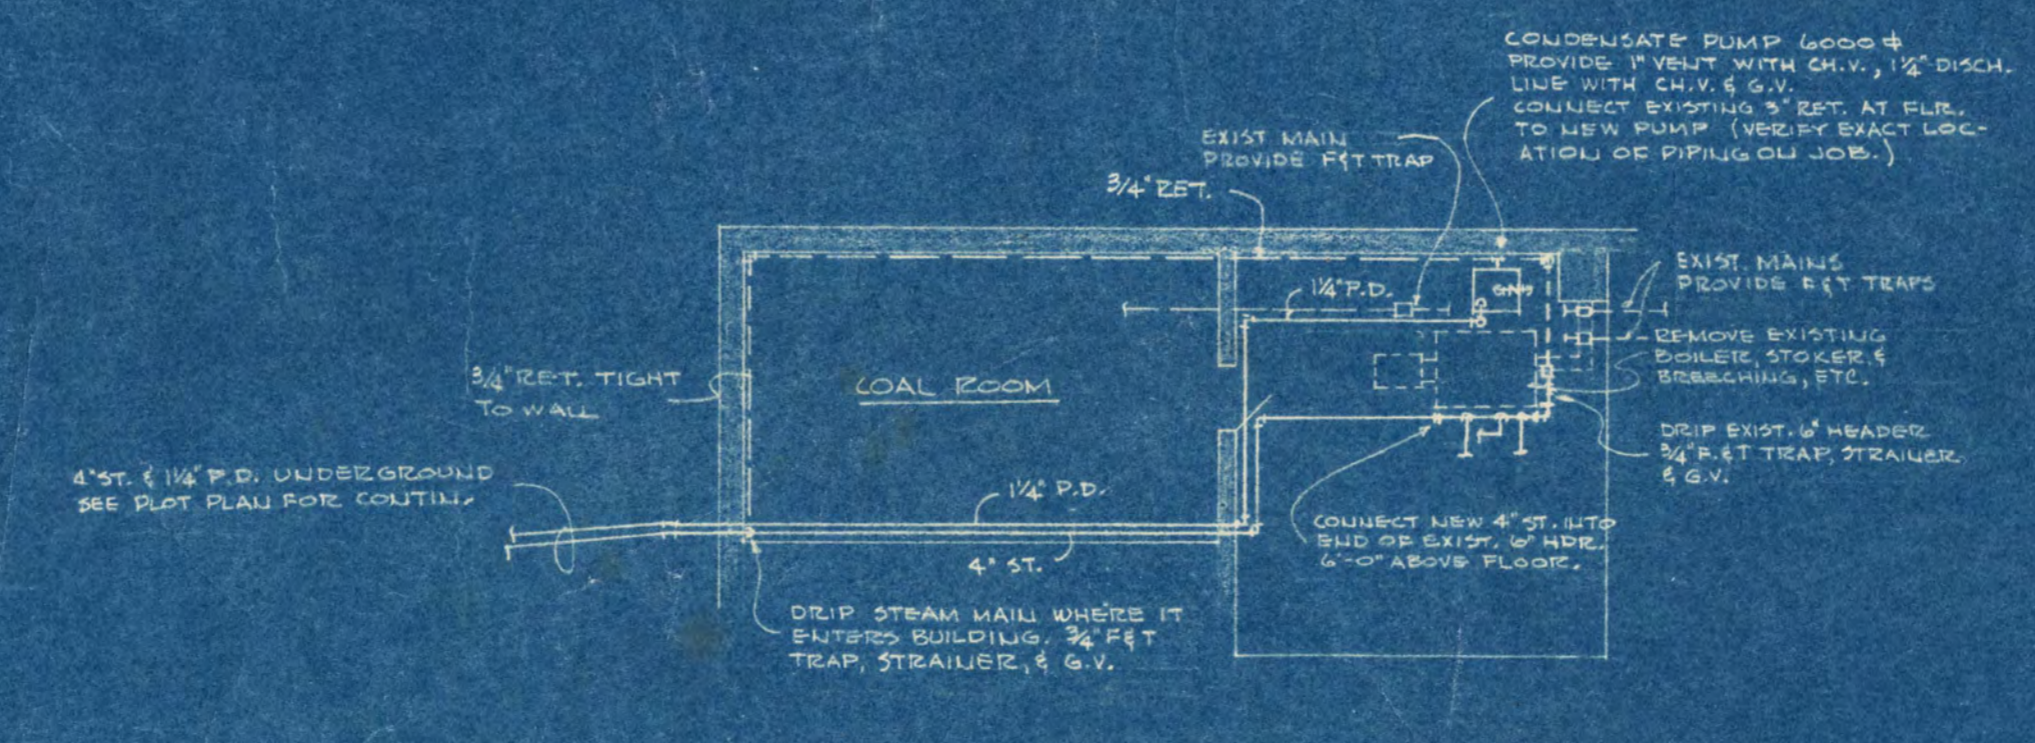


LAYOUT OF COAL & BOILER ROOMS IN
WHITNEY RESIDENCE
SCALE 1/8" = 1'-0"
VERIFY ALL LOCATIONS ON JOB


GIRL'S DORMITORY ST. CLOUD STATE TEACHERS COLLEGE ST. CLOUD MINNESOTA			
CONTRACT NO.	PROJ. NO.	DATE	SCALE
4-50-16	100-100	10/1/21	M-2
DESIGNED BY	ENGINEER	CHECKED BY	DATE
B. M. ORR ENGINEERING CO.	B. M. ORR	J. M. ORR	10/1/21
MINNEAPOLIS, MINN.	ST. CLOUD, MINN.	ST. CLOUD, MINN.	
APPROVED BY: <i>[Signature]</i>			
APPROVED BY: <i>[Signature]</i>			
APPROVED BY: <i>[Signature]</i>			

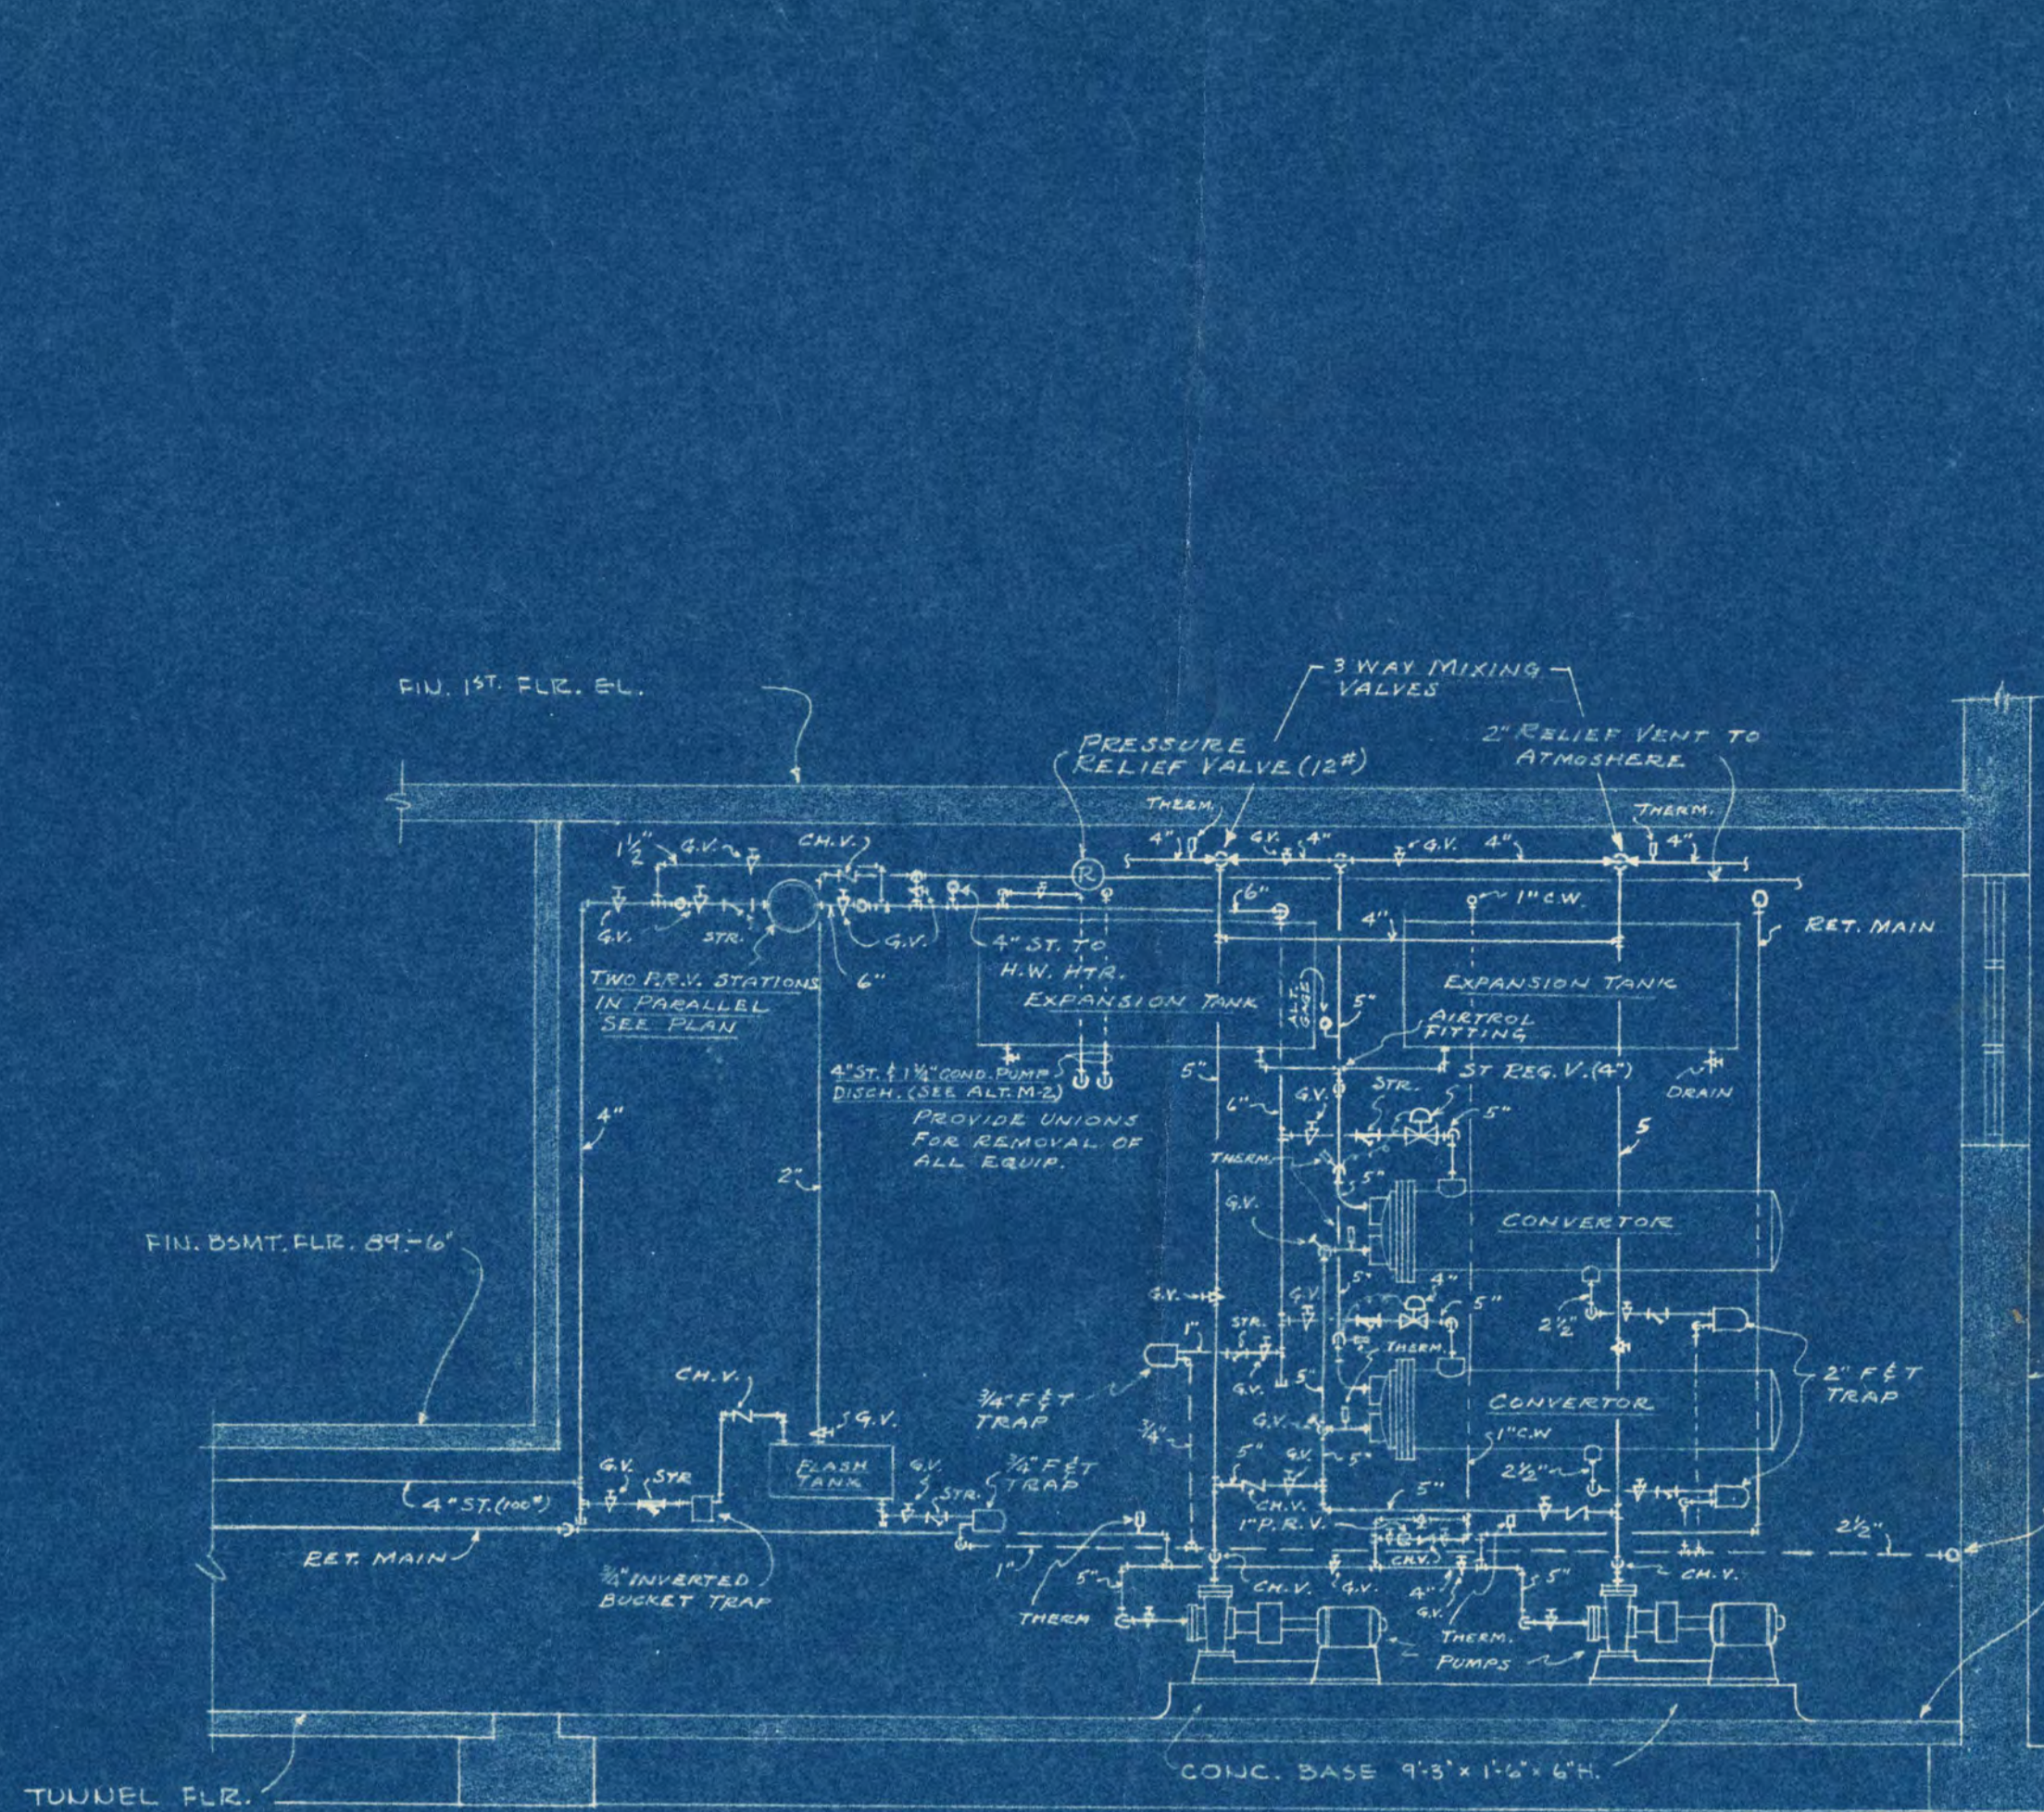


CONVERTER PIPING DETAIL
SCALE: 3/8" = 1'-0"

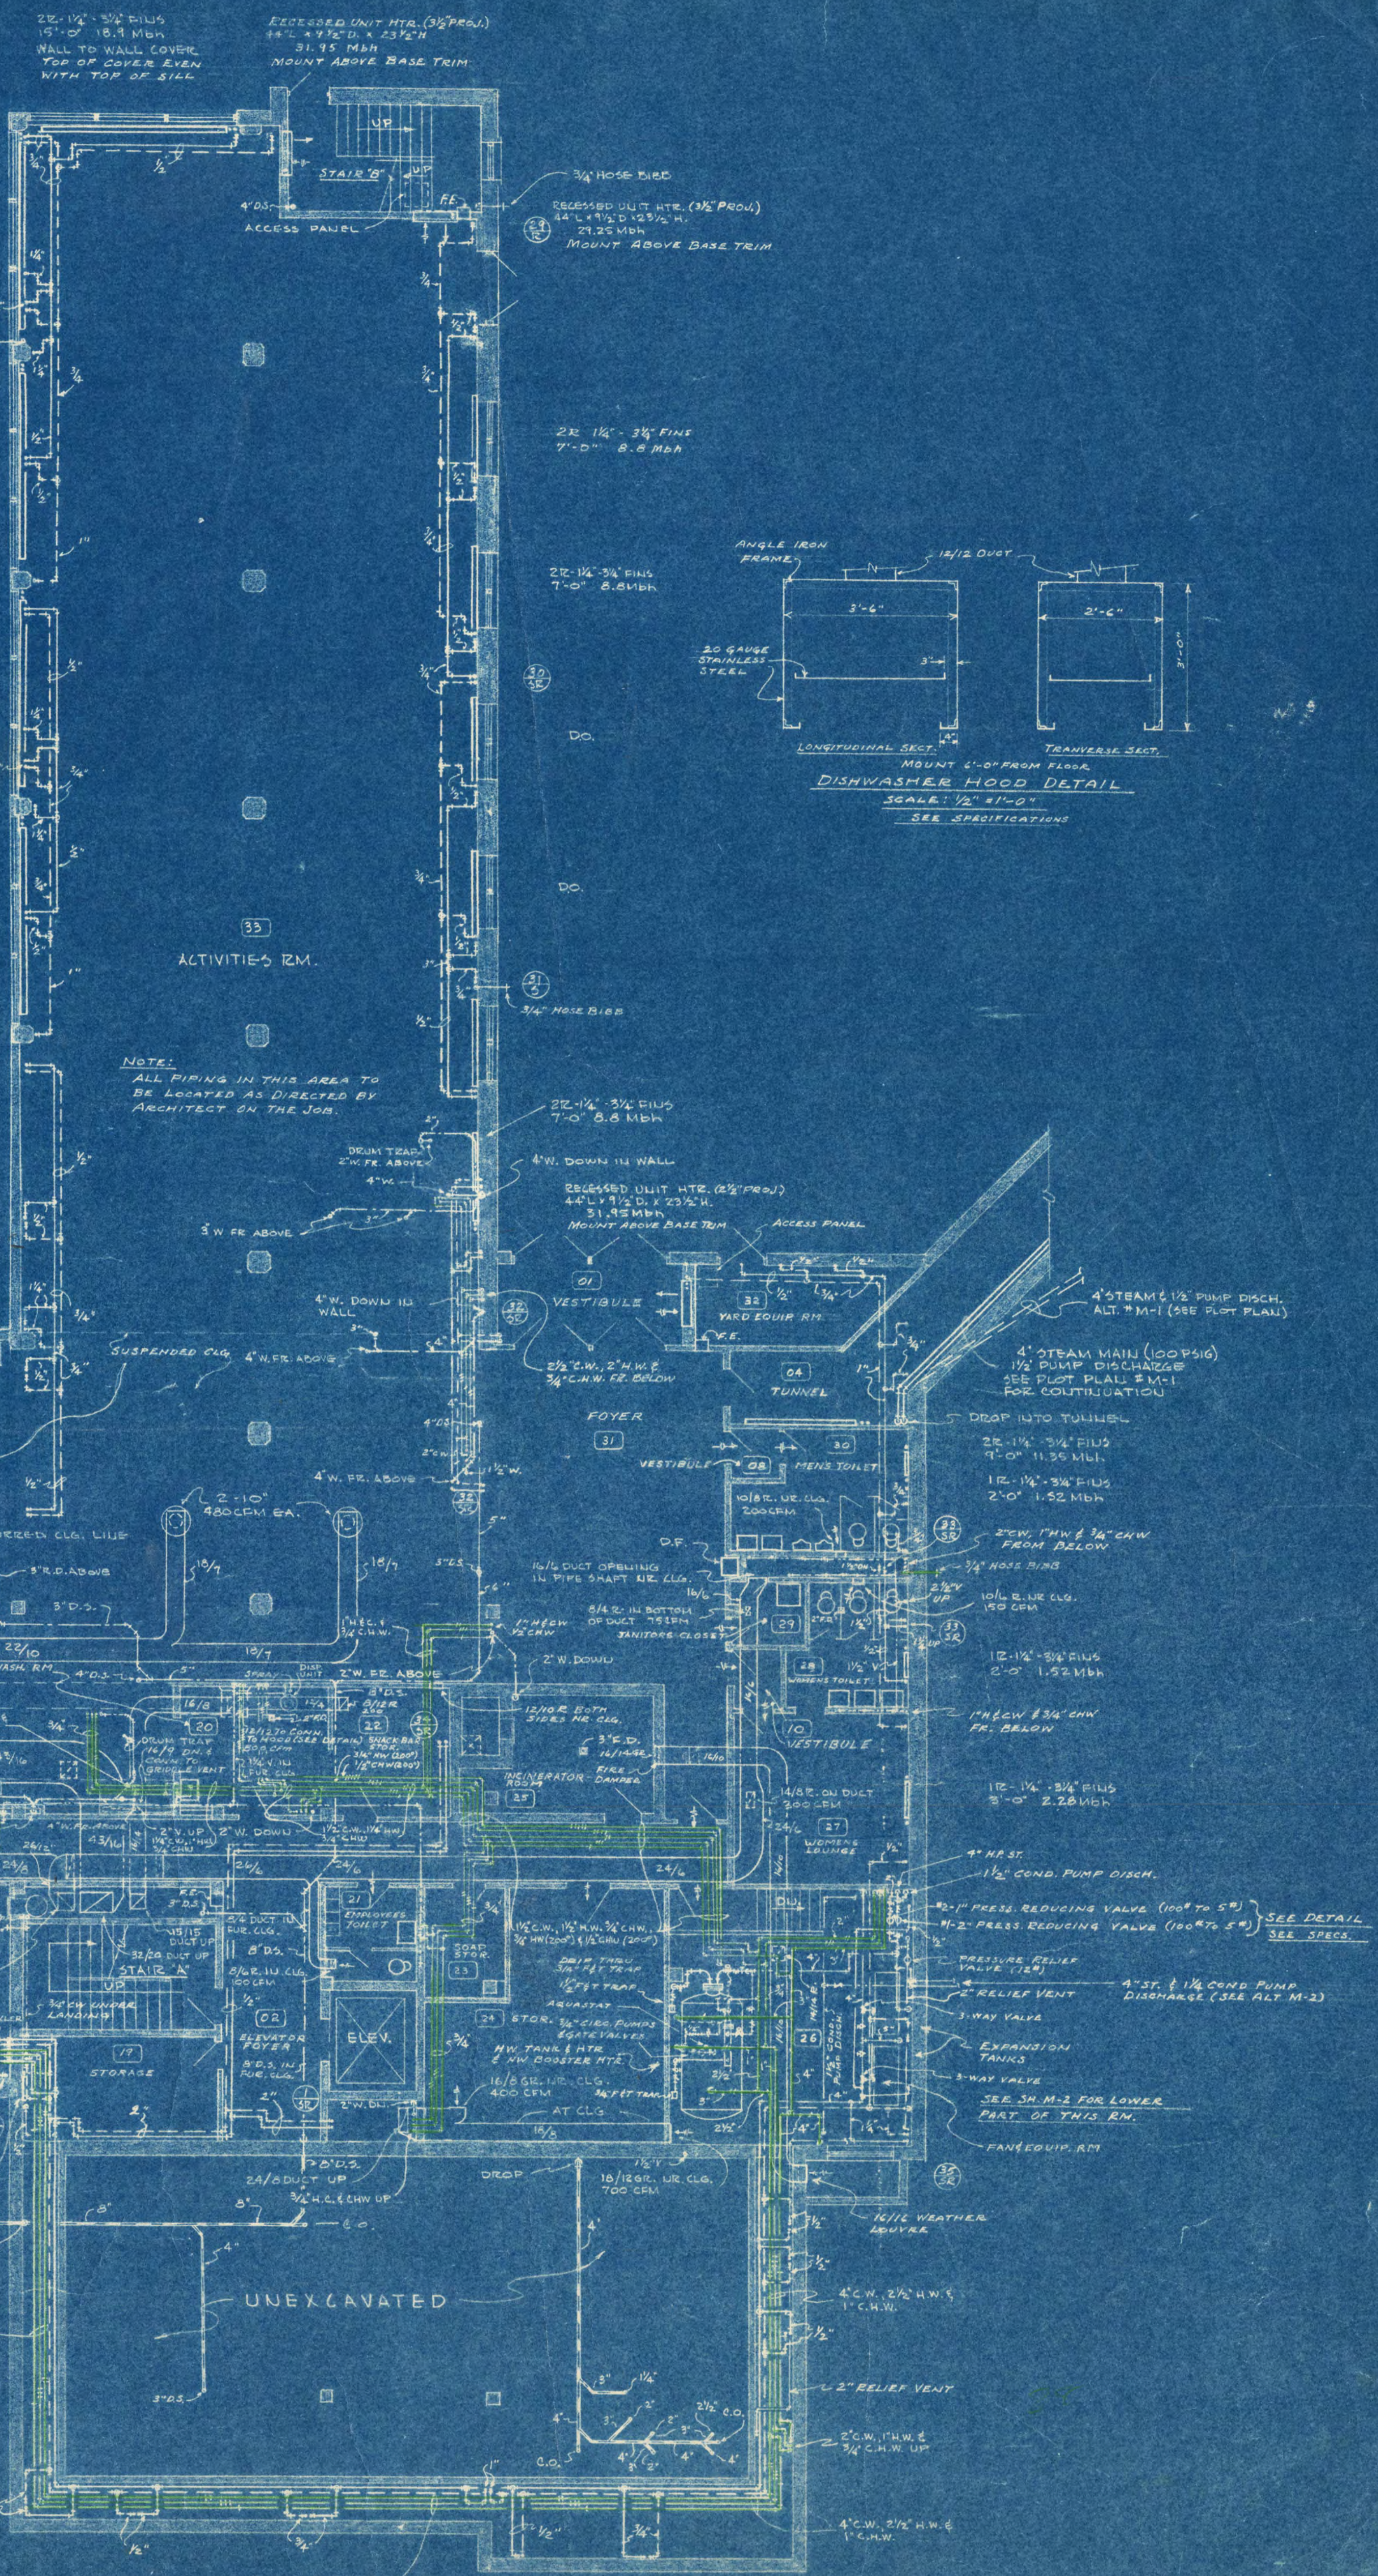

BASEMENT FLOOR PLAN
SCALE: 1/8" = 1'-0"

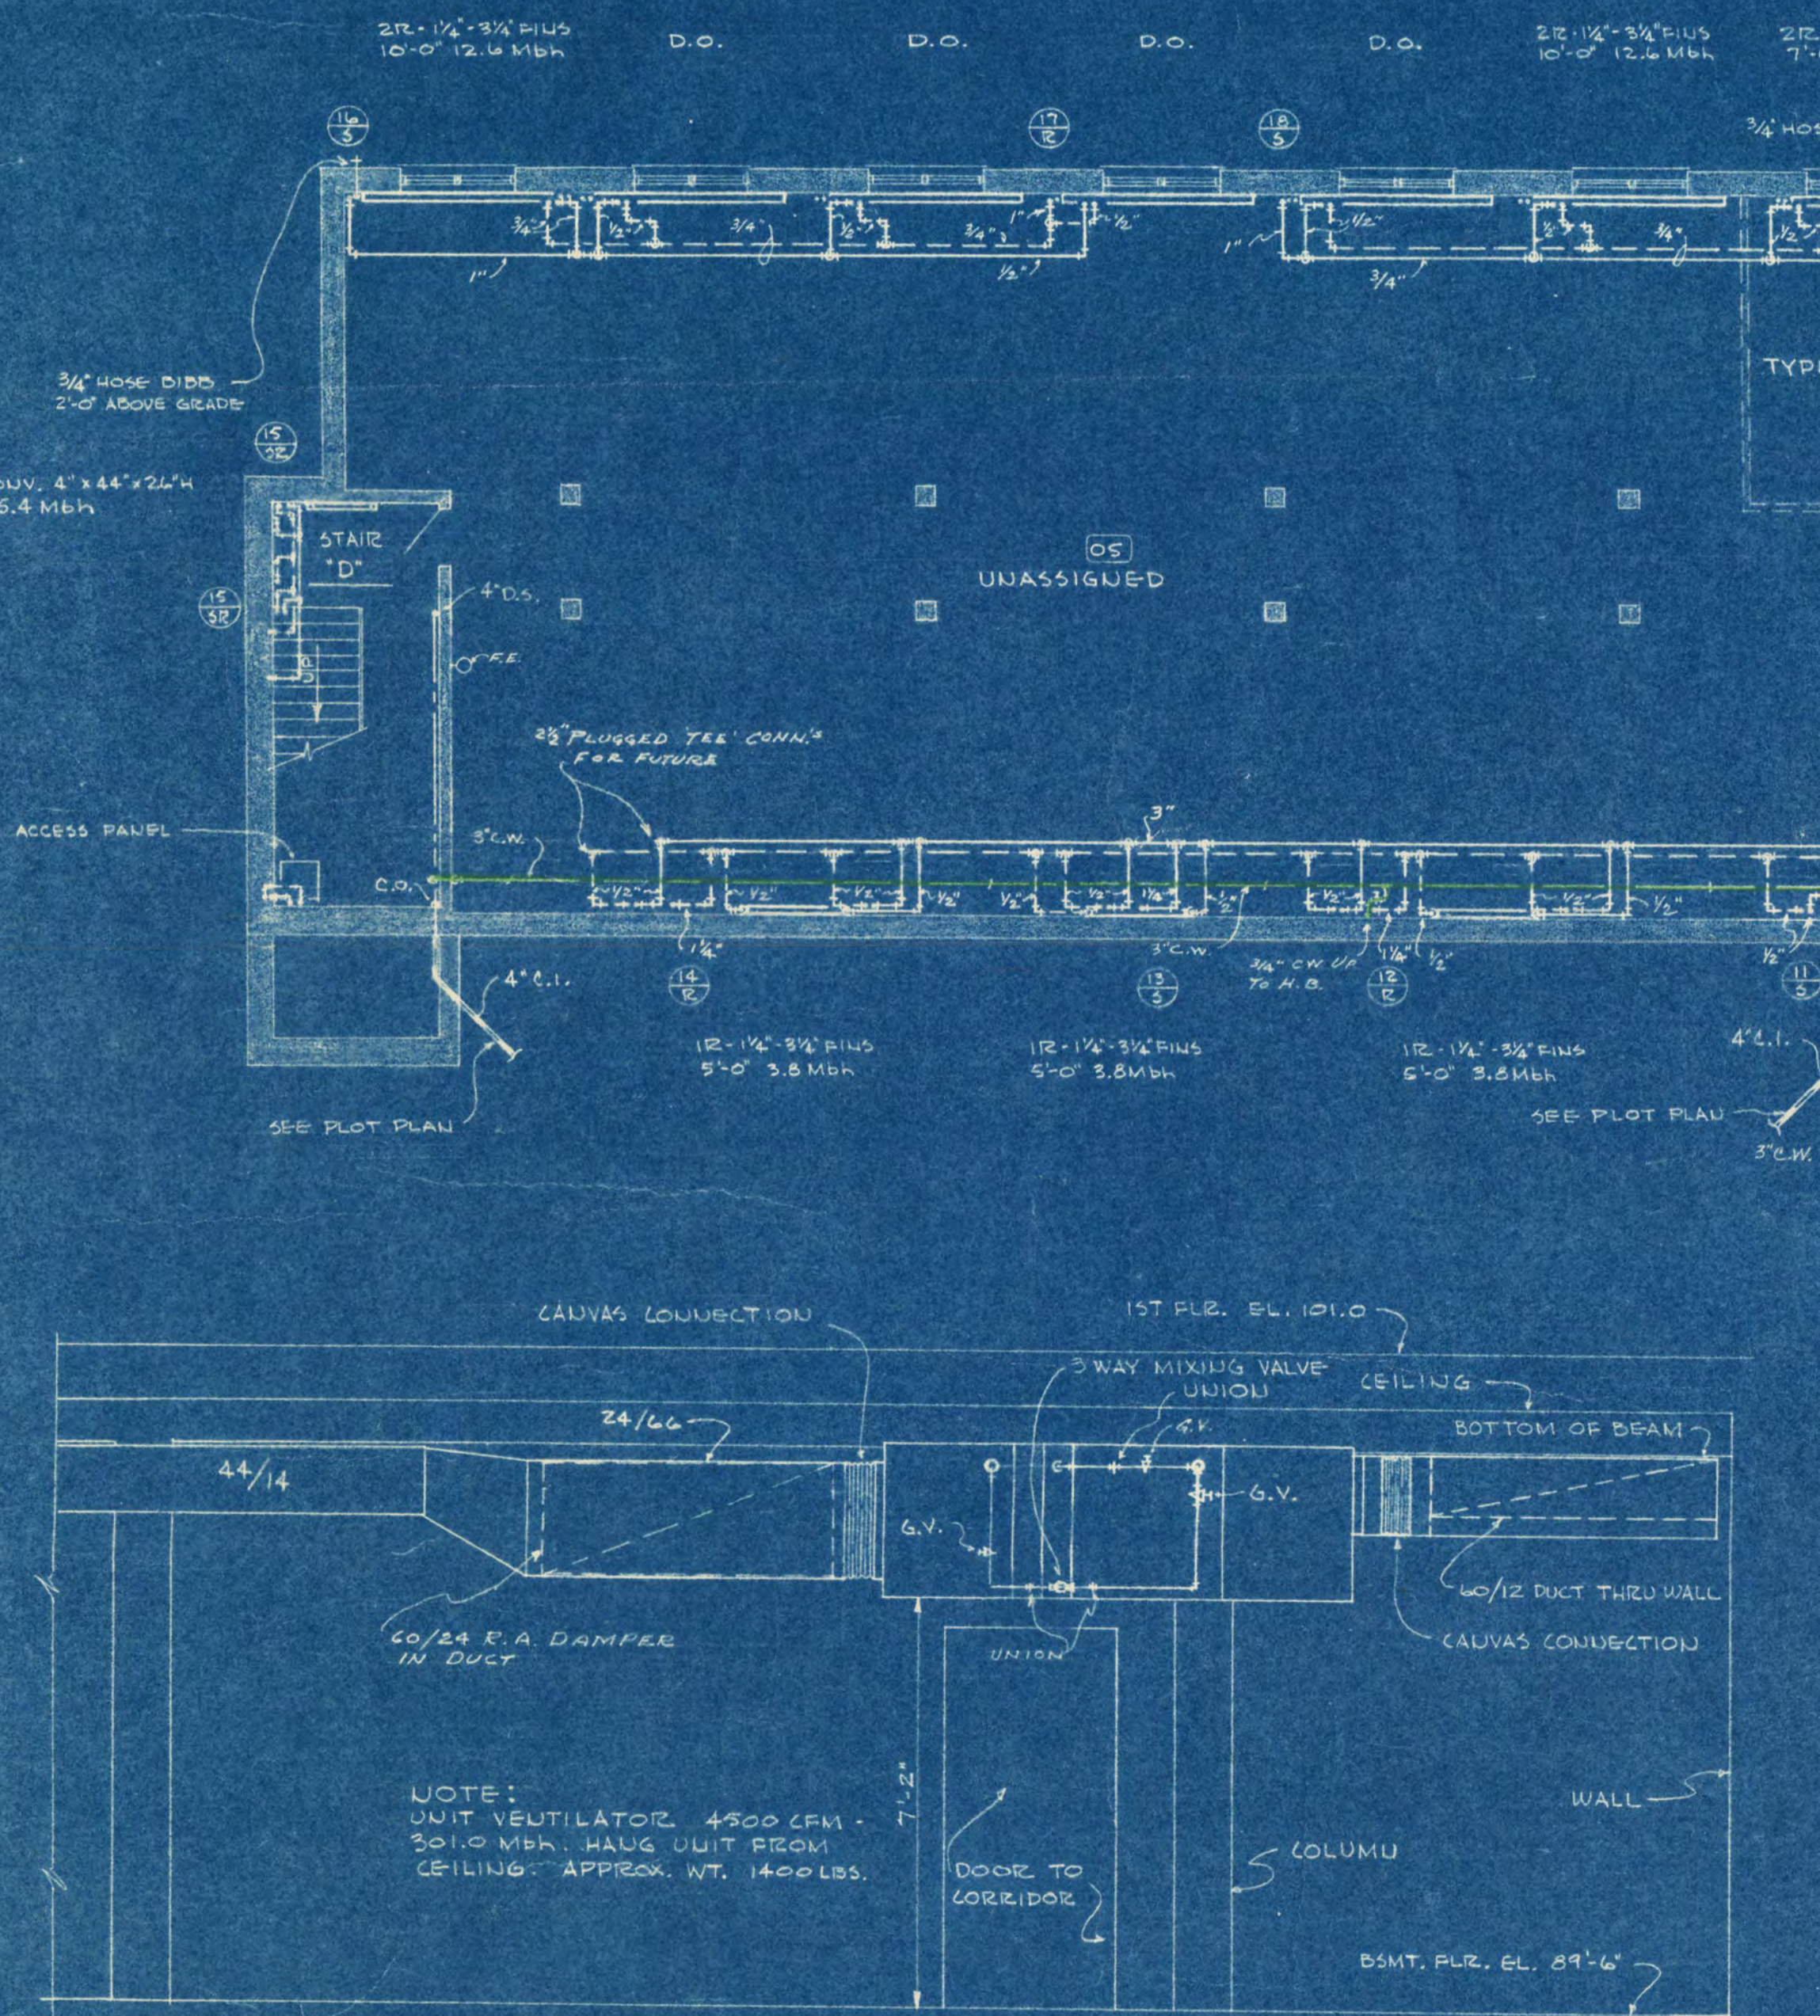



DETAIL OF UNIT VENTILATOR FOR TELEVISION & ACTIVITIES ROOMS
SCALE: 3/8" = 1'-0"

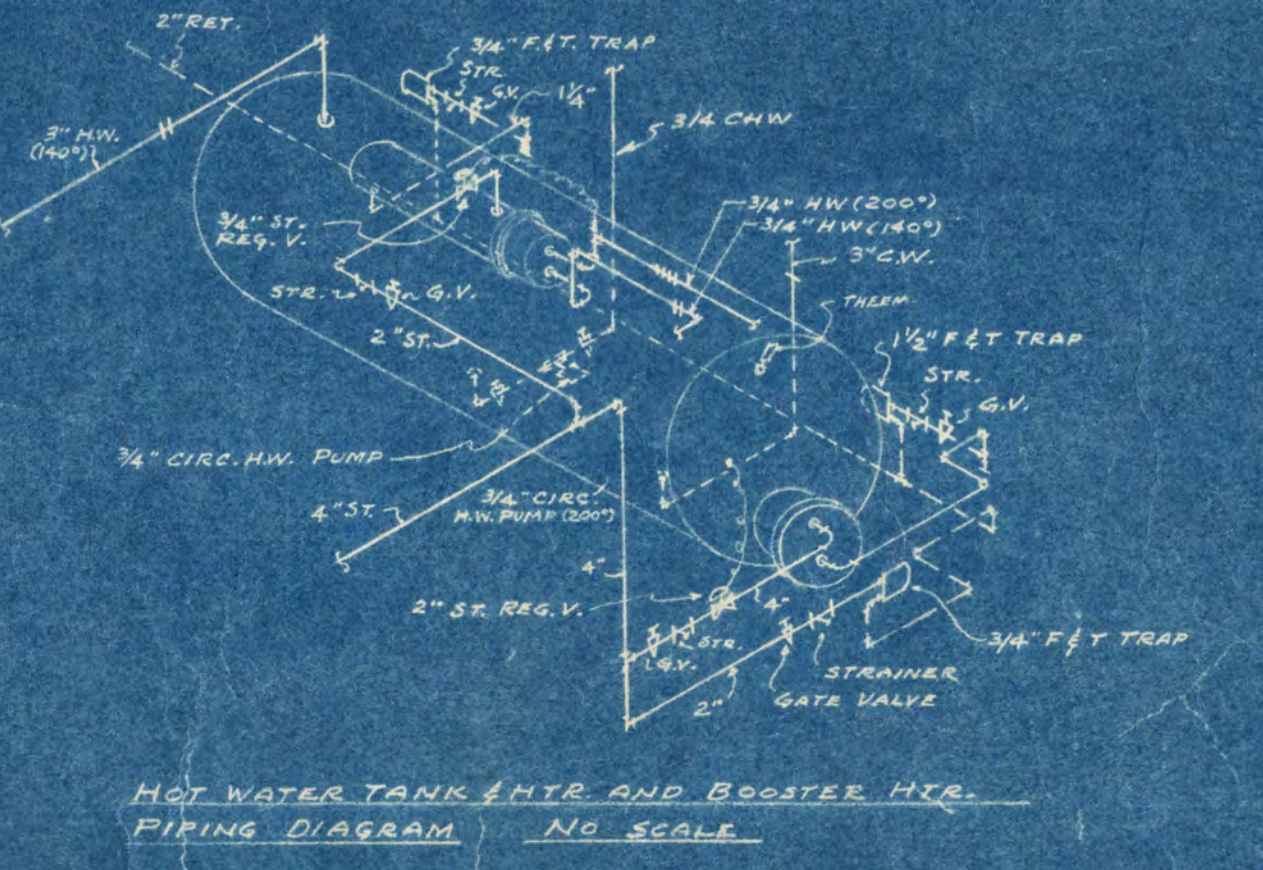



HOT WATER TANK AND BOOSTER PUMP PIPING DIAGRAM
NO SCALE

GIRL'S DORMITORY ST. CLOUD STATE TEACHERS COLLEGE ST. CLOUD, MINNESOTA			
DATE: 4-15-22	PROJECT: GIRL'S DORMITORY	DESIGNED BY: F. M. ORR ENGINEERING CO.	DRAWN BY: M. J. JACKSON & ASSOCIATES, INC.
SCALE: 1/8" = 1'-0"	NO. OF SHEETS: 6	SHEET NO.: 6	PROJECT NO.: M-3

SOIL, WASTE, & VENT RISER DIAGRAMS
NO SCALE

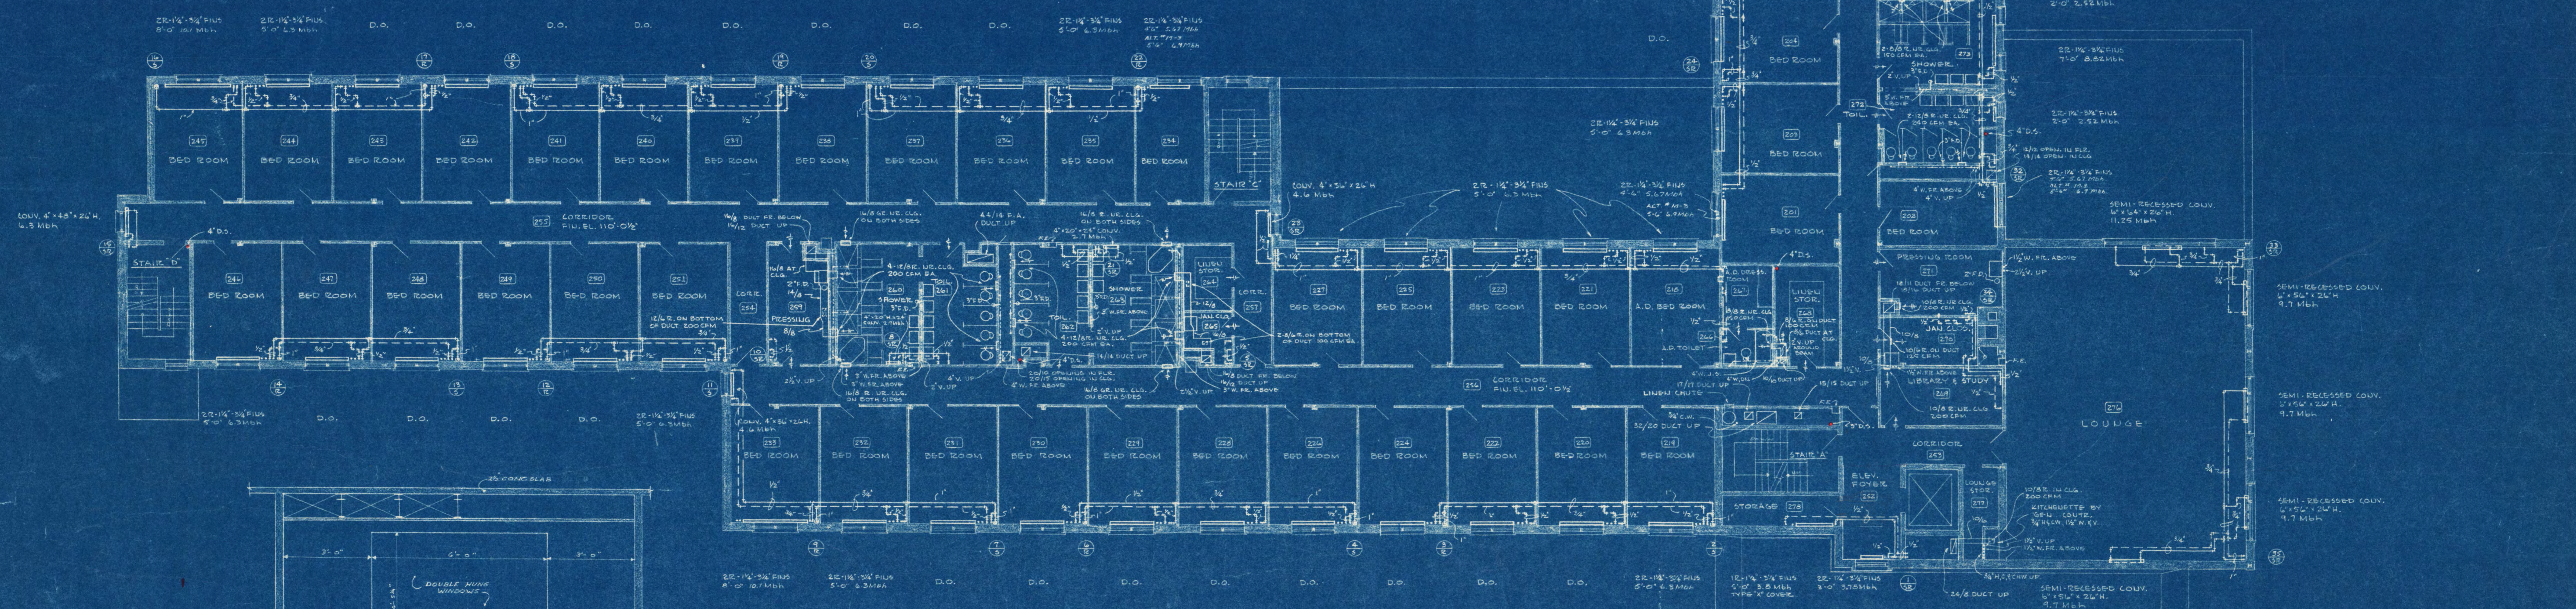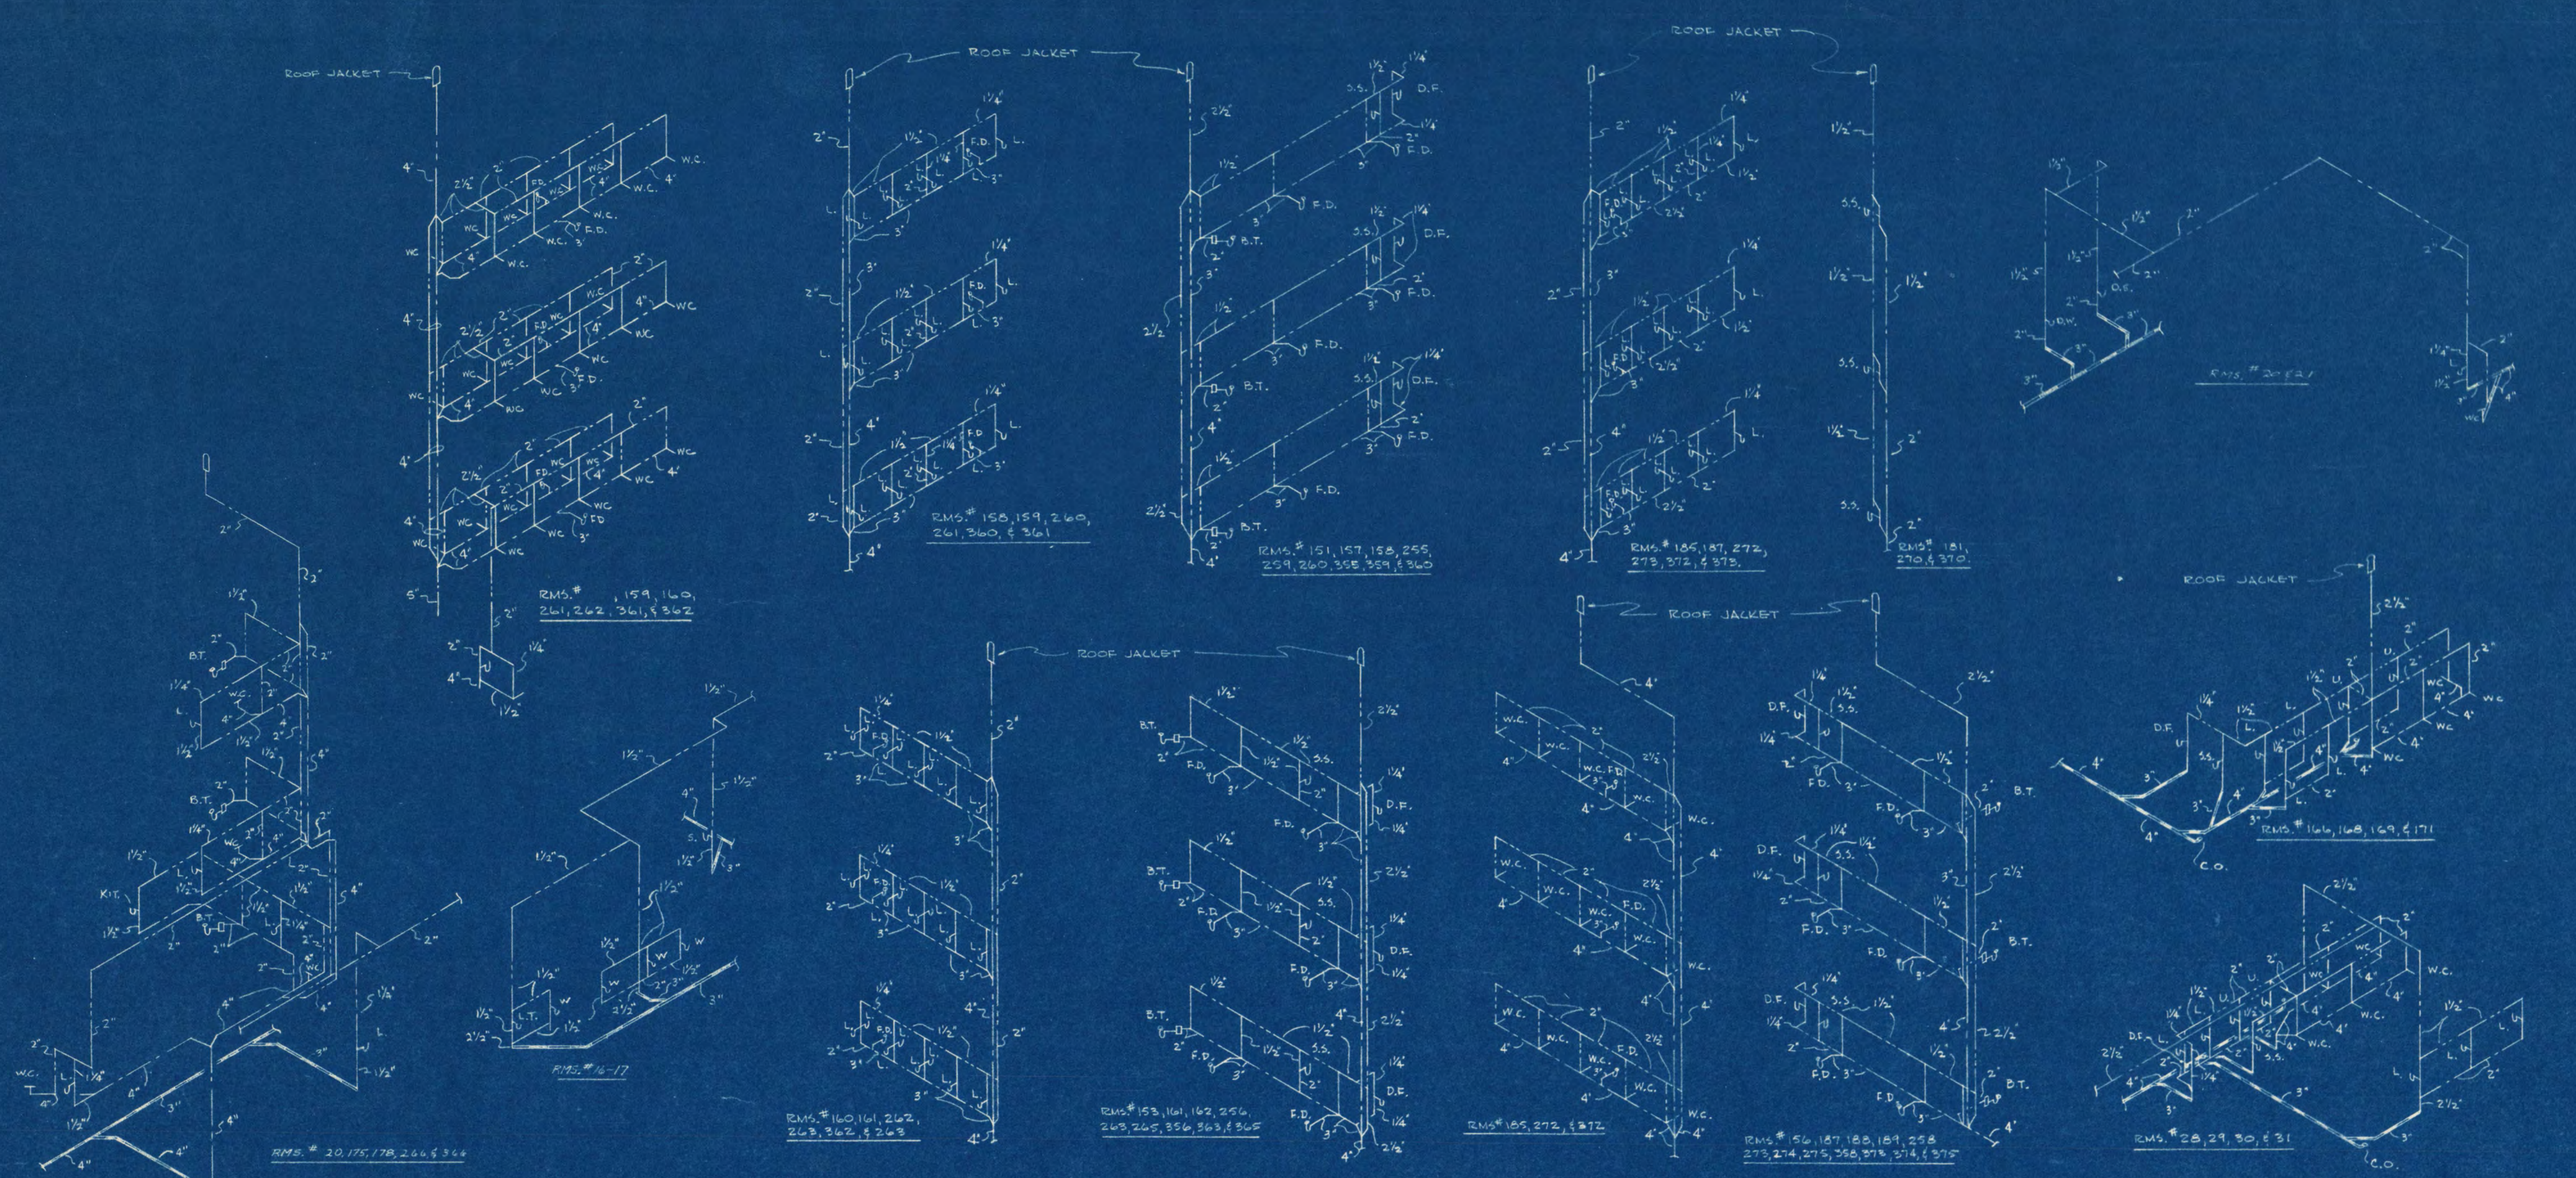


SECOND FLOOR PLAN
SCALE 1/8" = 1'-0"

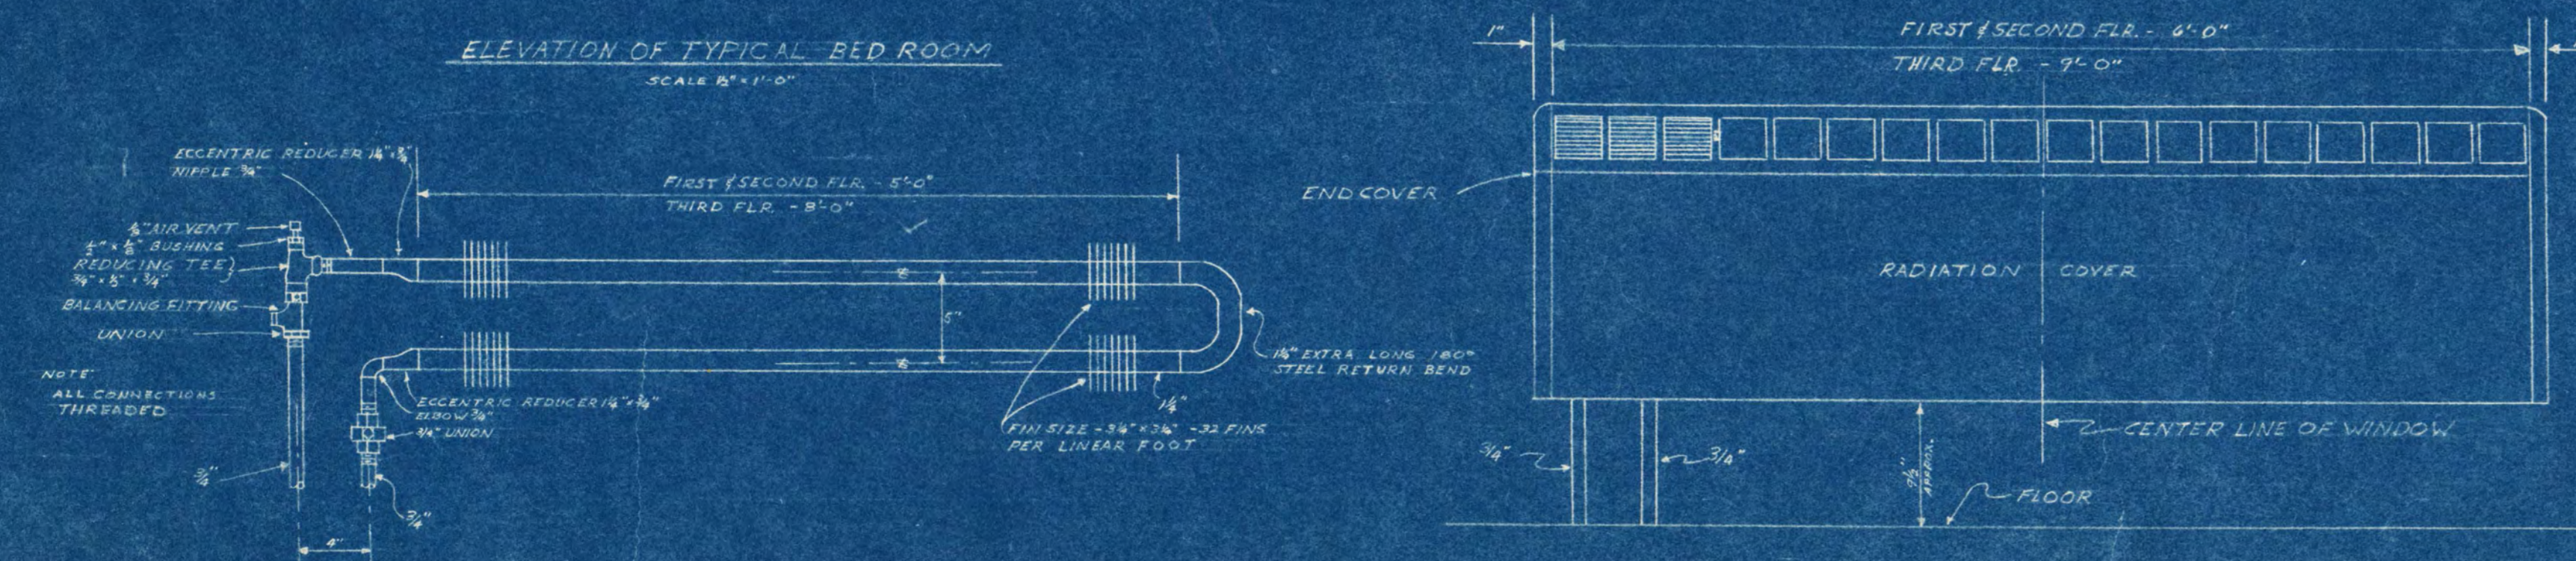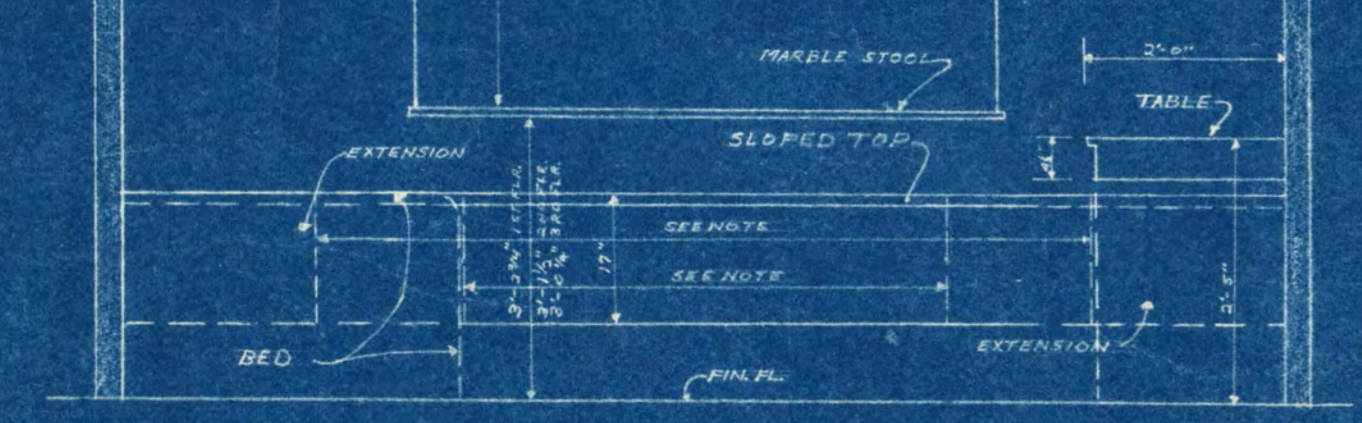




DETAIL OF RADIATION FOR TYPICAL BED ROOMS
SCALE 1/8" = 1'-0"

OTHER ROOMS REQUIRING 2 ROWS OF RADIATION ARE OF SIMILAR HOOD-UP, EXCEPT FOR OVERALL DIMENSION.

GIRL'S DORMITORY		ST. CLOUD STATE TEACHERS COLLEGE		ST. CLOUD, MINNESOTA	
DATE:	1926-27	ARCHITECTS & ENGINEERS:	FRANK W. JACKSON & ASSOCIATES, INC.	MINNEAPOLIS, MINN.	
DESIGNED BY:	B. M. ORR ENGINEERING CO.	MINNEAPOLIS, MINN.			
DATE:	6-12-26	SCALE:	AS SHOWN		
PROJECT:	ST. CLOUD STATE TEACHERS COLLEGE				
NO.:	10	OF:	10		



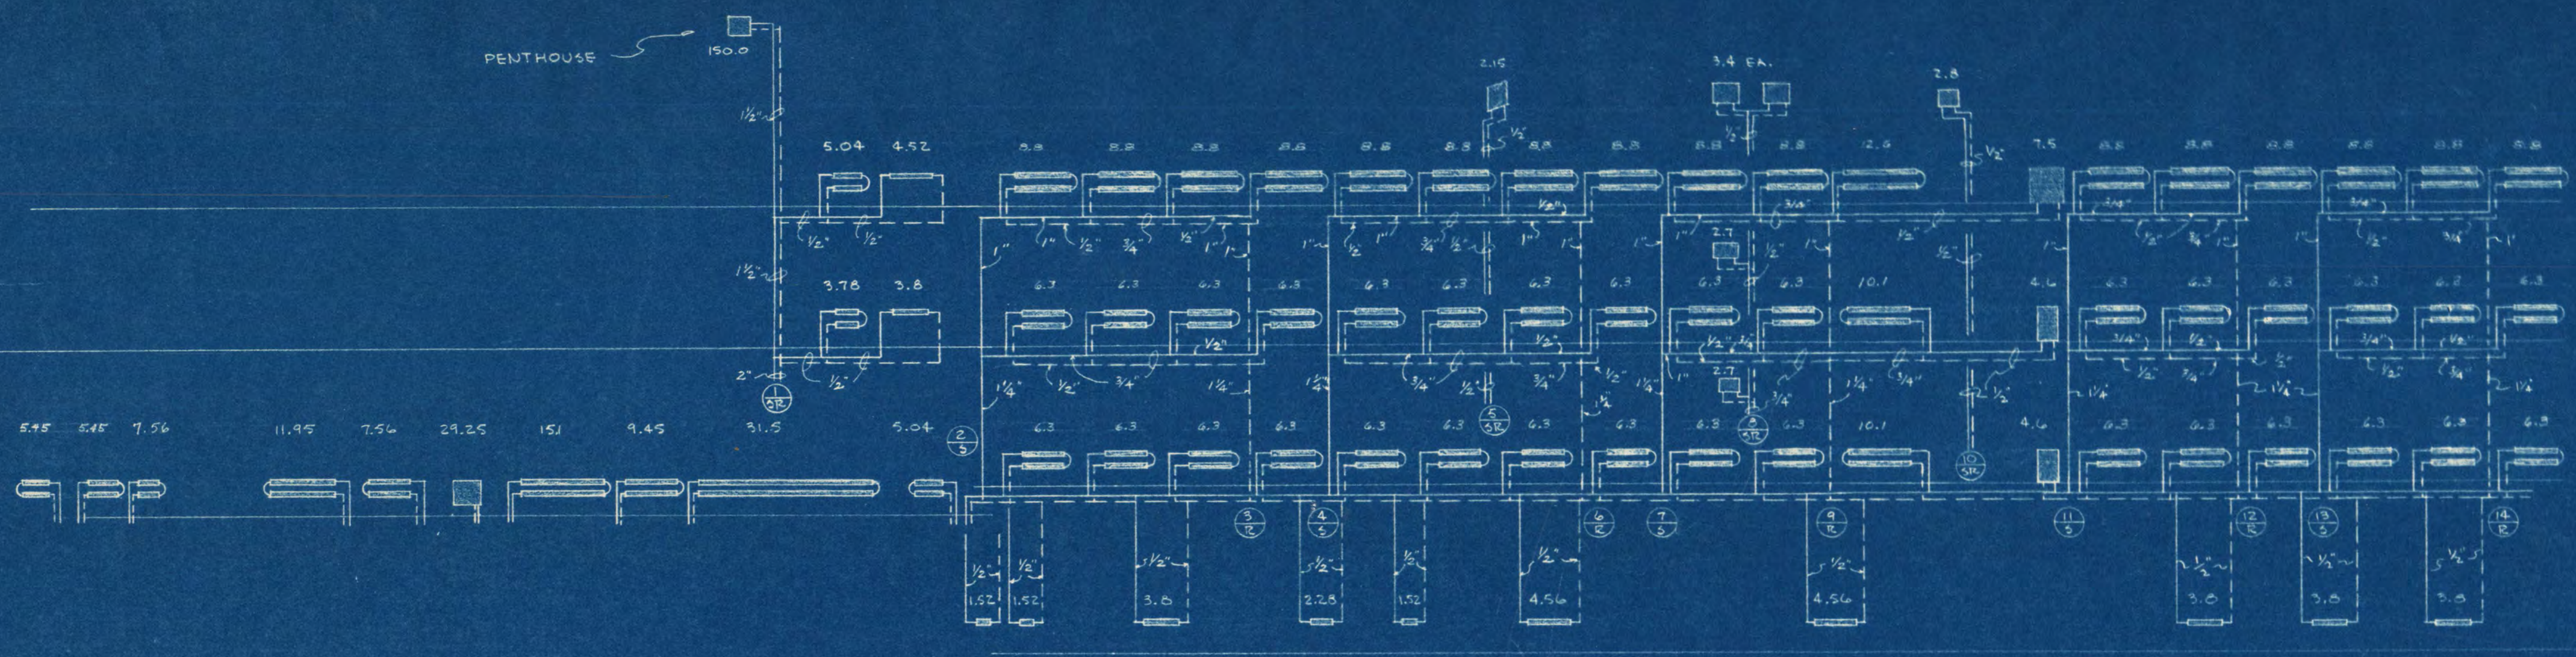


HEATING RISER DIAGRAMS
SCALE 1/8" = 1'-0"

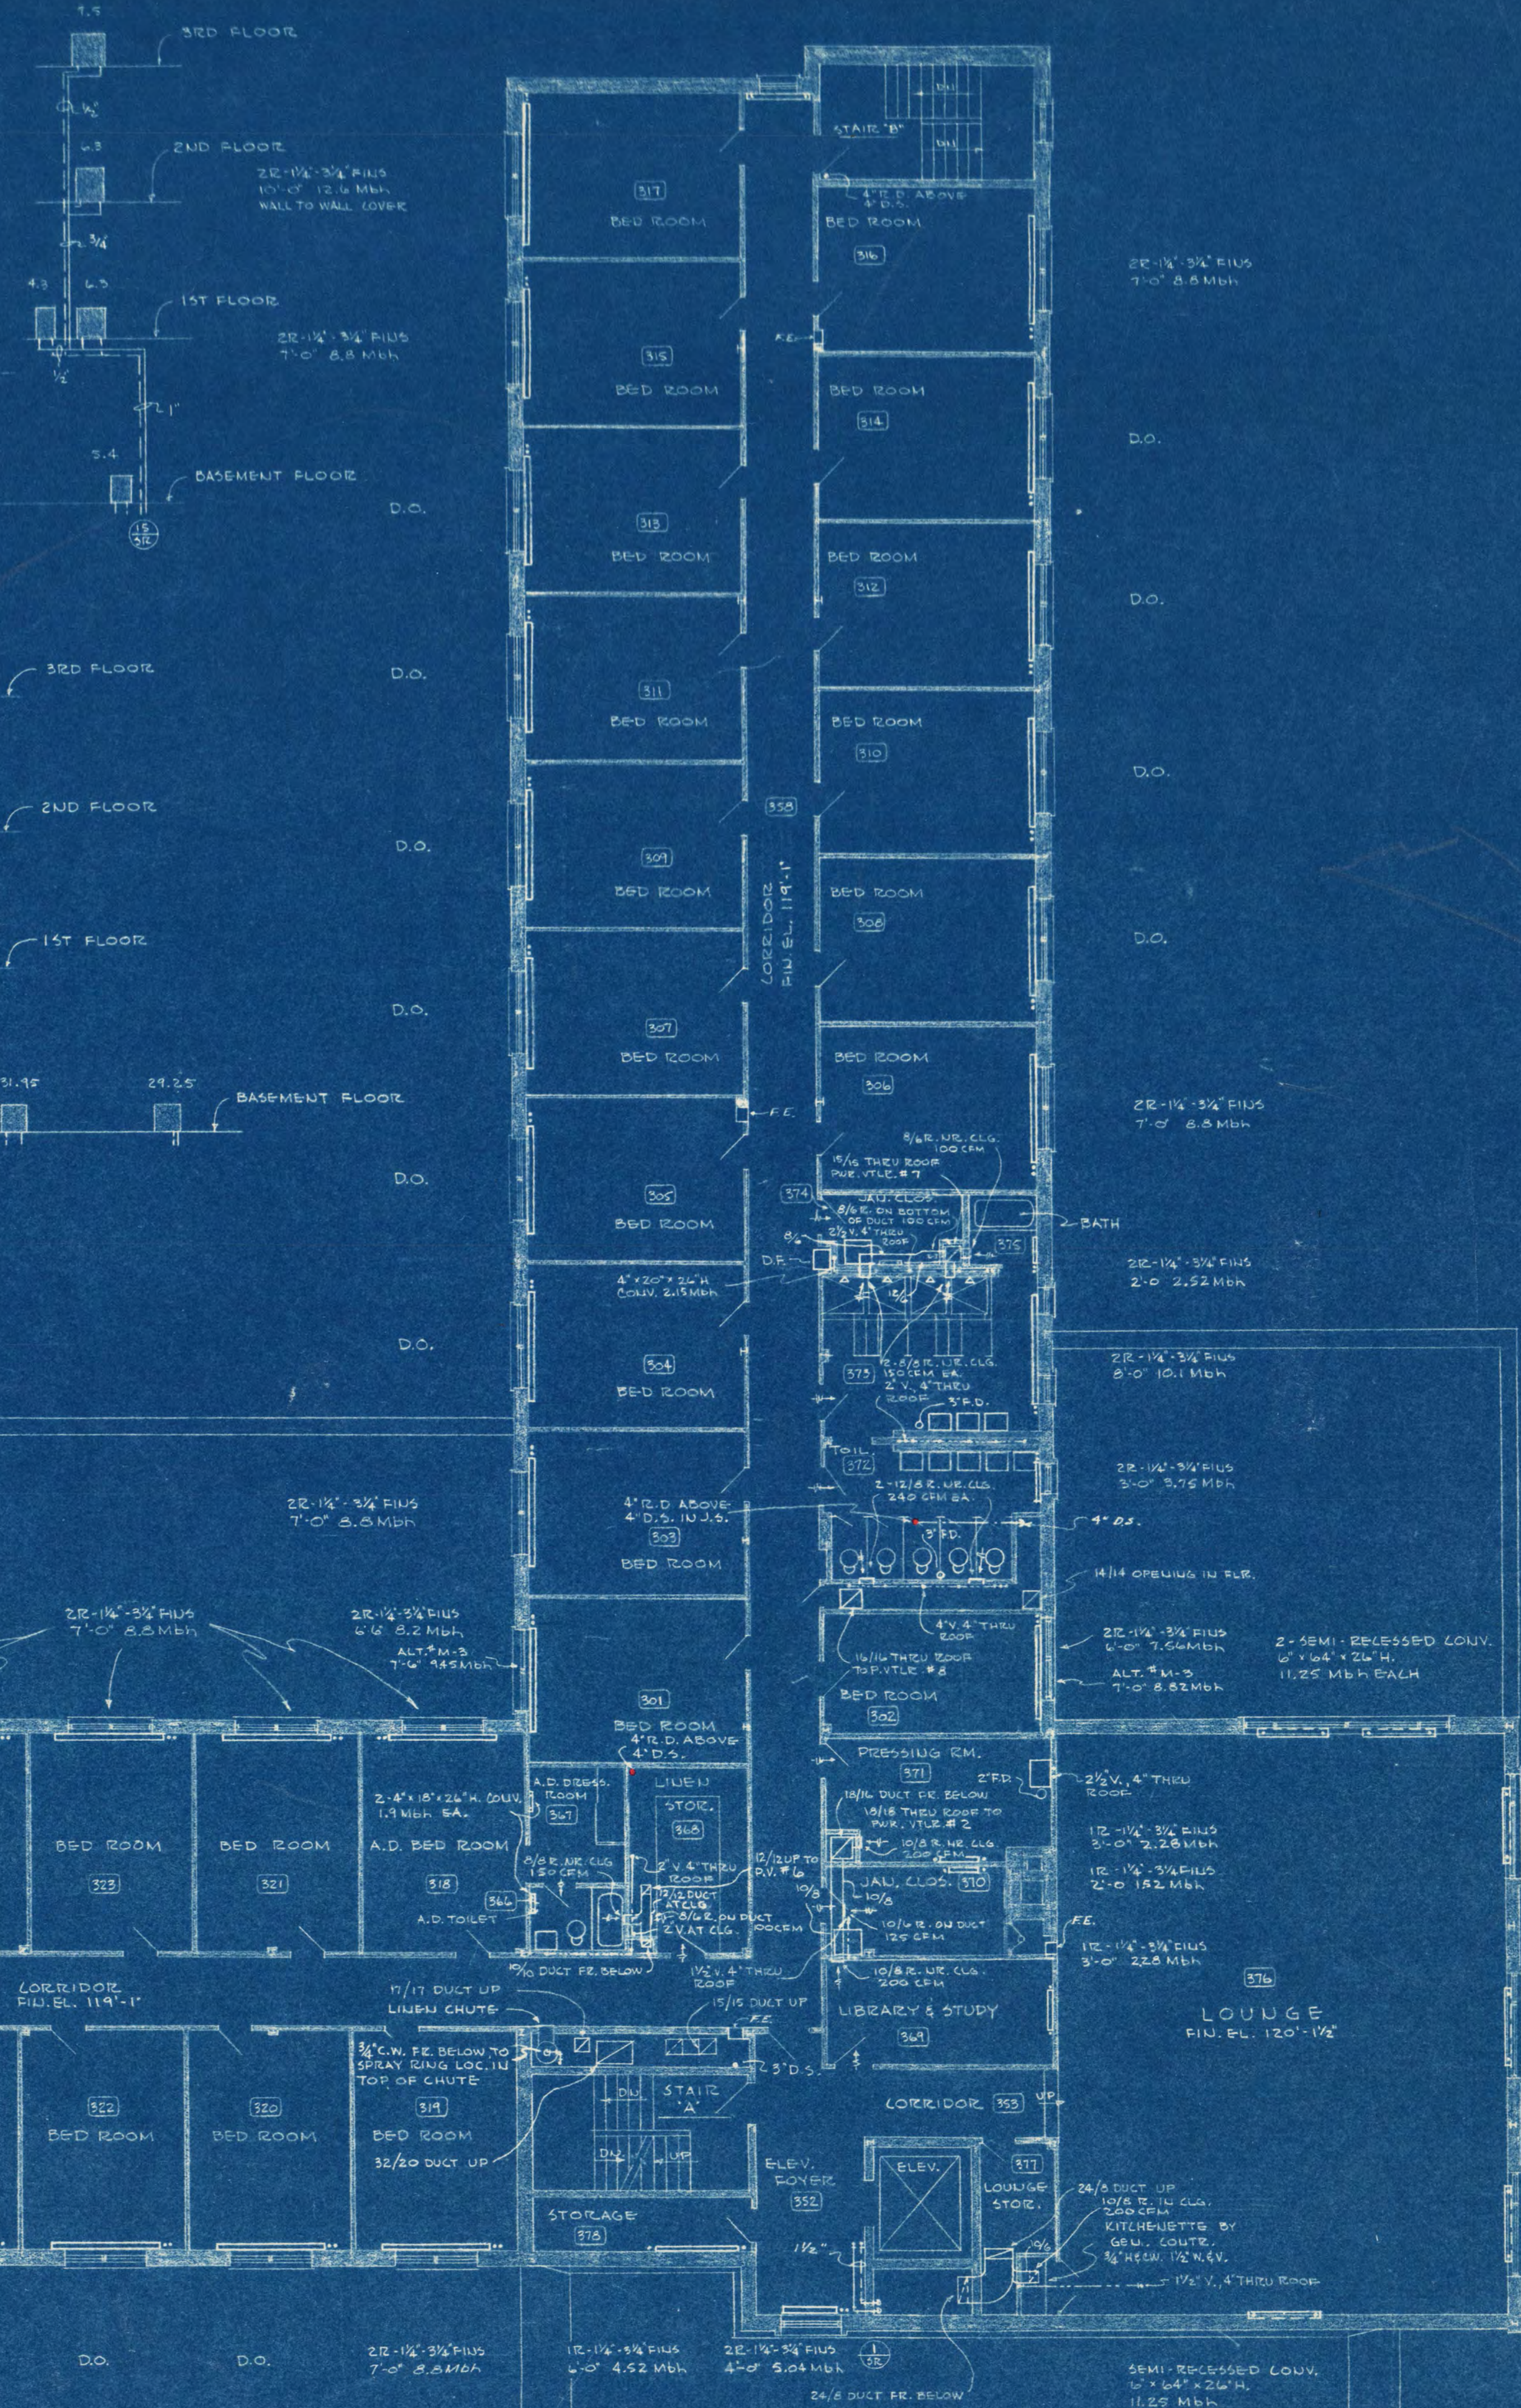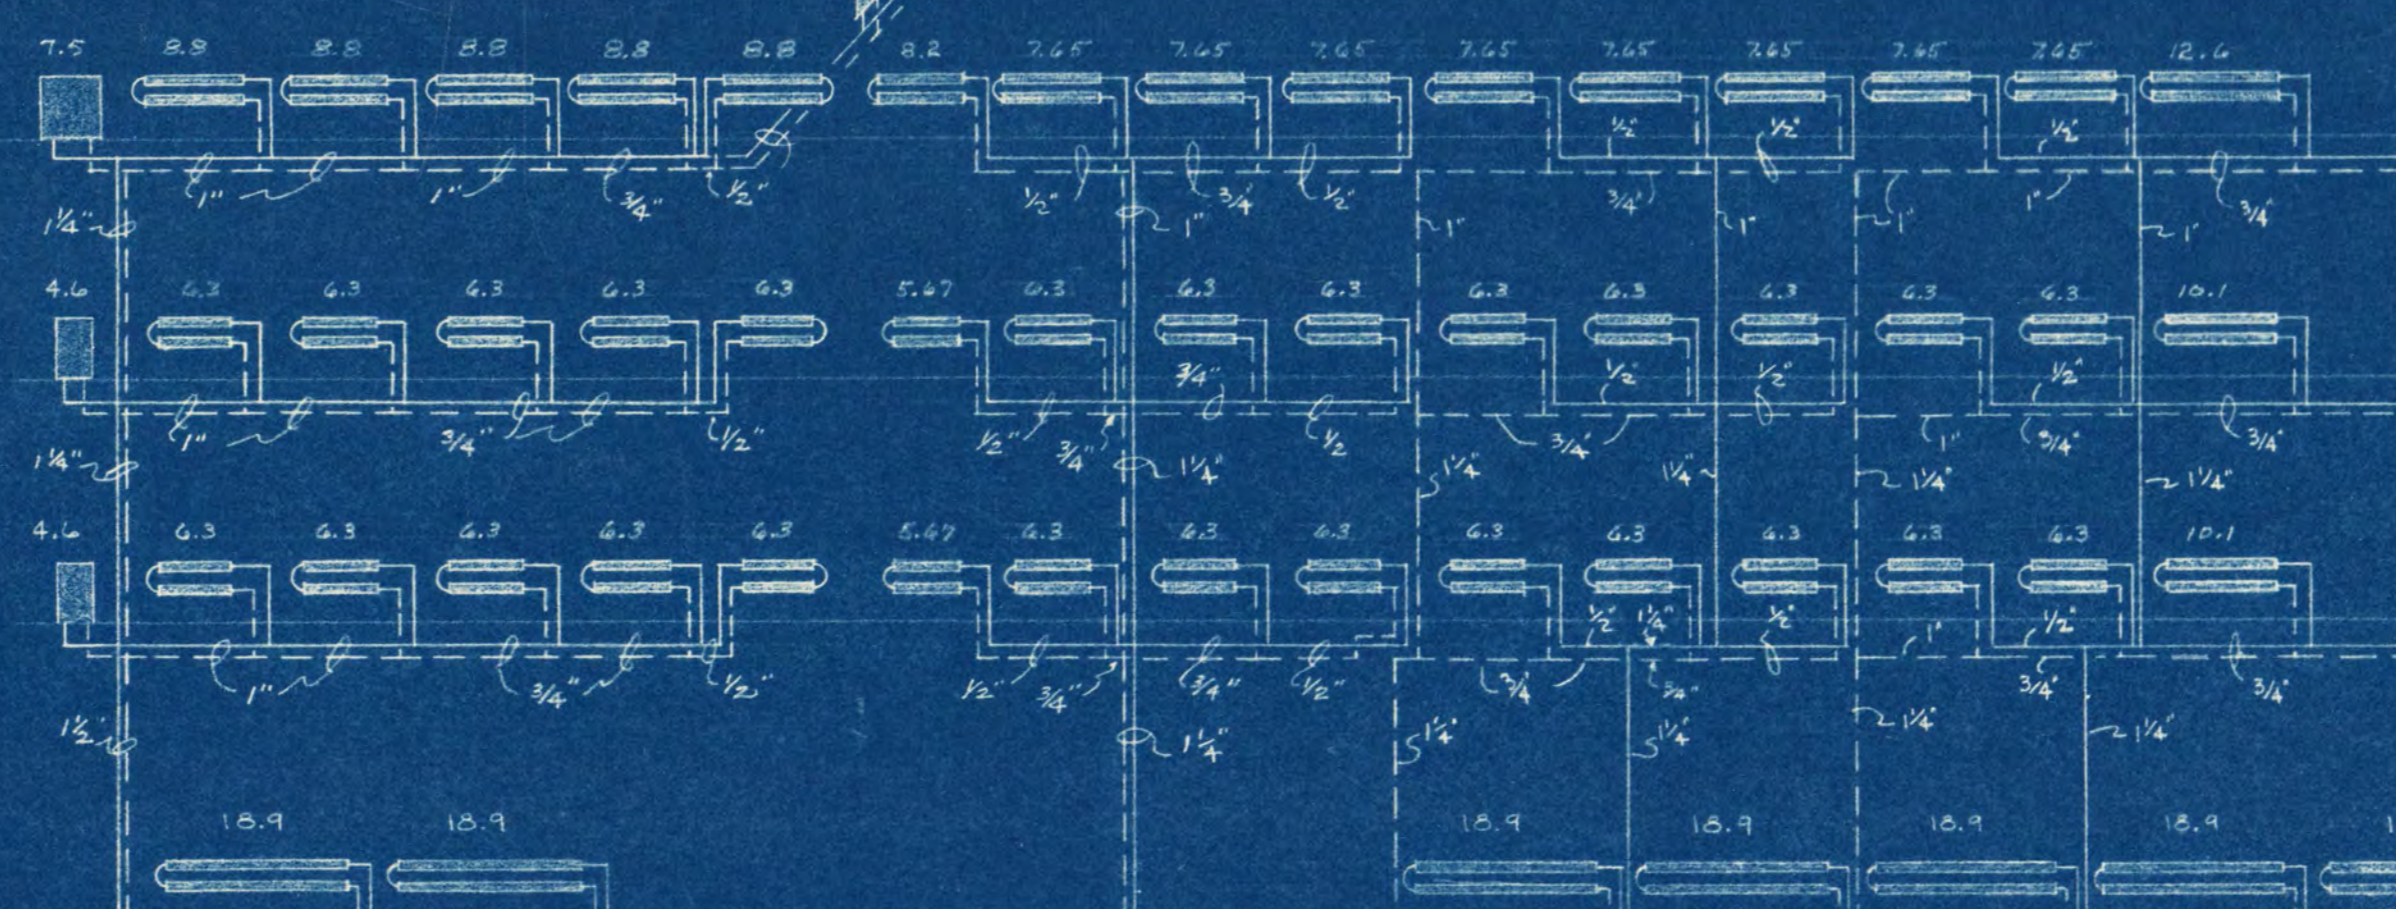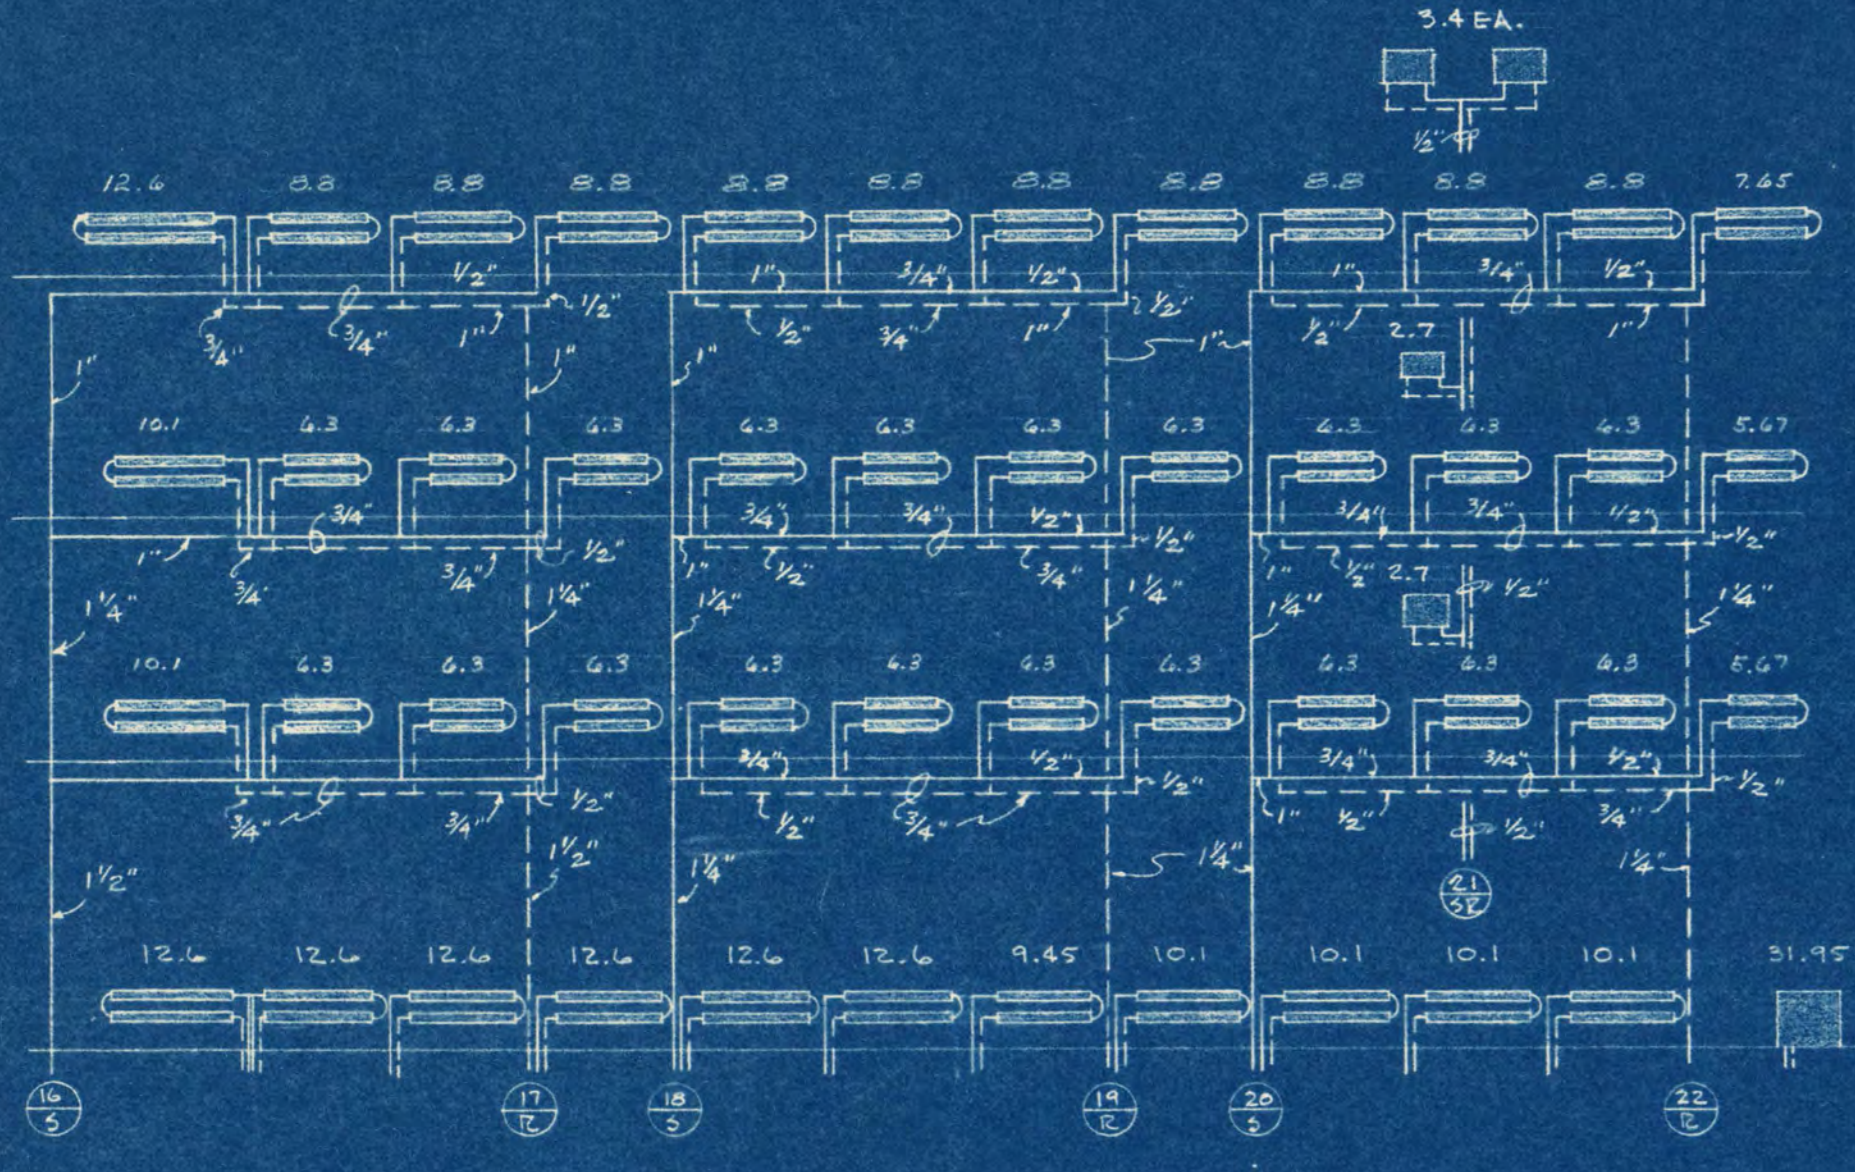

THIRD FLOOR PLAN
SCALE 1/8" = 1'-0"

NOTE:
ALL HORIZONTAL PIPING SHOWN ON THIS FLOOR PLAN
SHALL BE CONCEALED IN PIPE SPACES, JOISTS, OR WALLS
UNLESS NOTED OTHERWISE.

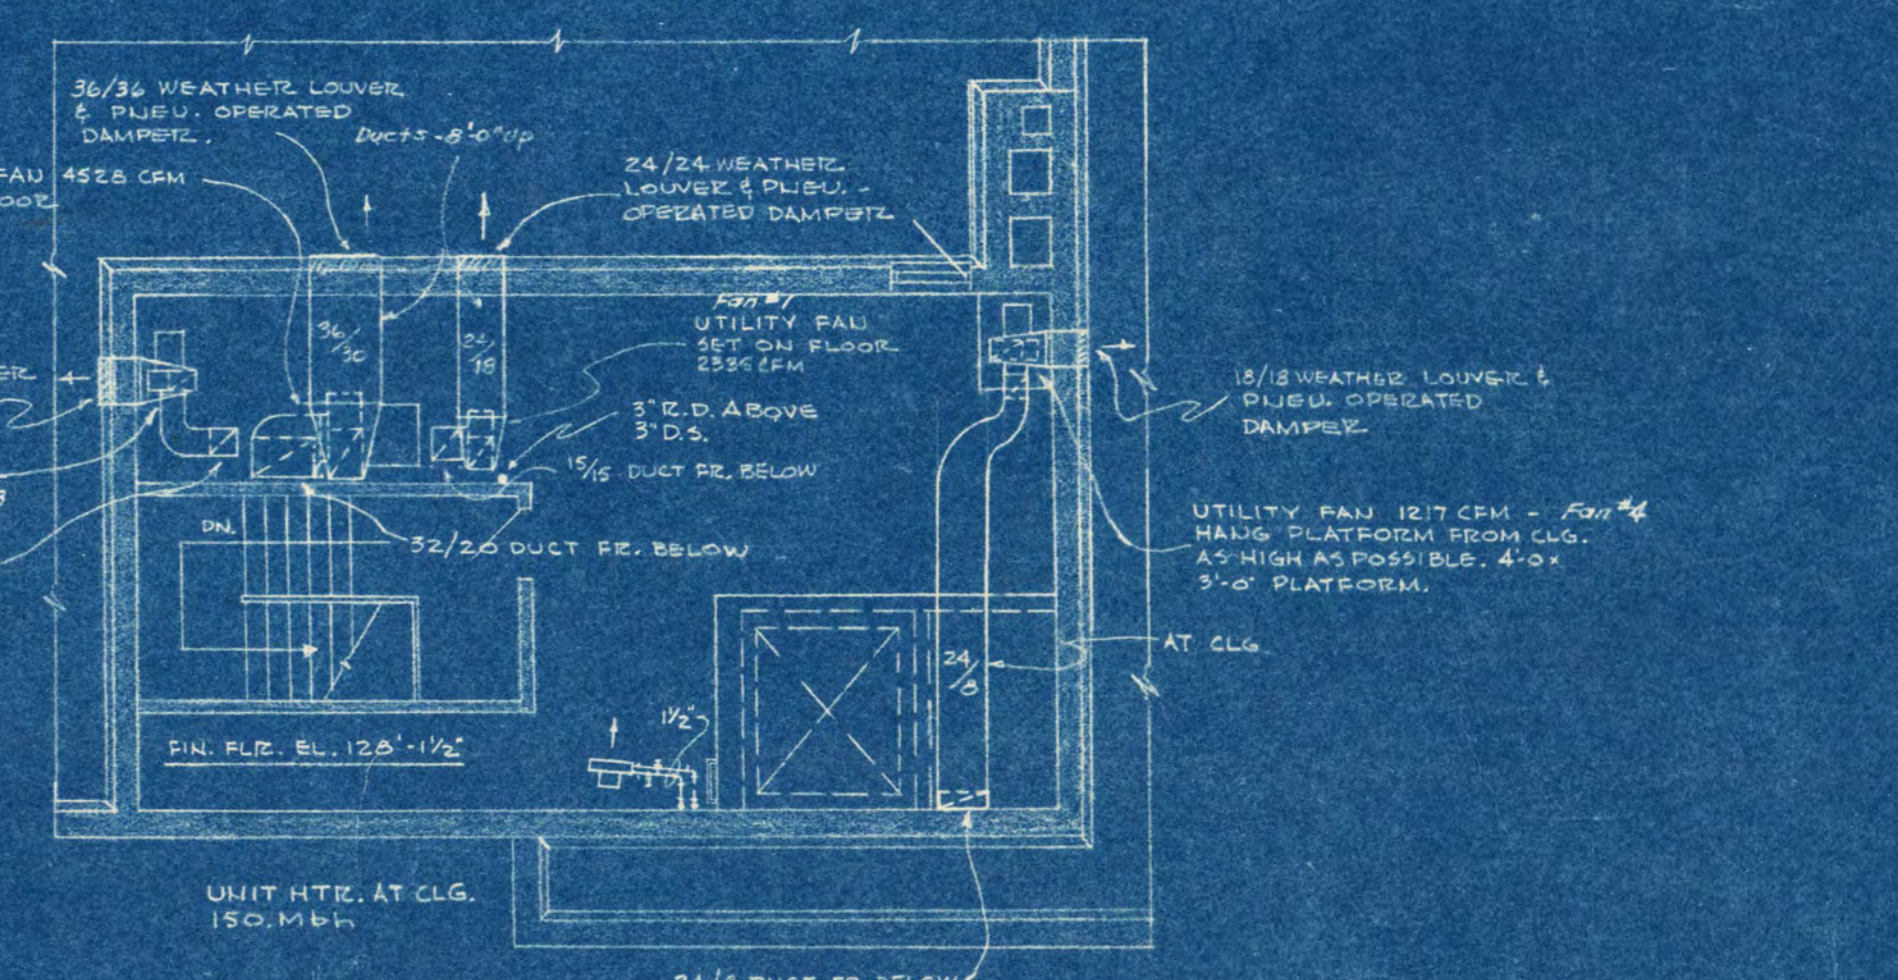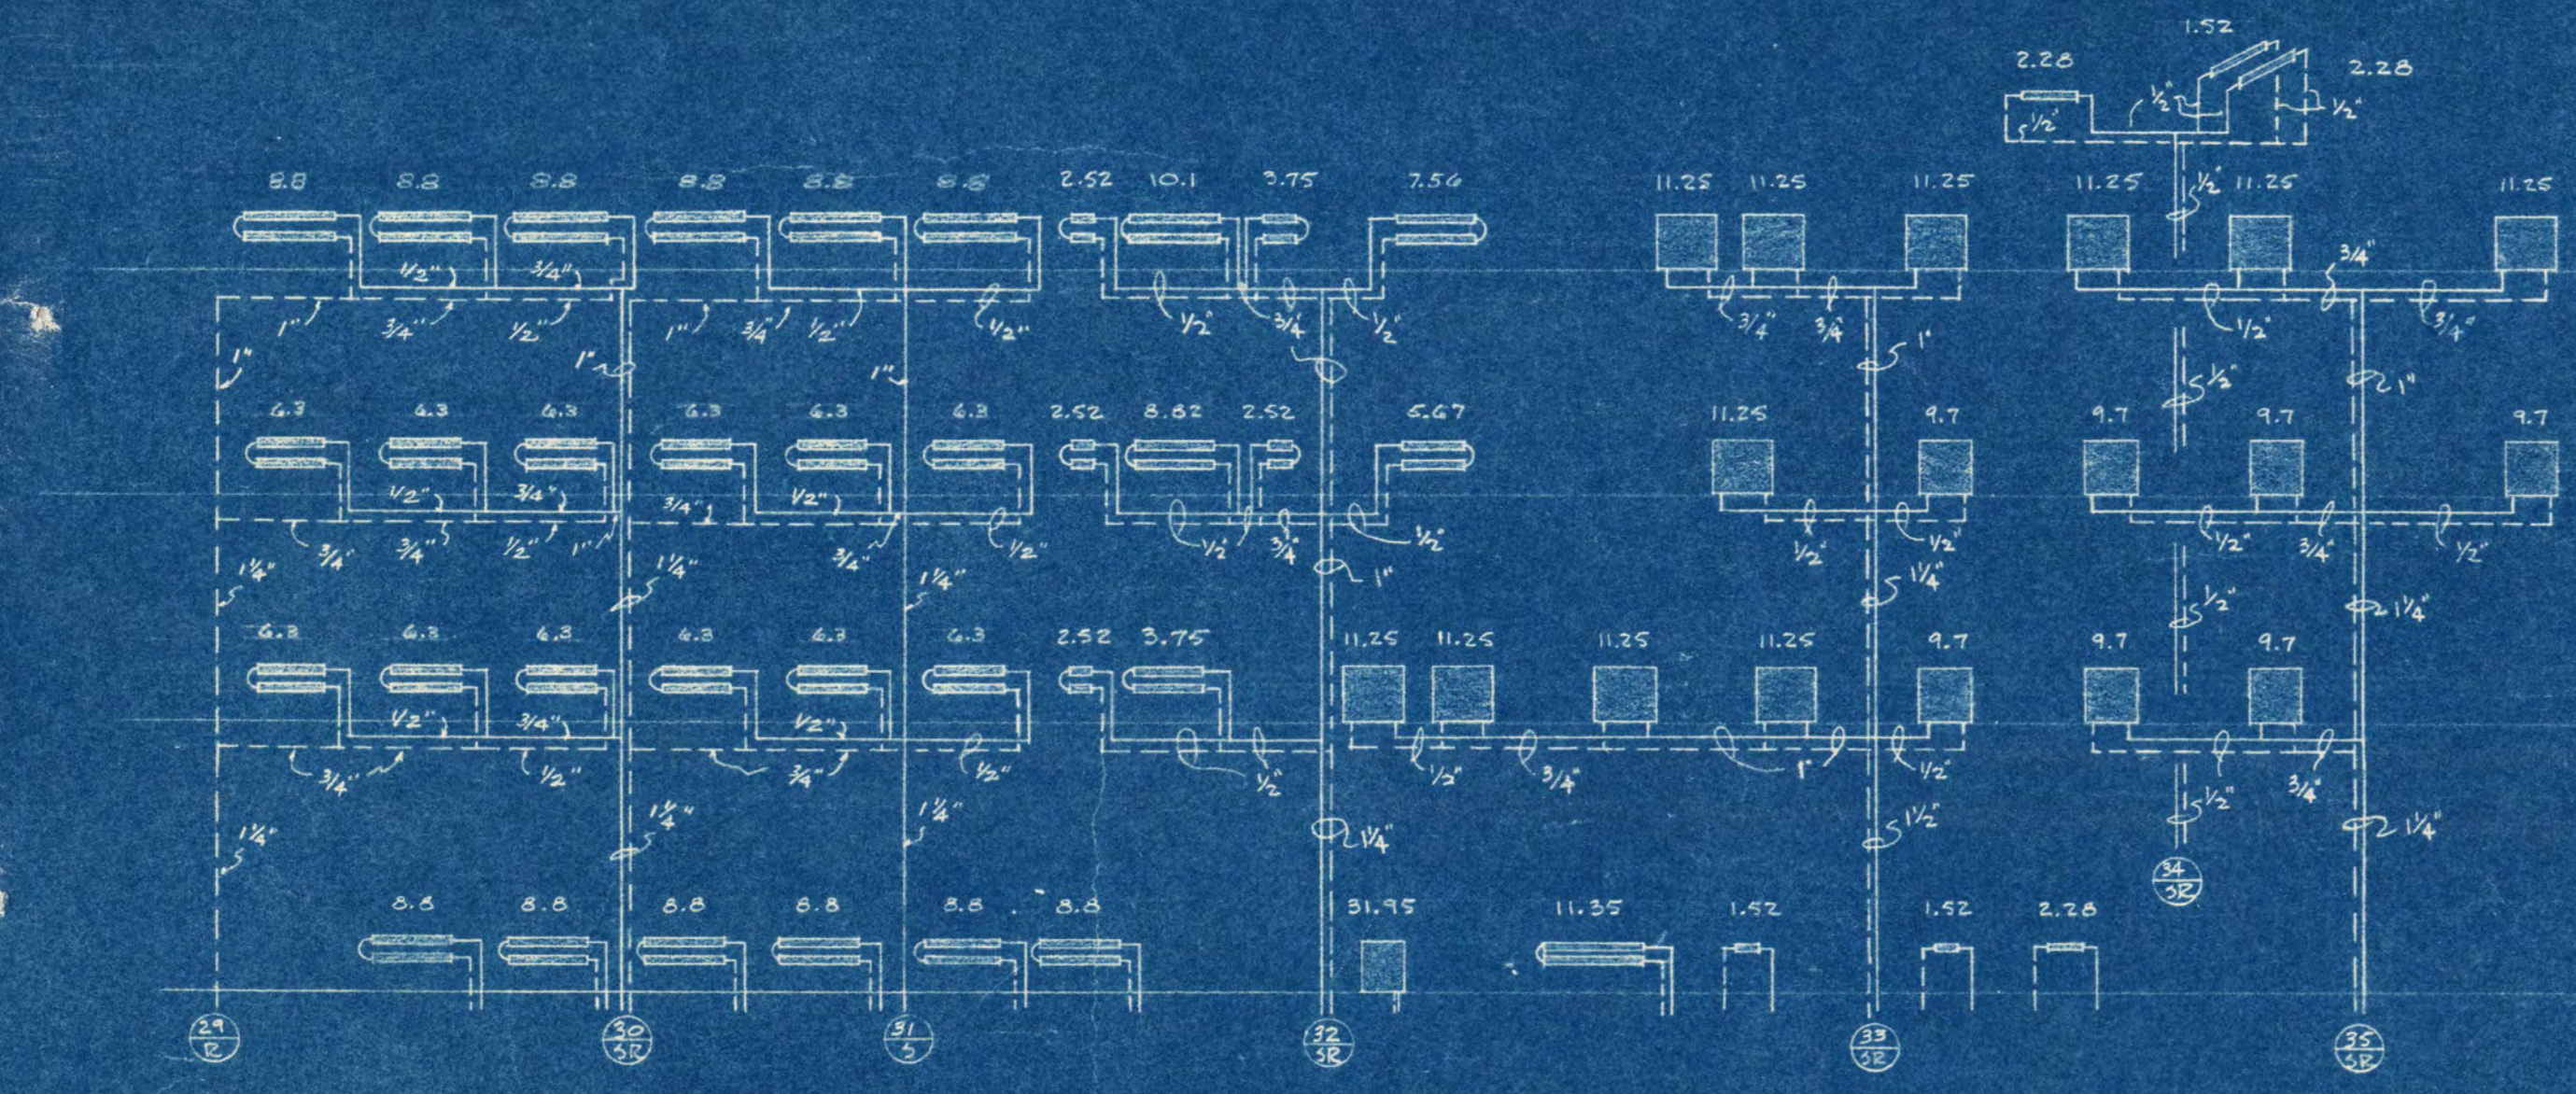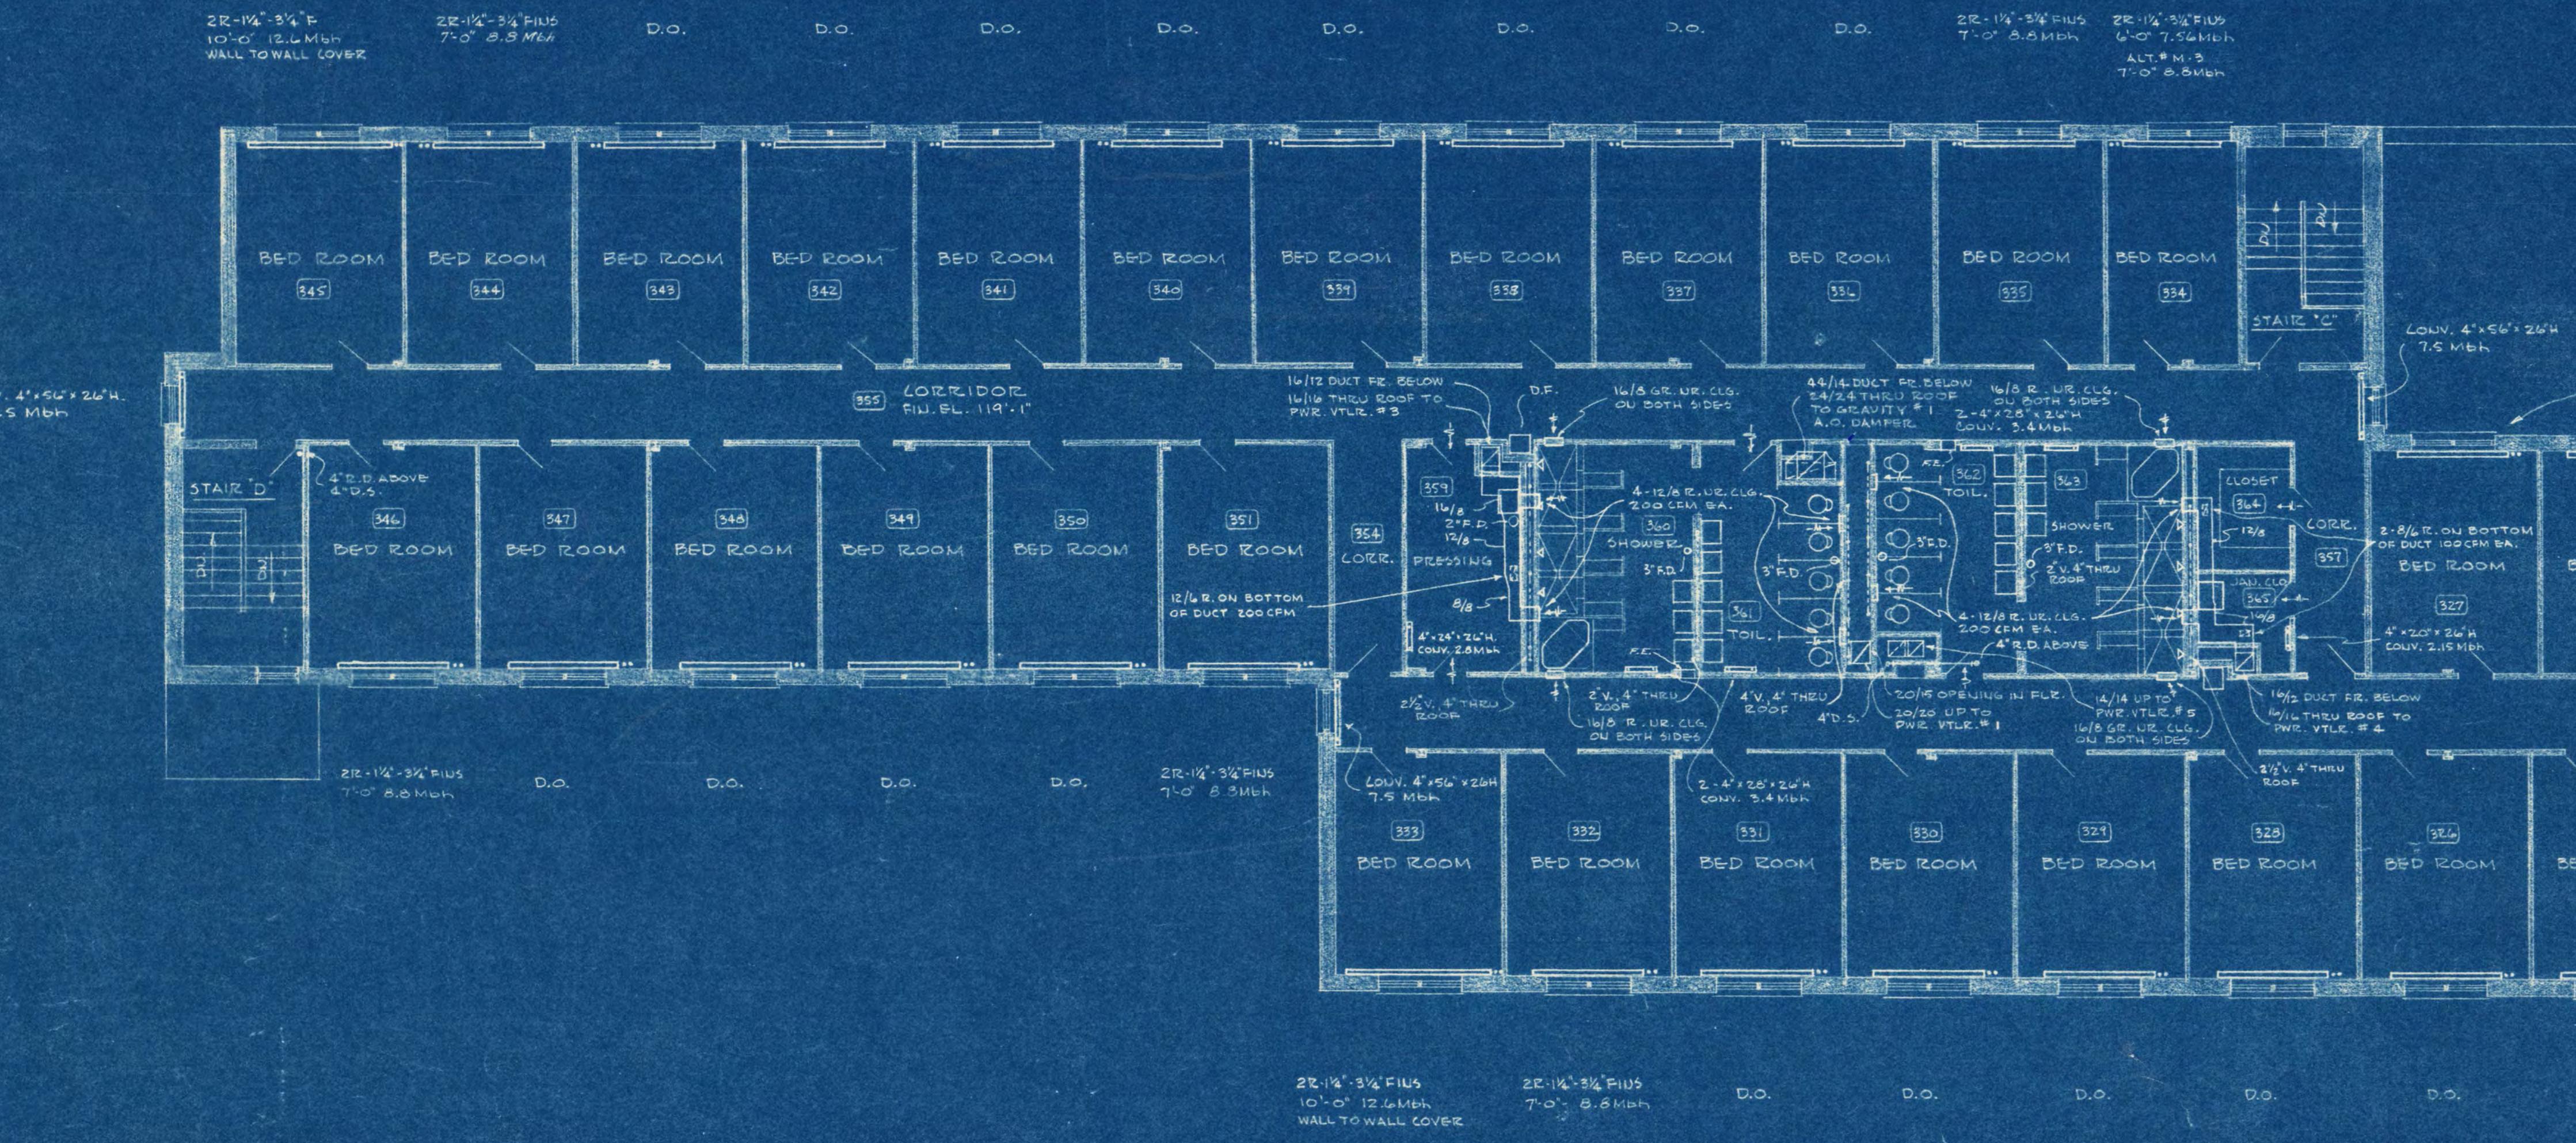

PENTHOUSE FLOOR PLAN
SCALE 1/8" = 1'-0"

GIRL'S DOORMITORY
ST. CLOUD STATE TEACHERS COLLEGE
ST. CLOUD, MINNESOTA

CONTRACT NO. 456-16

DATE 6-15-56

PROJECT NO. 1000

DESIGNED BY FRANK W. JACKSON & ASSOCIATES, INC.
ARCHITECTS & ENGINEERS
ST. CLOUD, MINNESOTA

ENGINEERED BY D. M. ORR ENGINEERING CO.
MINNEAPOLIS, MINNESOTA

DATE 6-15-56

PROJECT NO. 1000

PREPARED FOR ST. CLOUD STATE COLLEGE

APPROVED BY FRANK W. JACKSON & ASSOCIATES, INC.

APPROVED BY D. M. ORR ENGINEERING CO.

APPROVED BY ST. CLOUD STATE COLLEGE

SCALE 1/8" = 1'-0"

OF 6

M-6